


- LEGEND**
- PROPOSED PORTLAND CEMENT CONCRETE PAVEMENT 8" (JOINTED)
 - PROPOSED PCC DRIVEWAY PAVEMENT (6" FOR P.E. - 8" FOR C.E.)
 - PROPOSED SIDEWALK RAMP
 - DETECTABLE WARNINGS (SEE DETAIL SHEET)
 - PROPOSED SODDING
 - PROPOSED REVERSE GUTTER SLOPE

PROPOSED CURVE DATA
 P.I. STA. 103+75.02
 $\Delta = 8^{\circ}49'12''$
 $D = 198.19'$
 $T = 338.57'$
 $R = 4390.00'$
 $L = 675.79'$
 $E = 13.04'$
 P.C. STA. 100+36.46
 P.T. STA. 107+12.25
 S.E. = SEE PROPOSED TYPICAL SECTIONS AND INTERSECTION DETAILS

NOTE 1
 THERE IS A POSSIBLE SEPTIC SYSTEM IN THIS AREA. STOP EXCAVATING AND NOTIFY THE ENGINEER IF PIPING OR SEPTIC SOIL CONDITIONS ARE ENCOUNTERED.

FOR REMOVAL/RELOCATION PLAN IN THIS AREA SEE SHEET NO. 13

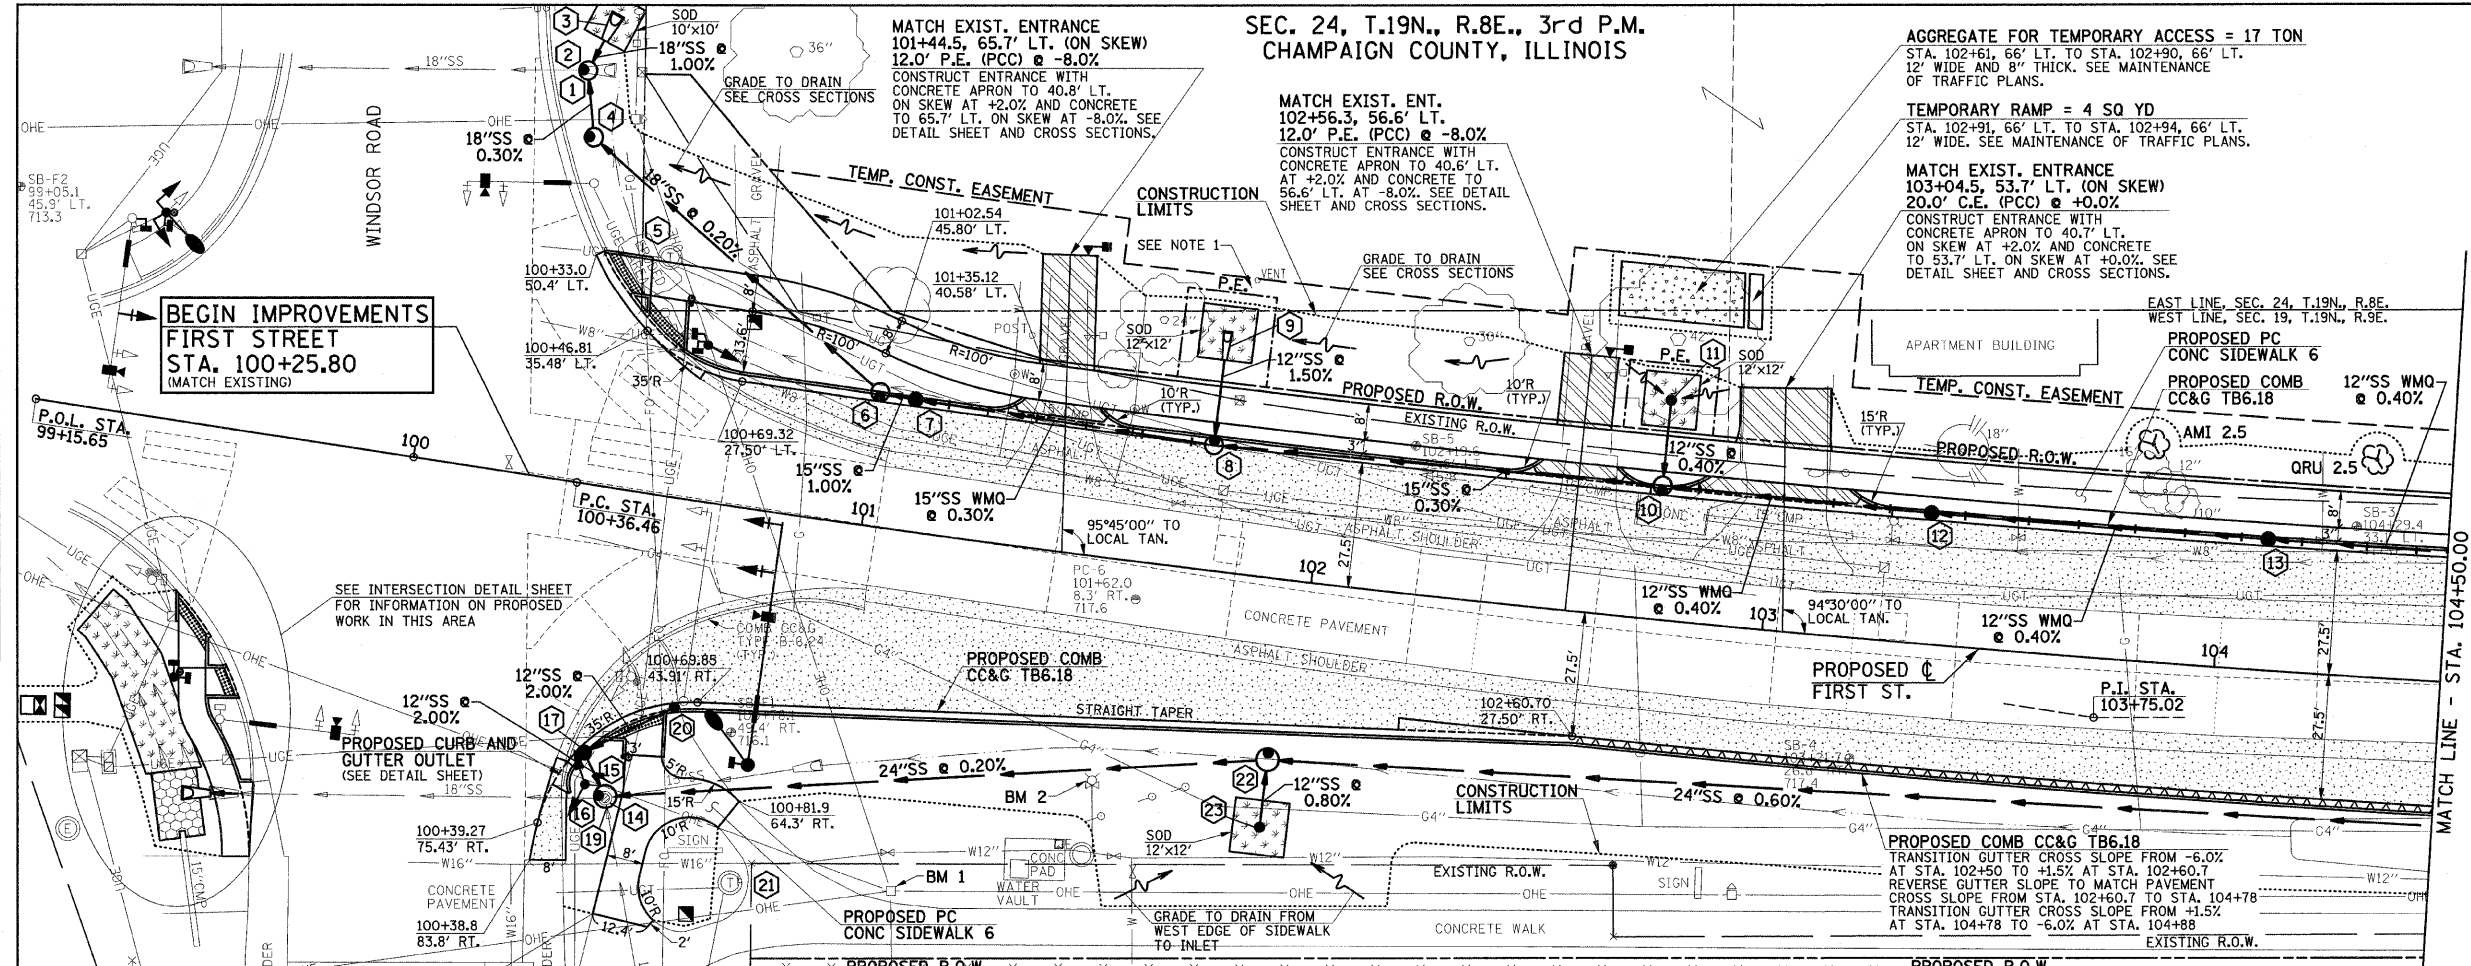

SEC. 19, T.19N., R.9E., 3rd P.M. CHAMPAIGN COUNTY, ILLINOIS

TREE PLANTING SCHEDULE

ABBREVIATION	BOTANICAL NAME	COMMON NAME	SIZE	STATION	OFFSET
AMI 2.5	ACER MIYABE "MORTON"	STATE STREET MIYABE MAPLE	2 1/2" C	103+83.0	48.0' LT.
QRU 2.5	QUERCUS RUBRA	RED OAK	2 1/2" C	104+33.0	48.0' LT.

(SEE DETAIL SHEET)

BM 1 - YELLOW PEG IN POWER POLE AT NORTHEAST QUADRANT OF FIRST ST. AND WINDSOR RD. STA. 101+17, 79' RT. ELEV. 720.18


BM 2 - EAST TOP FLANGE BOLT OF FIRE FYDRANT AT NORTHEAST QUADRANT OF FIRST ST. AND WINDSOR RD. - STA. 101+58, 49' RT. ELEV. 716.95

SEE SCHEDULE OF QUANTITIES FOR TYPICAL SECTION PAVEMENT PAY ITEMS AND THEIR LOCATIONS.

SEE PAVEMENT JOINTS, INTERSECTION DETAILS AND DRAINAGE STRUCTURE AND PIPE SCHEDULES FOR ADDITIONAL INFORMATION.

SEE THE STAGE CONSTRUCTION AND MAINTENANCE OF TRAFFIC PLANS FOR THE VARIOUS STAGES AND CONSTRUCTION SEQUENCES ON FIRST ST.

PERMANENT SURVEY MARKERS = 1 EACH SURVEY MARKER VAULT = 1 EACH
 SW. COR., SEC. 19, T.19N., R.9E., 3RD P.M. (STA. 100+71.20, 43.64' LT.) (SEE DETAIL SHEET AND SPECIAL PROVISIONS)
 NOTE: THE ENGINEER WILL BE RESPONSIBLE FOR RE-ESTABLISHING THE SURVEY MARKER AT THE SE. COR., SEC. 24, T.19N., R.8E., 3RD P.M. (STA. 100+44.87, 39.72' LT.) AFTER CONSTRUCTION IS COMPLETED.

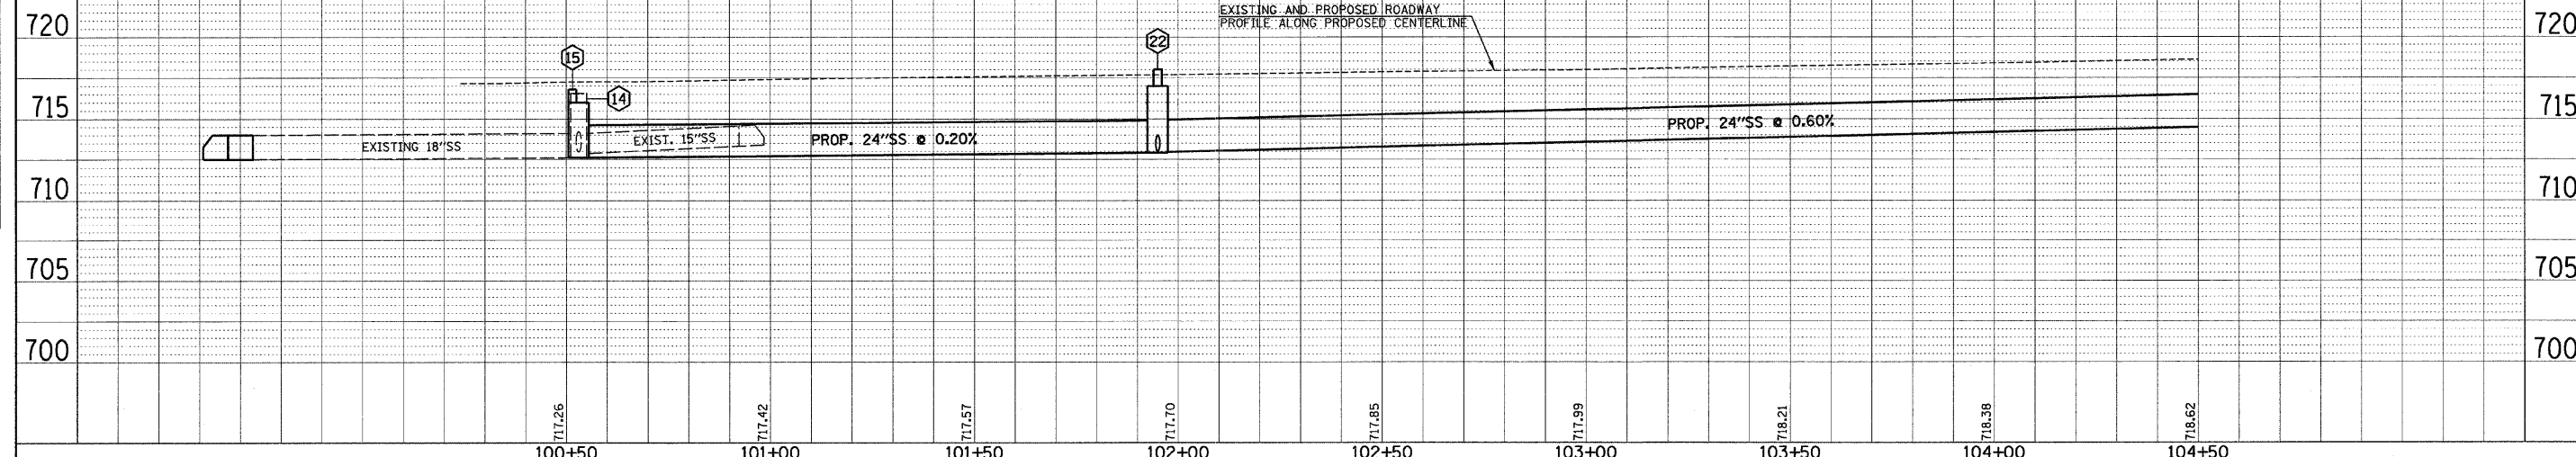

FILE NAME = p:\c0010461\plans\sheet\firstpp.dgn
 PLOT DATE = 2/6/2009 11:05:48 AM

DESIGNED - R.L.H.	REVISED -
DRAWN - J.L.B.	REVISED -
CHECKED - J.T.P.	REVISED -
DATE - 2-09	REVISED -

STATE OF ILLINOIS
 DEPARTMENT OF TRANSPORTATION

PLAN AND PROFILE - FIRST STREET

SCALE: 1"=20' SHEET NO. 15 OF 44 SHEETS STA. 100+00.00 TO STA. 104+50.00

F.A.U. RTE.	SECTION	COUNTY	TOTAL SHEETS	SHEET NO.
7170	08-00277-00-PV	CHAMPAIGN	44	15

CONTRACT NO. 91397
 ILLINOIS FED. AID PROJECT HD-5181 (044)