

..\\BDCONN-11-MOTIFLDGN, ..\\BDCONN-10-LAYOUTLDGN, ..\\BDCONN-99-MOTIFLDGN, ..\\BDCONN-11-HOMLDGN, ..\\BDCONN-99-HOMLDGN, ..\\BDCONN-10-ALIGNMENTLDGN, ..\\BDCONN-10-CIVIL CAD\\99 ALL CONTRACTS\\CONNSHEETS\\CONTRACT 10\\BDCONN-10-SHT-INDEX.LDN
7-22-2011 15:43:57 BONDHUJO \\FS-0044\\MYVAUL.D-TRANS.07-2202\\20868-001\\CIVIL CAD\\99 ALL CONTRACTS\\CONNSHEETS\\CONTRACT 10\\BDCONN-10-SHT-INDEX.LDN

INDEX OF SHEETS

SHEET NO.	DESCRIPTION
1	COVER SHEET
2 - 3	INDEX OF SHEETS/ HIGHWAY STANDARDS/ GENERAL NOTES
4 - 8	SUMMARY OF QUANTITIES
9 - 14	TYPICAL SECTIONS
15 - 19	SCHEDULE OF QUANTITIES
20 - 27	ALIGNMENT, TIES, AND BENCHMARKS
28	CONSTRUCTION LIMITS
29 - 32	EXISTING ROADWAY AND REMOVAL PLANS
32A- 32C	PRELIMINARY SITE INVESTIGATION & CLEARING PLANS
33 - 36	PROPOSED ROADWAY PLANS
37 - 40	PROPOSED ROADWAY PROFILES
41 - 43	PROPOSED GRADING PLANS
44 - 45	GROUND IMPROVEMENT PLANS
46 - 50	MAINTENANCE OF TRAFFIC AND SUGGESTED STAGING
51 - 56	EROSION AND SEDIMENT CONTROL PLANS
57 - 61	EXISTING DRAINAGE AND UTILITY REMOVAL PLANS
62 - 65	PROPOSED DRAINAGE PLANS
66 - 69	PROPOSED DRAINAGE PROFILES
70 - 75	EROSION CONTROL, DRAINAGE DETAILS
76 - 87	UTILITY PLANS BY TBE
88 - 101	SOIL PROFILES
102 - 107A	PLAT OF HIGHWAYS
108 - 110	INTERSECTION AND JOINTING DETAILS
111 - 114	ROADWAY DETAILS
115 - 121	LIGHTING PLANS
122 - 135	ANCHORAGE SLAB AND BARRIER WALL DETAILS
136 - 192	STRUCTURE PLANS - RELOCATED IL RTE 3 OVER I-70 (082-0328)
193 - 255	STRUCTURE PLANS - RELOCATED IL RTE 3 OVER TRRA & ST. CLAIR AVE. (082-0329)
256 - 280	STRUCTURE PLANS - PROPOSED I-70 RETAINING WALL (082-W308)
281 - 312	STRUCTURE PLANS - PROPOSED RAMP A RETAINING WALL (082-W309)
313 - 345	CROSS SECTIONS

HIGHWAY STANDARDS

000001	-06	STANDARD SYMBOLS, ABBREVIATIONS AND PATTERNS
001001	-02	AREAS OF REINFORCEMENT BARS
001006		DECIMAL OF AN INCH AND OF A FOOT
280001	-05	TEMPORARY EROSION CONTROL SYSTEMS
420001	-07	PAVEMENT JOINTS
420101	-04	24' JOINTED PCC PAVEMENT
420106	-04	36' JOINTED PCC PAVEMENT
420111	-03	PCC PAVEMENT ROUNDOUTS
420401	-08	BRIDGE APPROACH PAVEMENT CONNECTOR
483001	-04	PCC SHOULDER
515001	-03	NAME PLATE FOR BRIDGES
542301	-03	PRECAST REINFORCED CONCRETE END SECTIONS
601001	-04	SUB-SURFACE DRAINS
601101	-01	CONCRETE HEADWALL FOR PIPE DRAIN
602001	-02	CATCH BASIN TYPE A
602306	-03	INLET - TYPE B
602401	-03	MANHOLE TYPE A
602601	-02	PRECAST REINFORCED CONCRETE FLAT SLAB TOP
602701	-02	MANHOLE STEPS
604001	-03	FRAME AND LIDS TYPE 1
604071	-04	FRAME AND GRATE TYPE 20
606001	-04	CONCRETE CURB TYPE B AND COMBINATION CONCRETE CURB AND GUTTER
606301	-04	PC CONCRETE ISLANDS AND MEDIANS
664001	-02	CHAIN LINK FENCE
701001	-02	OFF-RD OPERATIONS, 2L, 2W, MORE THAN 15' AWAY
701006	-03	OFF-RD OPERATIONS, 2L, 2W, 15' TO 24" FROM PAVEMENT EDGE
701011	-02	OFF-RD MOVING OPERATIONS, 2L, 2W, DAY ONLY
701301	-04	LANE CLOSURE, 2L, 2W, SHORT TIME OPERATIONS
701501	-06	URBAN LANE CLOSURE, 2L, 2W, UNDIVIDED
701901	-01	TRAFFIC CONTROL DEVICES

SHEET 32C ADDED

INDICATES PAYMENT INCLUDED IN COST OF ANOTHER ITEM.

GENERAL NOTES


- ILLINOIS STATE LAW REQUIRES A 48 - HOUR NOTICE BE GIVEN TO ALL UTILITIES BEFORE DIGGING. FIELD MARKING OF FACILITIES MAY BE OBTAINED BY CONTACTING J.U.L.I.E. OR FOR NON-MEMBERS, THE UTILITY COMPANY DIRECTLY. AGENCIES KNOWN TO HAVE FACILITIES WITHIN THE PROJECT AREA ARE AS FOLLOWS:
 - AmerenCIPS - ELECTRIC
 - AmerenIP - GAS
 - AT&T ILLINOIS - COMMUNICATIONS
 - ILLINOIS AMERICAN WATER COMPANY - WATER
 - QWEST SOLUTIONS CENTER - COMMUNICATIONS
 - SHO-ME TECHNOLOGIES - COMMUNICATIONSMETRO EAST SANITARY DISTRICT (M.E.S.D.) - TRIPLE CELL BOX CULVERT, 5' X 5' COMBINED SEWER BOX
- MEMBERS OF J.U.L.I.E. (800-892-0123) AREA INDICATED BY AN *. NON-J.U.L.I.E. MEMBERS MUST BE NOTIFIED INDIVIDUALLY.
- THE ATTENTION OF THE CONTRACTOR IS DIRECTED TO THE PLANS AND SPECIAL PROVISION FOR STATUS OF UTILITIES TO BE ADJUSTED FOR POTENTIAL UTILITY CONFLICTS.
- THE ATTENTION OF THE CONTRACTOR IS DIRECTED TO THE FACT THAT THERE ARE WATER MAINS MAINTAINED BY THE ILLINOIS AMERICAN WATER COMPANY (IAWC) WITHIN THE R.O.W. THE CONTRACTOR SHALL LOCATE THE WATER MAIN LOCATIONS IN CONJUNCTION WITH IAWC PRIOR TO COMMENCEMENT OF CONSTRUCTION IN THESE AREAS.
- THE CONTRACTOR WILL NOT BE ALLOWED TO SET UP A YARD OR FIELD OFFICE ON STATE PROPERTY WITHOUT WRITTEN PERMISSION FROM THE DEPARTMENT.
- BARRICADES: THE CONTRACTOR SHALL PROVIDE AND INSTALL TWO (2) WEIGHTED SANDBAGS ON EACH TYPE I OR TYPE II BARRICADE USED - ONE (1) WEIGHTED SAND BAG ACROSS EACH BOTTOM RAIL.
- THE CONTRACTOR SHALL BE RESPONSIBLE FOR THE PROTECTION OF ALL OVERHEAD, SURFACE, AND UNDERGROUND UTILITIES WITHIN THE PROJECT LIMITS WHETHER OR NOT THE UTILITIES ARE SHOWN ON THE PLANS. ANY UTILITY THAT IS DAMAGED DURING CONSTRUCTION SHALL BE REPLACED OR RELOCATED BY THE CONTRACTOR AT HIS/ HER OWN EXPENSE.
- THE CONTRACTOR SHALL USE CARE IN GRADING OR EXCAVATING NEAR ANY AND ALL EXISTING ITEMS WHICH WILL NOT BE REMOVED. ANY DAMAGE DONE TO EXISTING ITEMS BY THE CONTRACTOR SHALL BE REPAIRED/REPLACED BY THE CONTRACTOR AT THE CONTRACTORS' OWN EXPENSE.
- THE CONTRACTOR SHALL BE RESPONSIBLE FOR CONTACTING THE EAST ST. LOUIS AND THE FAIRMONT CITY FIRE AND POLICE DEPARTMENTS, AND MESD 14 WORKING DAYS PRIOR TO START OF CONSTRUCTION IN ORDER TO REVIEW AND COORDINATE THE CONSTRUCTION SCHEDULE.
 - EAST ST. LOUIS FIRE DEPT. CHIEF THOMAS GRIMMETT (618) 482-6875.
 - EAST ST. LOUIS POLICE DEPT. CHIEF LENZIE STEWART (618) 482-6740 OR 482-6700.
 - FAIRMONT CITY: FIRE AND POLICE DEPARTMENT: SCOTT PENNY (618) 274-4504 EXT. 2.
 - METRO EAST SANITARY DISTRICT (MESD): BOB SHIPLEY - (618) 452-9400
- CONTRACTOR SHALL BE RESPONSIBLE FOR CONTACTING THE STATE ARCHAEOLOGICAL ENGINEER - JOSEPH M. GALLOY, Ph.D., RPA (618) 251-3922 - 14 WORKING DAYS PRIOR TO START OF ANY PAVEMENT OR FOUNDATION REMOVAL.
- REMOVAL OF ANY EXISTING CURB AND GUTTER EMBEDDED IN BITUMINOUS PAVEMENT OR SHOULDER SHALL NOT BE MEASURED FOR REMOVAL, BUT SHALL BE INCLUDED IN THE COST OF THE PAVEMENT REMOVAL ITEM.
- THE EXISTING TOPOGRAPHY SHOWN ON THE PLANS REFLECTS THE FINAL CONDITION AFTER THE COMPLETION OF CONTRACTS 76C39, 76C40, 76C44, 76C68, 76C69, AND GRADING FROM CONCURRENT CONTRACT 76C41 AND DOES NOT NECESSARILY REFLECT CURRENT FIELD CONDITIONS.
- THE CONTRACTOR SHALL USE CAUTION WHEN EXCAVATING NEAR ANY RAILROAD LINE. THE DETAIL SHOWN ON SHEET 112 SHALL BE THE MINIMUM REQUIREMENTS FOR EXCAVATION IN THE VICINITY OF ANY RAILROAD.
- THE SCOPE OF THE CONTRACT PLANS INCLUDE THE REMOVAL OF BOTH 'VERIFIED' AND 'UNVERIFIED' UTILITY STRUCTURES, FIRE HYDRANTS, WATER MAIN, AND SEWERS WITHIN THE PROPOSED RIGHT OF WAY AS SPECIFIED AT THE LOCATIONS ON THE CONTRACT PLANS. THE PROCEDURE FOR THE REMOVAL OF THESE UTILITIES WILL BE PER THE SPECIAL PROVISION FOR "GUIDELINES FOR UNDERGROUND UTILITY REMOVALS".
- ABBREVIATIONS: T.E. = TEMPORARY EASEMENT, P.E. = PERMANENT EASEMENT.
- ALL DOWEL BARS AND TIE BARS UTILIZED IN PCC PAVEMENT SHALL BE EPOXY COATED.
- ALL MANHOLE LIDS OR INLET GRATES THAT ARE REMOVED DURING THIS CONTRACT SHALL REMAIN PROPERTY OF THE ILLINOIS DEPT. OF TRANSPORTATION AND SHALL BE REMOVED WITHOUT DAMAGE AND TRANSPORTED TO THE FOLLOWING ADDRESS: BOWMAN AVE, PUMP STATION, 728 EXCHANGE AVE., EAST ST. LOUIS, ILLINOIS - IF THERE ARE ANY QUESTIONS PLEASE CONTACT PETE SAWYER AT 618-346-3275.
- THE "ONE CALL" SERVICES WILL NOT LOCATE BURIED RAILROAD SIGNAL AND COMMUNICATIONS LINES. THE CONTRACTOR SHALL CONTACT THE RAILROADS REPRESENTATIVE 2 DAYS IN ADVANCE OF THOSE PLACES WHERE EXCAVATION, PILE DRIVING, OR HEAVY LOADS MAY DAMAGE RAILROAD UNDERGROUND LINES ON RAILROAD PROPERTY. UPON REQUEST FROM THE CONTRACTOR OR AGENCY, RAILROAD SIGNAL FORCES WILL LOCATE AND PAINT MARK OR FLAG UNDERGROUND SIGNAL, COMMUNICATION, AND POWER LINES IN THE AREA TO BE DISTURBED FOR THE CONTRACTOR. THE CONTRACTOR SHALL AVOID EXCAVATION OR OTHER DISTURBANCE OF THESE LINES WHICH ARE CRITICAL TO THE SAFETY OF THE RAILROAD AND THE PUBLIC. IF DISTURBANCE OR EXCAVATION IS REQUIRED NEAR A BURIED RAILROAD SIGNAL, COMMUNICATION OR POWER LINE, THE LINE SHALL BE POTHOLED MANUALLY WITH CAREFUL HAND EXCAVATION BY THE CONTRACTOR AND PROTECTED BY THE CONTRACTOR DURING THE COURSE OF THE DISTURBANCE UNDER THE SUPERVISION AND DIRECTION OF A RAILROAD SIGNAL REPRESENTATIVE. THE CONTRACTOR SHALL CONTACT BRUCE RENO OF TERMINAL RAILROAD AT (618) 451-8427 TO REQUEST THIS SERVICE.

GENERAL NOTES (CONTINUED)

- SETTLEMENT PLATFORMS SHALL NOT BE PAID FOR SEPARATELY, BUT SHALL BE CONSIDERED INCLUDED IN THE CONTRACT UNIT PRICE FOR FURNISHED EXCAVATION AND NO ADDITIONAL COMPENSATION WILL BE ALLOWED.
- FOR PAVEMENT REMOVAL, NO ADDITIONAL COMPENSATION WILL BE ALLOWED FOR VARIATIONS FROM ASSUMED THICKNESS OR FROM THE THICKNESS SHOWN ON THE PLANS.
- THE DEPARTMENT STRONGLY ENCOURAGES THE PRIME CONTRACTOR AND THEIR APPROVED SUB-CONTRACTORS TO HIRE MINORITY, WOMEN AND DISADVANTAGED INDIVIDUALS FROM ITS FEDERALLY FUNDED HIGHWAY CONSTRUCTION CAREERS TRAINING PROGRAM (HCCTP) TO HELP MEET WORKFORCE AND TRAINEE GOALS. THIS PROGRAM IS TRAINING MINORITIES, WOMEN AND DISADVANTAGED INDIVIDUALS IN HIGHWAY CONSTRUCTION-RELATED SKILLS, E.G., MATH FOR THE TRADES, JOB READINESS, TECHNICAL SKILLS COURSEWORK (CARPENTRY, CONCRETE FLATWORK, BLUEPRINT READING, SITE PLANS, SITE WORK, TOOLS USE, ETC.) AND OSHA 10 HOUR CERTIFICATION, TO PREPARE THEM FOR A CAREER IN THE HIGHWAY CONSTRUCTION TRADES. GRADUATES ARE WELL-TRAINED AND READY TO BECOME PRODUCTIVE ENTRY-LEVEL CONSTRUCTION WORKERS. CONTACT THE DISTRICT 8 EEO OFFICE AT 618-346-3360 AND/OR THE HCCTP COORDINATOR AT 618/874-6528 TO LEARN MORE ABOUT THE PROGRAM AND FOR ASSISTANCE IN MEETING WORKFORCE AND TRAINEE GOALS.
- THE RIGHT-OF-WAY SHOWN ON THE PLAT OF HIGHWAYS SHALL SUPERCEDE THE RIGHT-OF-WAY SHOWN ON ALL OTHER SHEETS.

COMMITMENTS

- ANY WATER WELLS FOUND DURING CONSTRUCTION WILL BE SEALED ACCORDING TO IEPA TO PREVENT GROUNDWATER POLLUTION FROM CONSTRUCTION AND FROM FUTURE ROADWAY MAINTENANCE. THIS WORK SHALL BE PAID FOR AS SEALING ABANDONED WATER WELLS. FORMS FOR SEALING WATER WELLS CAN BE OBTAINED FROM THE ENGINEER.
- THE TREE REMOVALS WILL BE MITIGATED IN A FUTURE CONTRACT AS PART OF THE IDOT TREE REPLACEMENT PROGRAM UNDER DEPARTMENT POLICY D & E-18.
- IF ASH TREES ARE REMOVED ON THE PROJECT, THE CONTRACTOR SHALL BECOME FAMILIAR WITH AND COMPLY WITH MEASURES SPECIFIED BY THE ILLINOIS DEPARTMENT OF AGRICULTURE (IDOA) TO PREVENT THE SPREAD OF THE EMERALD ASH BORER. THE IDOA INFORMATION FOR ASH TREE REMOVAL CAN BE FOUND ON THE IDOA WEBSITE AT: www.AGR.STATE.IL.US/EAB.

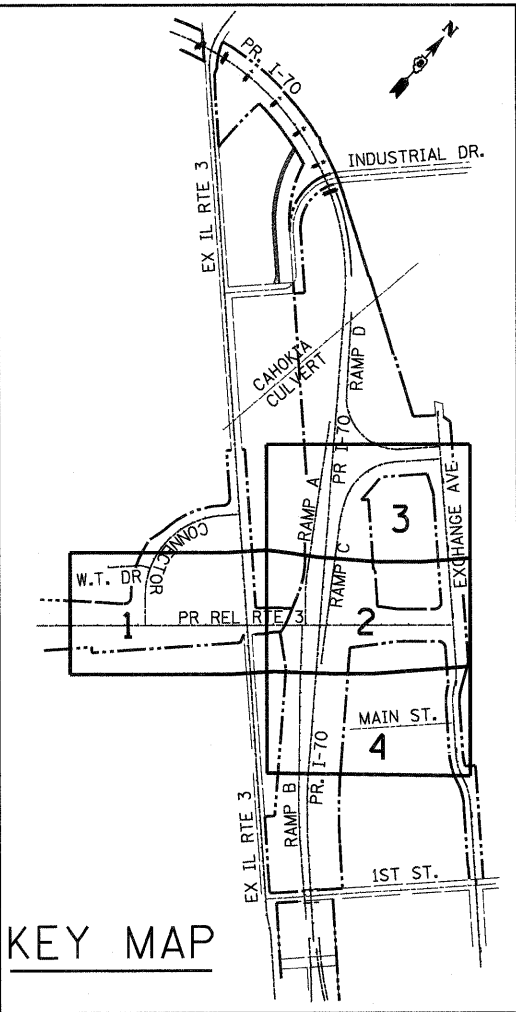

FILE NAME =	USER NAME = #USER#	DESIGNED - JB	REVISED 07/22/11 JB	STATE OF ILLINOIS DEPARTMENT OF TRANSPORTATION RELOCATED ILLINOIS ROUTE 3	INDEX OF SHEETS HIGHWAY STANDARDS AND GENERAL NOTES SCALE: N.T.S. SHEET NO. OF SHEETS STA. TO STA.	F.A.P. RTE.	SECTION	COUNTY	TOTAL SHEETS	SHEET NO.
#FILEL#		DRAWN - JB	REVISED -			998	82-2-1HVB-1	ST. CLAIR	345	2
	PLOT SCALE = #SCALE#	CHECKED - ACL	REVISED -			CONTRACT NO. 76D05				
	PLOT DATE = #DATE#	DATE - 05/13/11	REVISED -			FED. ROAD DIST. NO. ILLINOIS FED. AID PROJECT				