


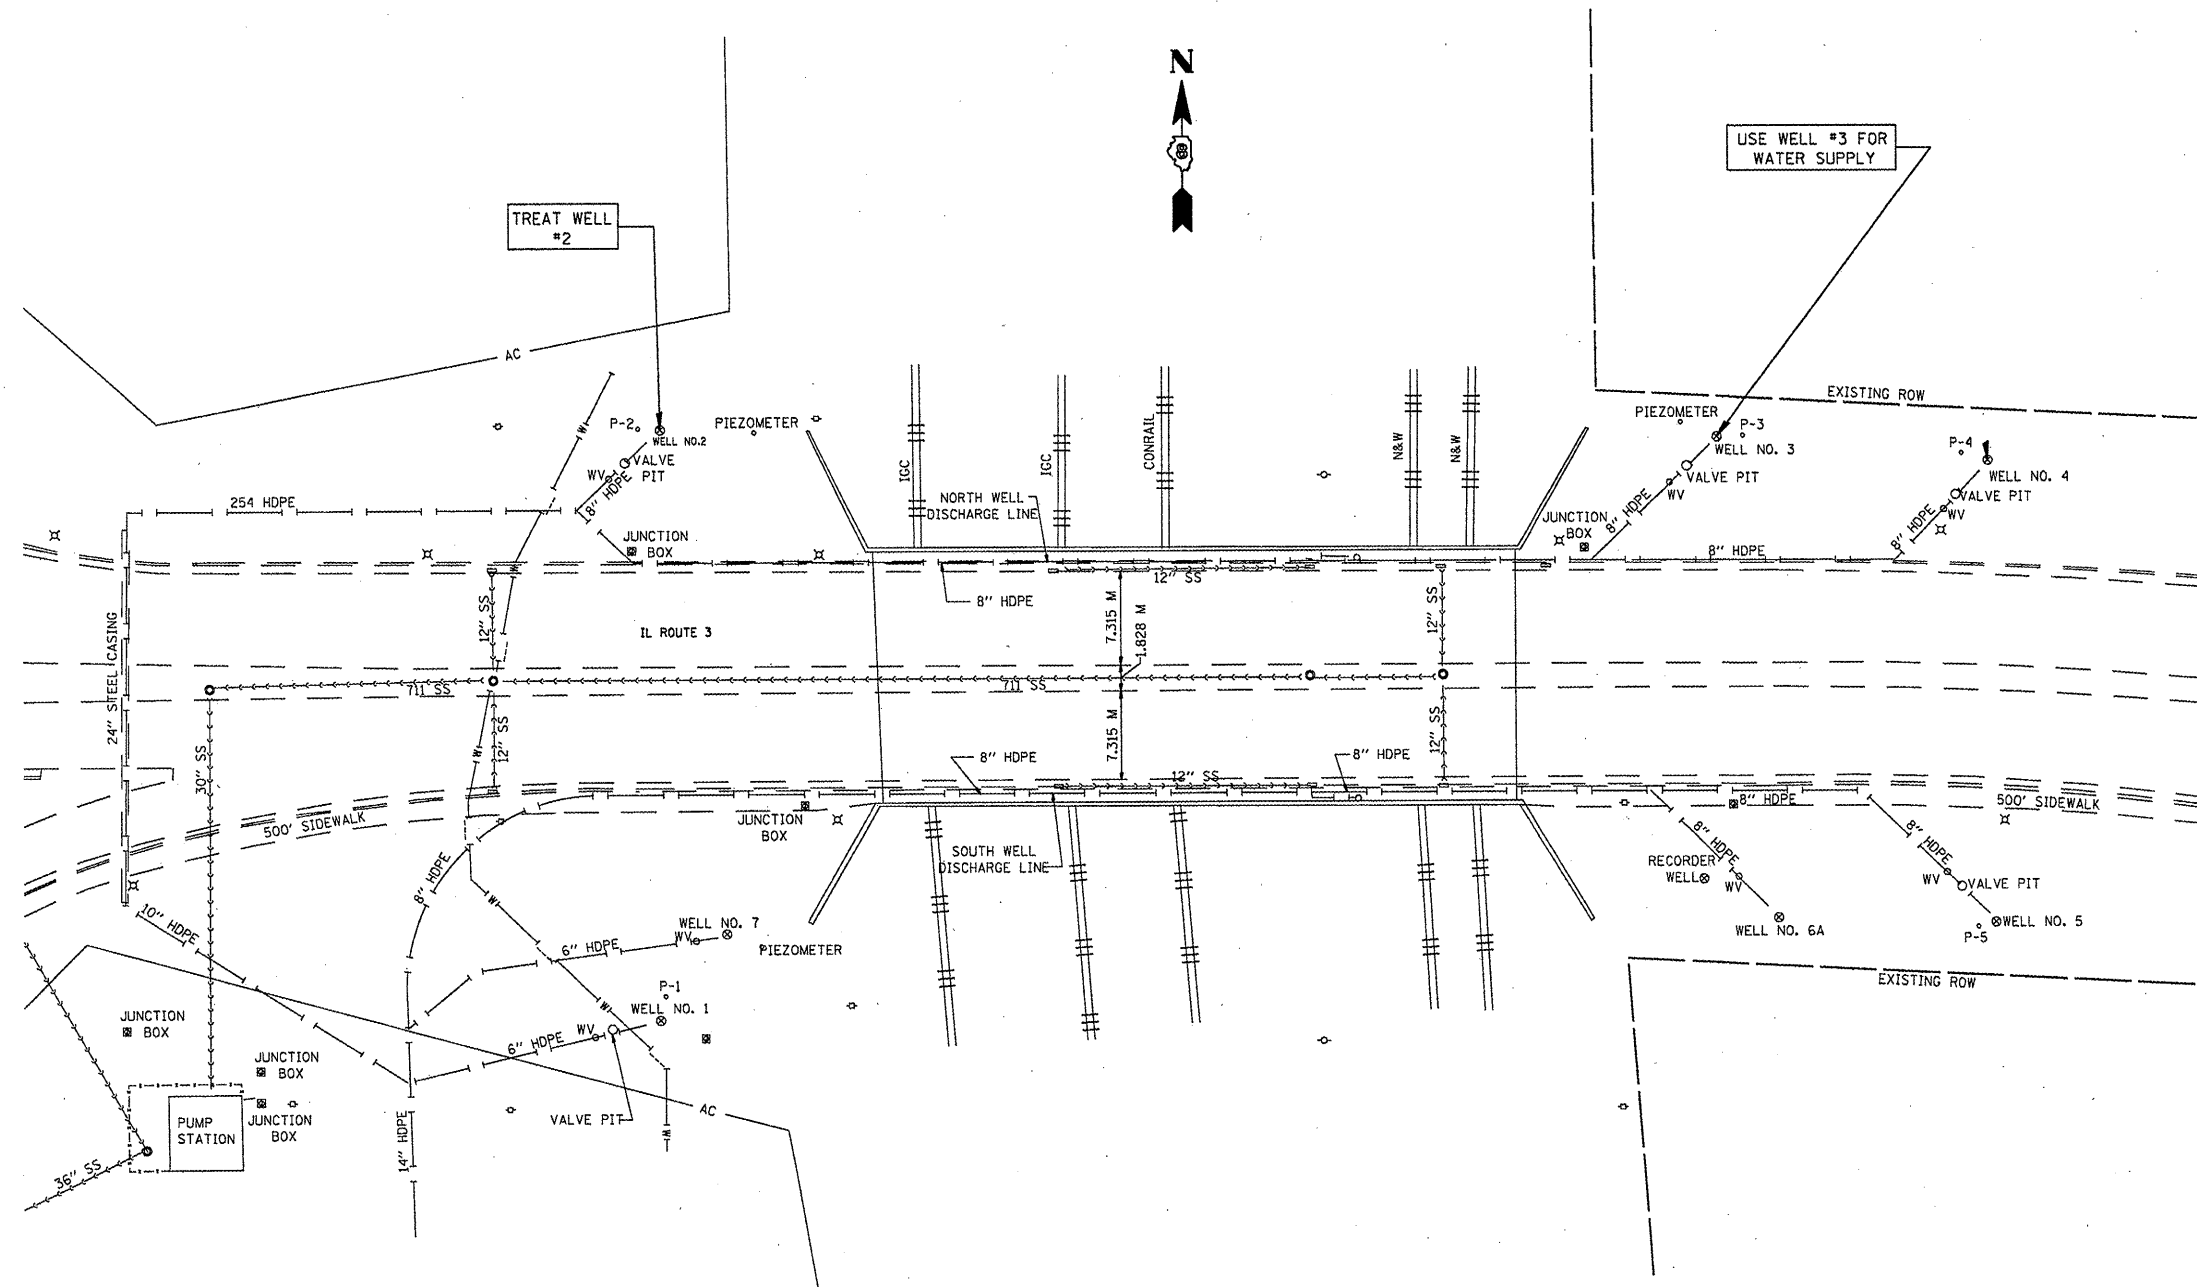

NOTE: HOSE FOR SUPPLY WATER
MAY BE PLACED ON SIDE WALK
WHILE IN USE, BUT MUST BE
REMOVED OVER NIGHT.

LOCATION	ADDITIONAL TREATMENT NO. 1	ADDITIONAL TREATMENT NO. 2	WELL CHEMICAL TREATMENT	WELL CHEMICAL TREATMENT SPECIAL	SONAR JET TREATMENT
WELL #2	X	X	X		

•• DIST 8 DEEP WELLS 2011-1
••• MADISON & ST. CLAIR

FILE NAME =	USER NAME = #USER#	DESIGNED -	REVISED -	STATE OF ILLINOIS DEPARTMENT OF TRANSPORTATION	LOCATION 1 SITE PLAN VENICE WELLS (IL RTE 3)	F.A.P. RTE.	SECTION	COUNTY	TOTAL SHEETS	SHEET NO.	
#FILE#		DRAWN -	REVISED -			VAR		••	•••	9	4
	PLOT SCALE = #SCALE#	CHECKED -	REVISED -								
	PLOT DATE = #DATE#	DATE -	REVISED -								
						SCALE: _____	SHEET NO. _____ OF _____ SHEETS	STA. _____ TO STA. _____	FED. ROAD DIST. NO. _____ ILLINOIS FED. AID PROJECT		

CONTRACT NO. 16E27