
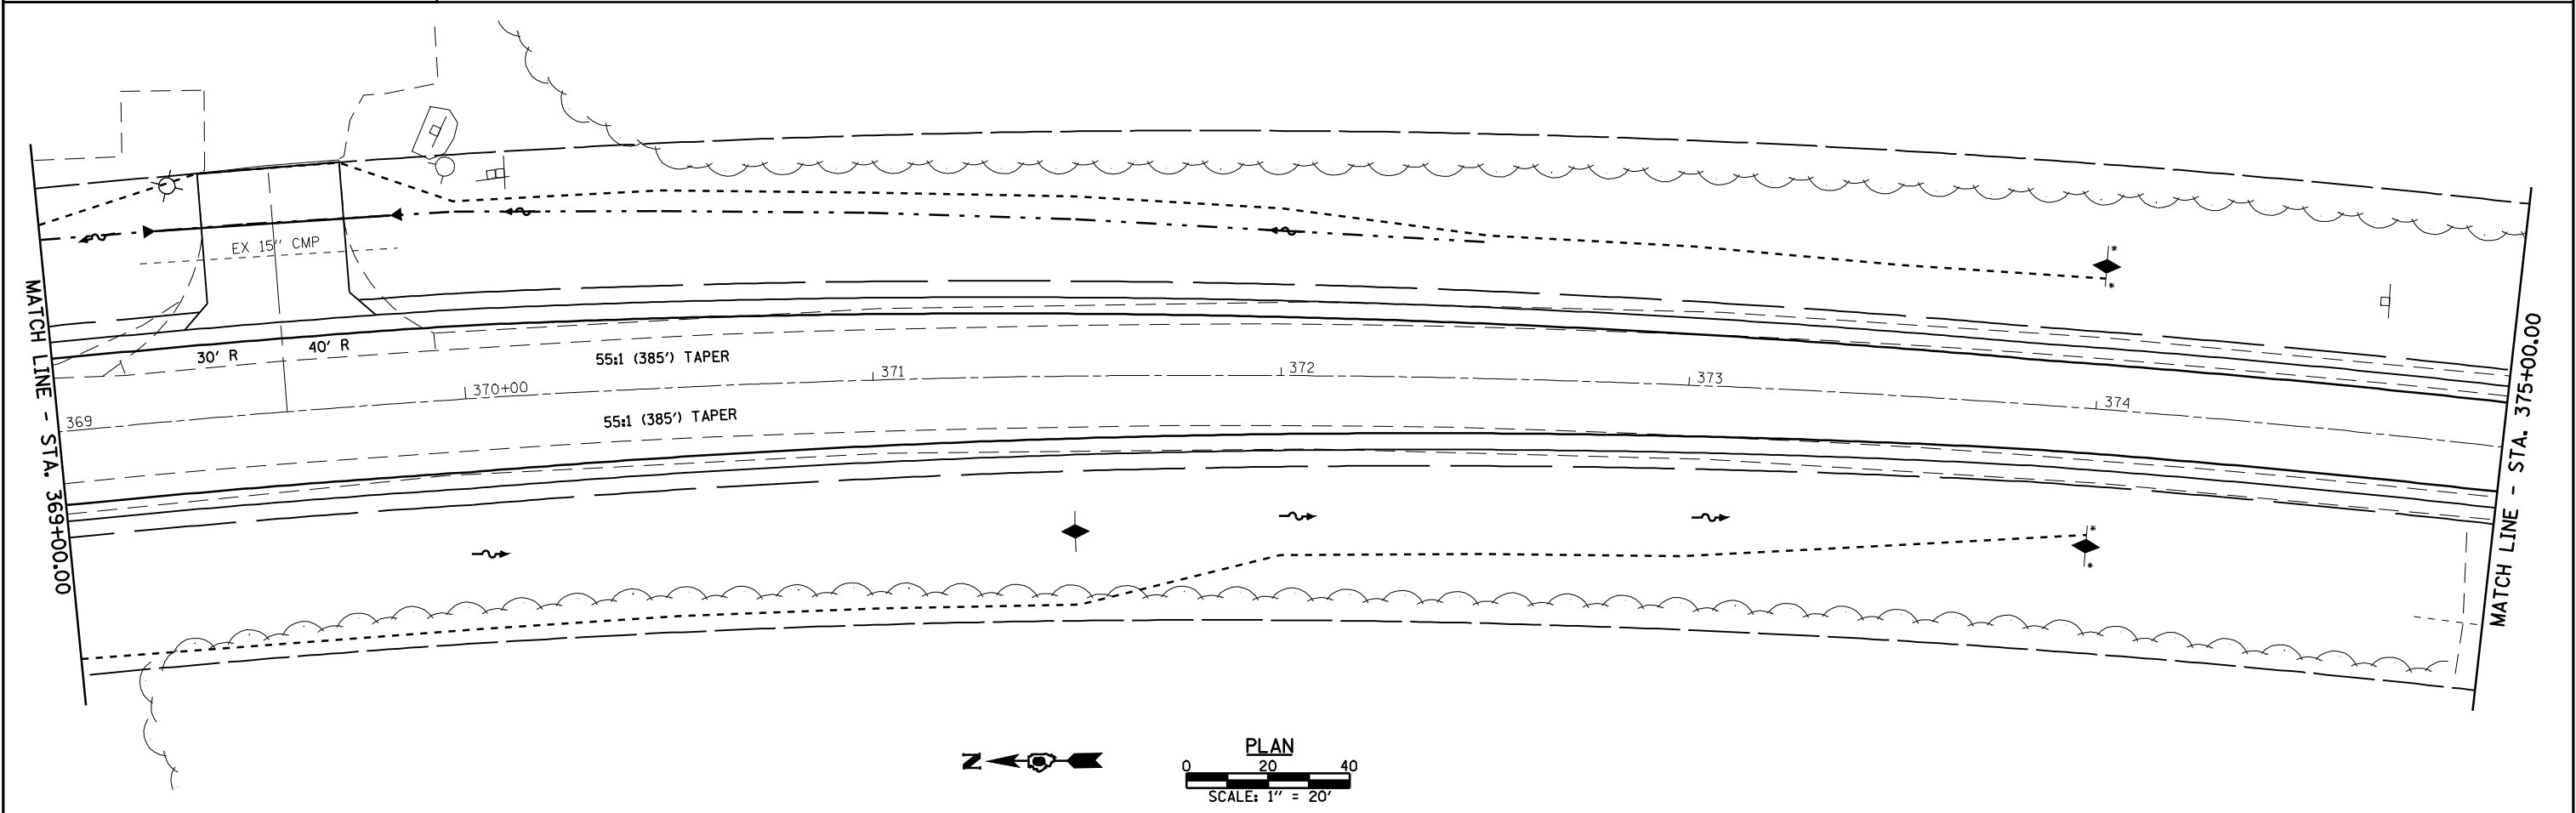


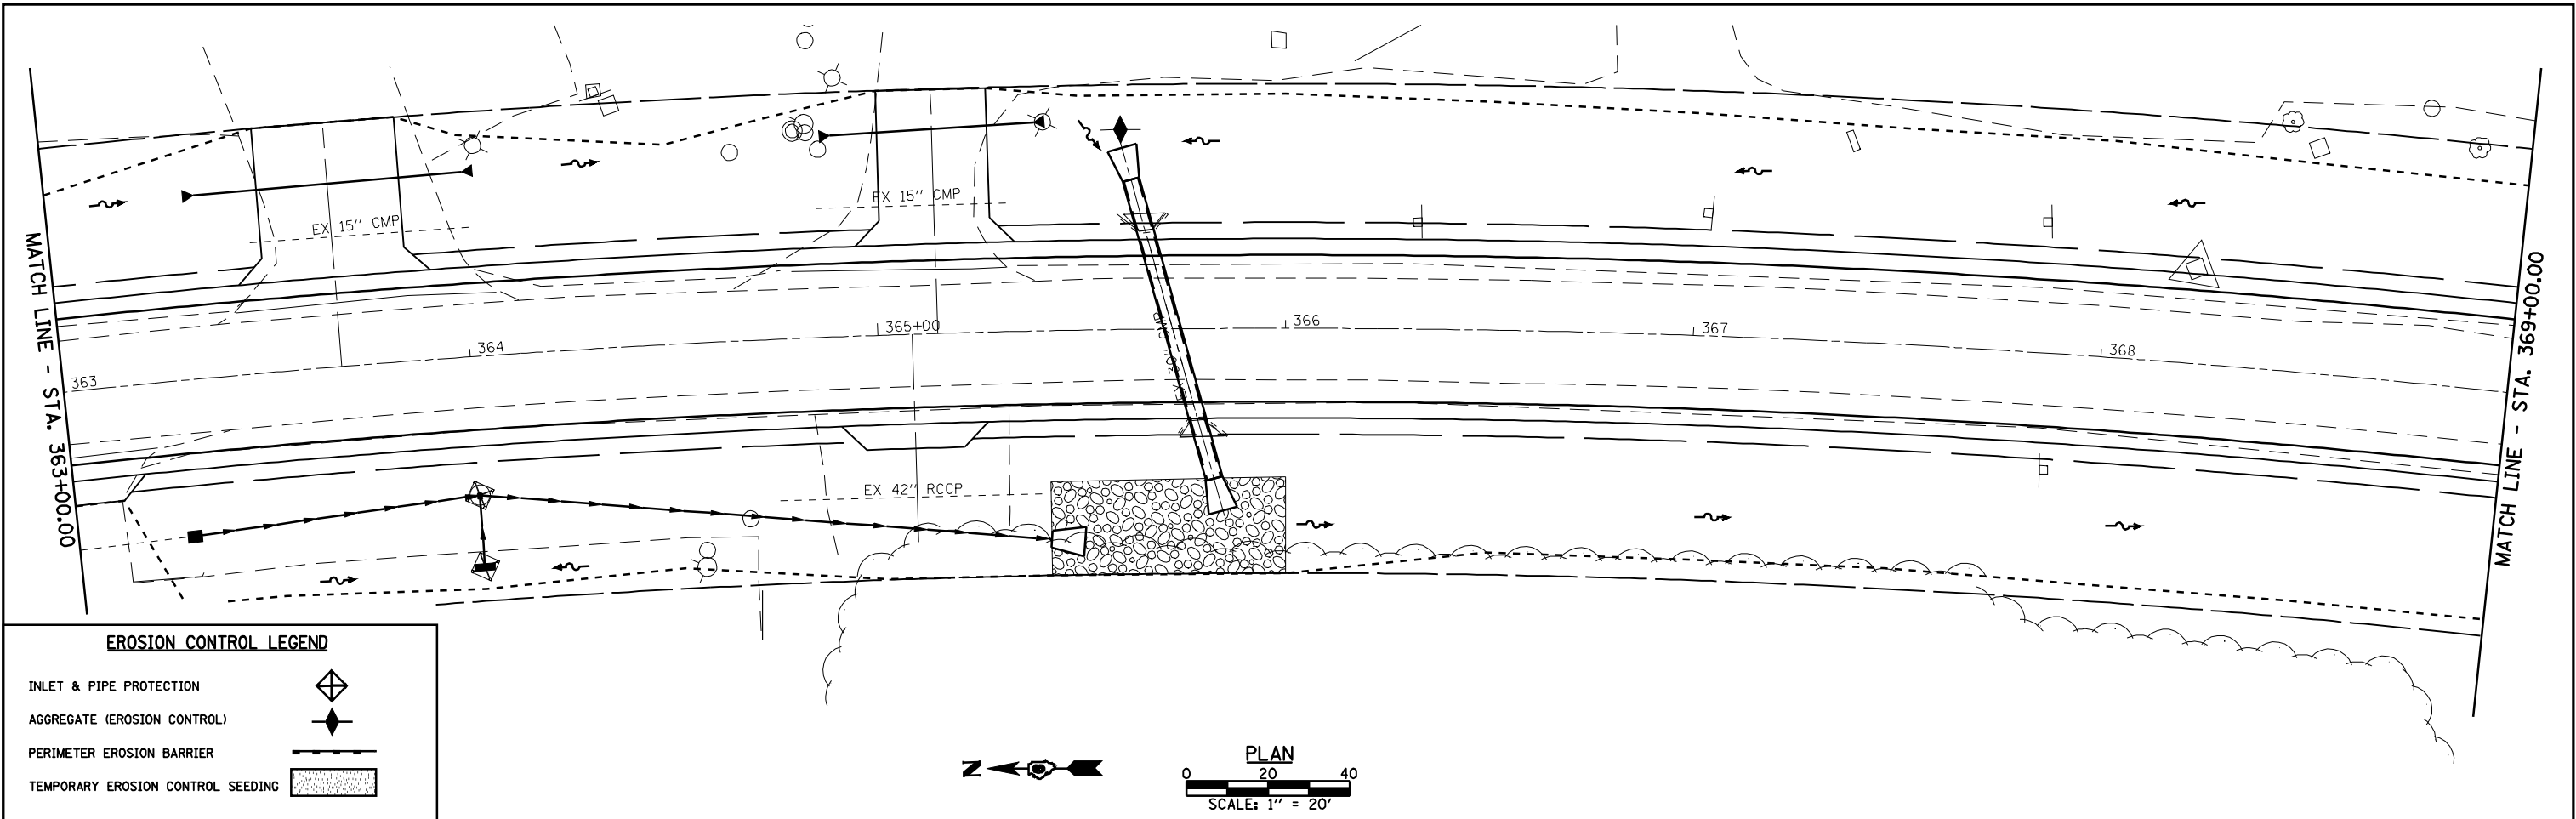

|                                                       |  |                       |            |           |                                                                                       |                                                                                                                                                                 |                             |  |                                               |                 |          |              |           |
|-------------------------------------------------------|--|-----------------------|------------|-----------|---------------------------------------------------------------------------------------|-----------------------------------------------------------------------------------------------------------------------------------------------------------------|-----------------------------|--|-----------------------------------------------|-----------------|----------|--------------|-----------|
| FILE NAME = S:\PROJ ENGR 1 (Negongard)\Dust Squad\FAP |  | USER NAME = madonlavj | DESIGNED - | REVISED - |  | <b>Allen Henderson &amp; Associates, Inc.</b><br>Civil and Structural Engineers Springfield, IL.<br>62703 Phone: (217)544-8033 IL Design Firm<br>No. 184-001907 | <b>EROSION CONTROL PLAN</b> |  | F.A.P. RTE.                                   | SECTION         | COUNTY   | TOTAL SHEETS | SHEET NO. |
| 662 (IL 4) Henderson pdfs\CADD Sheets\06727           |  | DRAWN EROSI.dgn       | CHECKED -  | REVISED - |                                                                                       |                                                                                                                                                                 |                             |  | 662                                           | D(W-3,RS-11,CR) | MACOUPIN | 102          | 54        |
| PLOT SCALE = 40.0000' / IN.                           |  |                       | DATE -     | REVISED - |                                                                                       |                                                                                                                                                                 |                             |  | CONTRACT NO. 72765                            |                 |          |              |           |
| PLOT DATE = Aug-17-2009 04:06:47PM                    |  |                       |            |           |                                                                                       |                                                                                                                                                                 |                             |  | FED. ROAD DIST. NO. ILLINOIS FED. AID PROJECT |                 |          |              |           |

SCALE: 1" = 20'    SHEET NO. 2 OF 4 SHEETS    STA. 363+00.00 TO STA. 375+00.00