


SIGN DETAIL  
1:75

WB-TR-73  
STA. 582+85

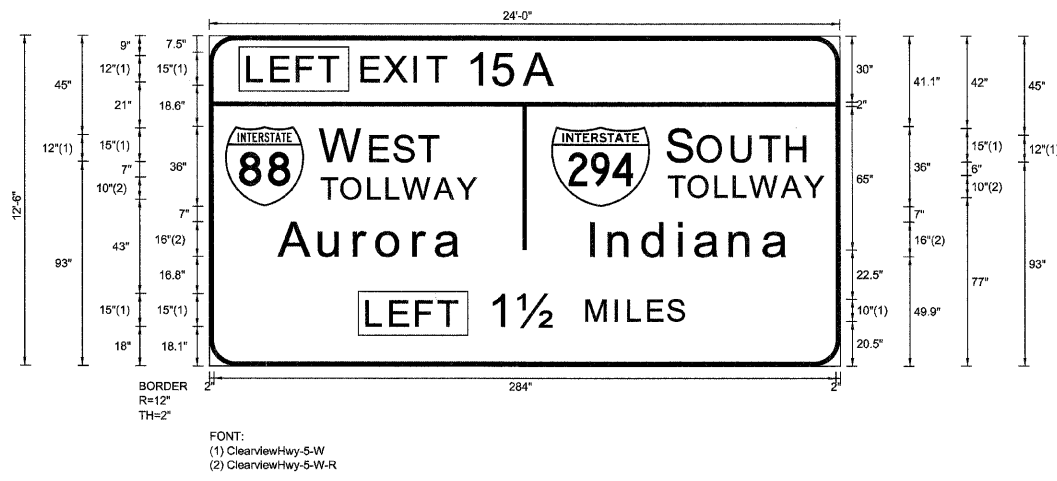

Panel Style: sign\_default.ssi  
Dimensions are in inches.tenths

Letter locations are panel edge to lower left corner

SIGN NUMBER	name	
WIDTH x HGT.	24'-0" x 12'-6"	
BORDER WIDTH	2"	
CORNER RADIUS	12"	
MOUNTING	Overhead	
BACKGROUND	TYPE:	Reflective
	COLOR:	Green
LEGEND/BORDER	TYPE:	Reflective
	COLOR:	White/White

SYMBOL	ROT	X	Y	WID	HT
M1_1	0	7.2	72.9	36	36
M1_1	0	156.2	72.9	45	36

LETTER POSITIONS (X)

										LENGTH	SERIES/SIZE
L	E	F	T								Clearview/Hwy-5-W
18	28.8	40.5	50.6							41.2	12
E	X	I	T	1	5	A					Clearview/Hwy-5-W
70.1	80.4	94.1	100	118.6	130.6	144.7				88.6	12,15
W	E	S	T								Clearview/Hwy-5-W
51.2	74.1	84.9	96.3							53.7	15,12
S	O	U	T	H							Clearview/Hwy-5-W
209.9	223.8	239.2	252.1	264.3						63.6	15,12
T	O	L	L	W	A	Y					Clearview/Hwy-5-W-R
51.2	60.4	72.7	81.1	88.6	103.1	113.4				70.9	10
T	O	L	L	W	A	Y					Clearview/Hwy-5-W-R
209.9	219	231.3	239.7	247.2	261.7	272				70.9	10
A	u	r	o	r	a						Clearview/Hwy-5-W-R
32.1	50.6	66.6	77	93.7	103.8					83.5	1613
I	n	d	i	a	n	a					Clearview/Hwy-5-W-R
174.5	182.9	198.4	214.7	222.2	238.2	253.4				90.8	1613
L	E	F	T								Clearview/Hwy-5-W
72.3	83.2	94.9	104.9							41.2	12
1	1/2	M	I	L	E	S					Clearview/Hwy-5-W
128.6	141.3	172.7	185.8	191.7	200.7	209.7				88.4	15,10

FILE NAME =	DESIGNED - SEW	REVISED -
#FILEL#	DRAWN - SEW	REVISED -
USER NAME = #USER#	CHECKED - FML	REVISED -
PLOT DATE = #DATE#	DATE - 12/2009	REVISED -



STATE OF ILLINOIS  
DEPARTMENT OF TRANSPORTATION

SIGNING DETAILS

SCALE: N.T.S. SHEET NO. 47 OF 77 SHEETS STA. TO STA.

F.A.I. RTE.	SECTION	COUNTY	TOTAL SHEETS	SHEET NO.
290	(3031.1, ETC., 3838RS-5	COOK	413	375
FED. ROAD DIST. NO.			ILLINOIS FED. AID PROJECT	
CONTRACT NO. 60G52				