


F.A.U. RTE.	SECTION	COUNTY	TOTAL SHEETS	SHEET NO.
1338	05-00083-00-FF	COOK	167	109
LIGHTING PLAN - STA. 40+50 TO STA. 50+50				
FED. ROAD DIST. NO. 7 ILLINOIS FED. AID PROJECT M-8003(512)				

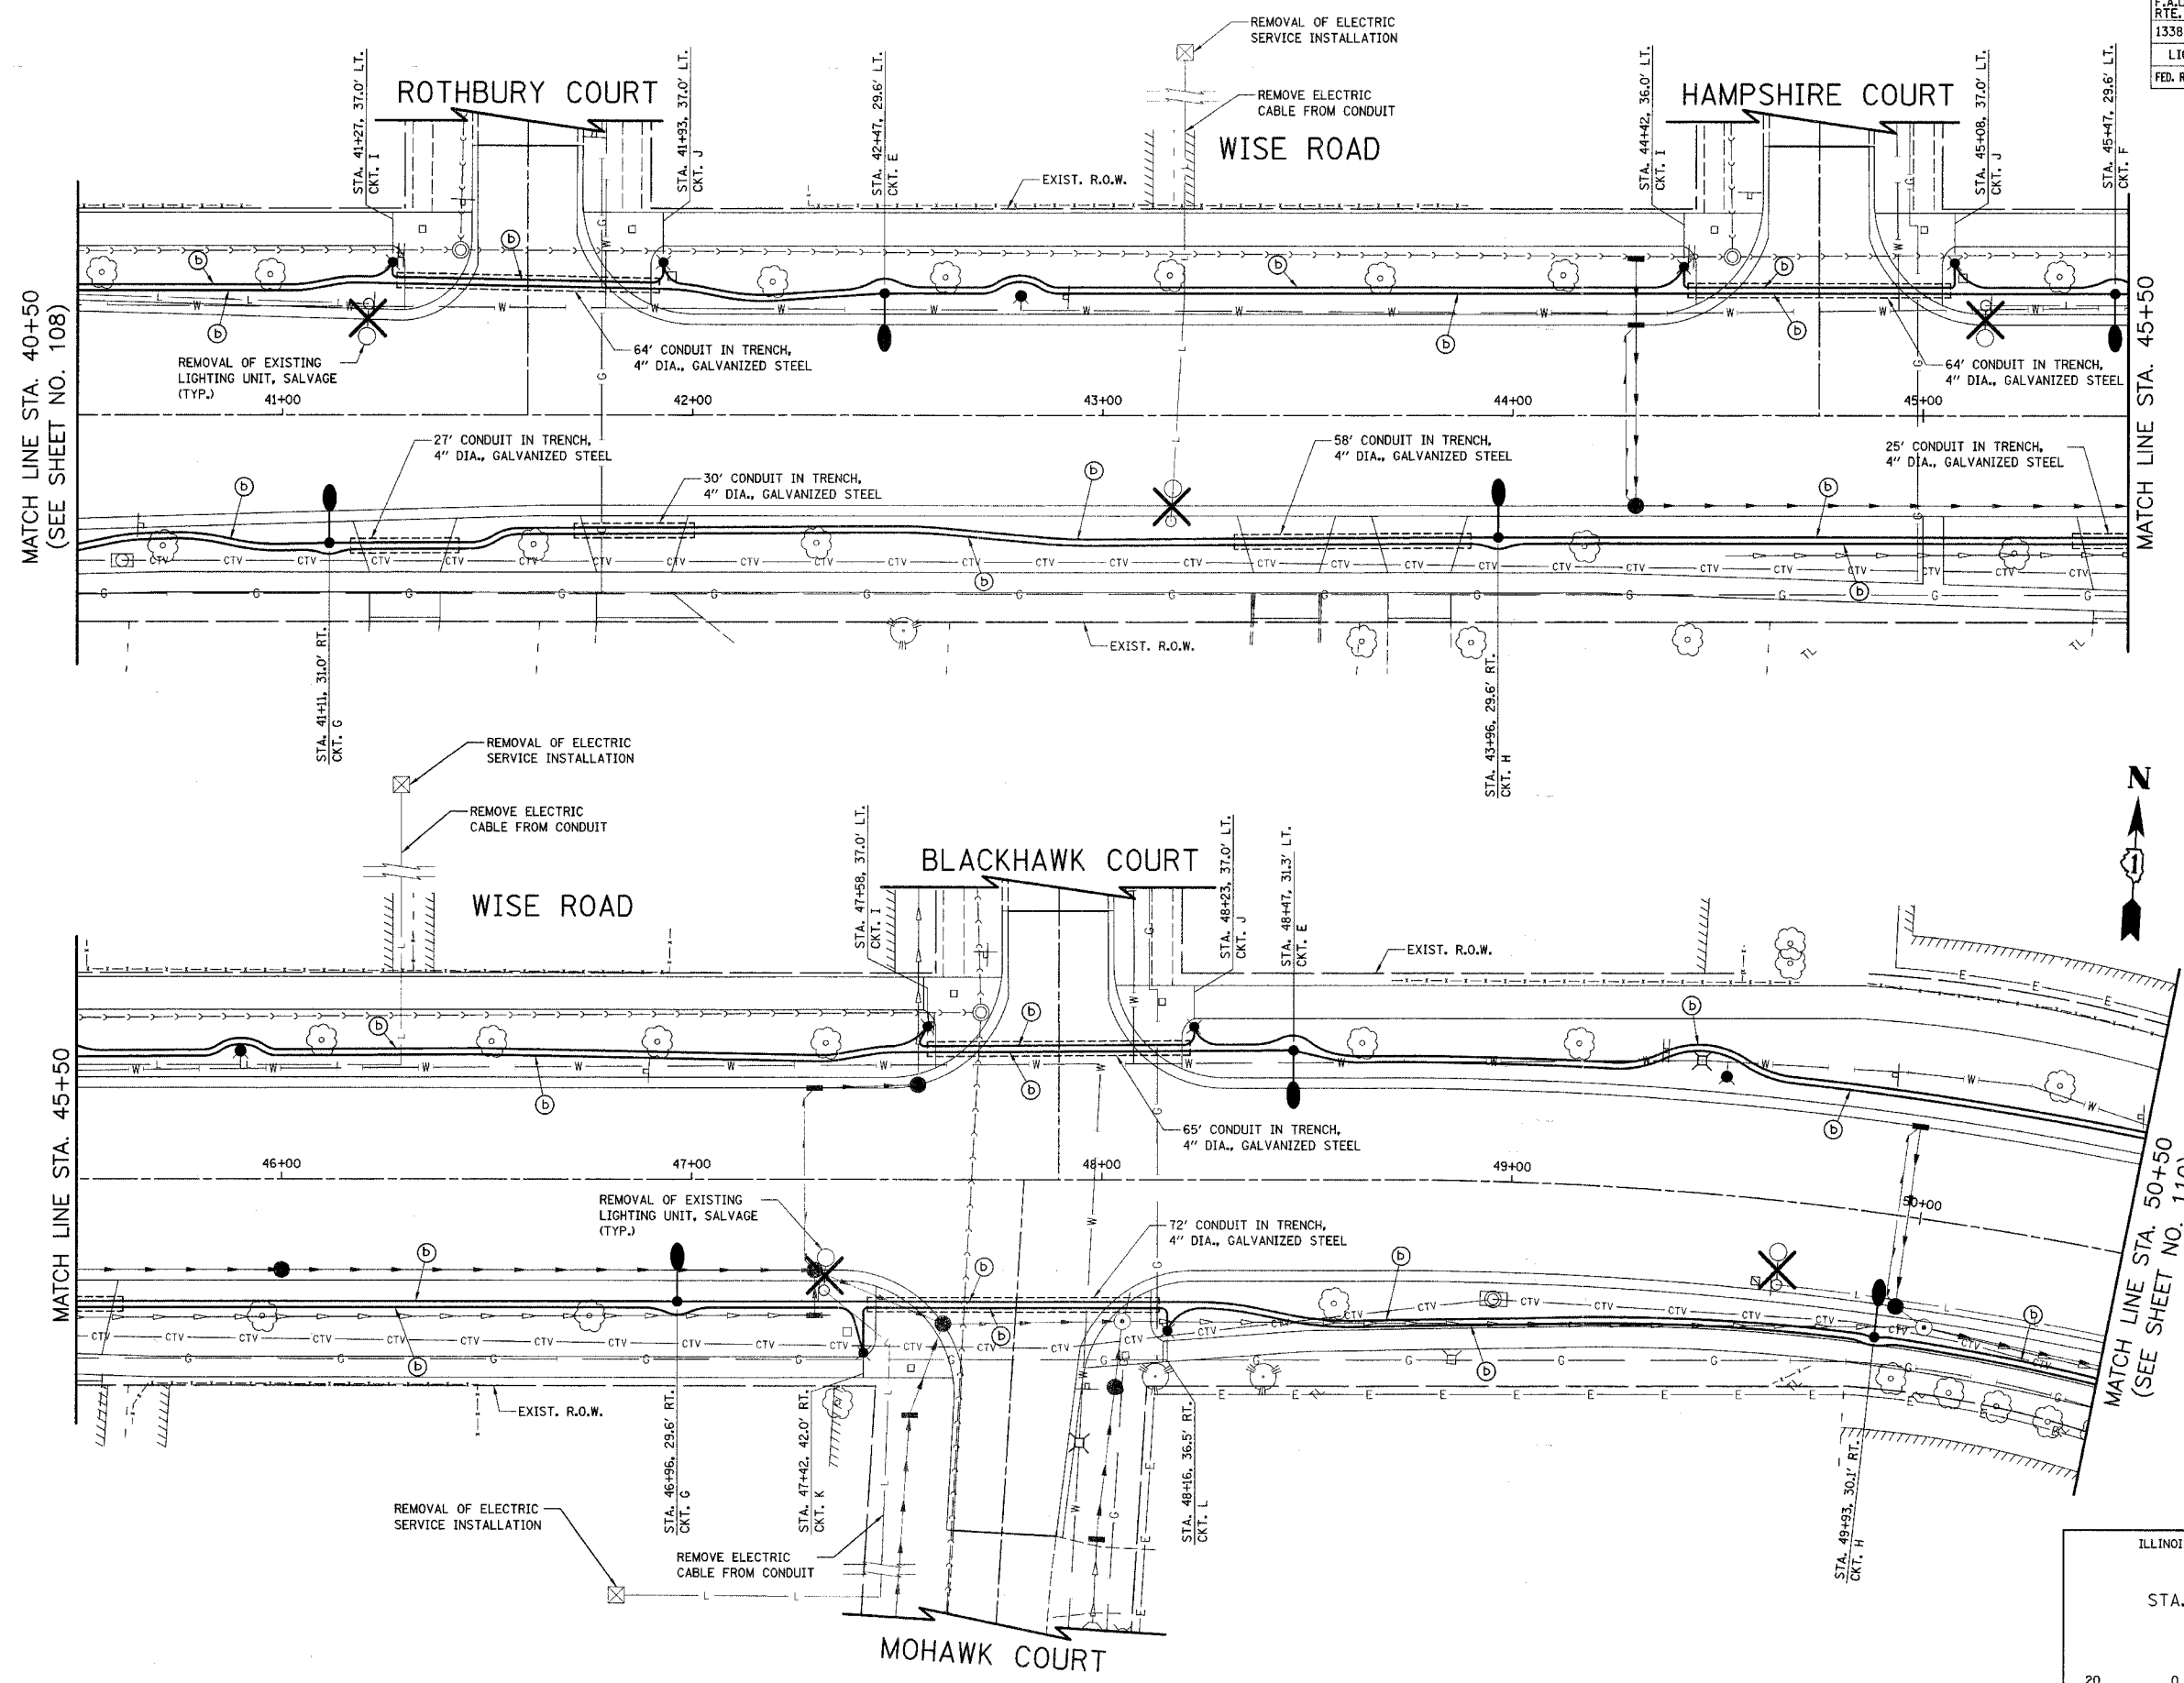

MATCH LINE STA. 40+50
(SEE SHEET NO. 108)

MATCH LINE STA. 45+50

MATCH LINE STA. 45+50

MATCH LINE STA. 50+50
(SEE SHEET NO. 110)

ILLINOIS DEPARTMENT OF TRANSPORTATION
LIGHTING PLAN
 STA. 40+50 TO STA. 50+50
 WISE ROAD

SCALE IN FEET

DATE: 9/28/07
 DESIGNED BY: SJC
 CHECKED BY: DNM