

STORM SEWER REMOVAL - 8"
STA. 72+02.85 TO STA. 71+99.44 - 65.2 FT

STORM SEWER REMOVAL - 10"
STA. 72+96.42 TO STA. 75+46.99 - 254.5 FT
STA. 75+46.99 TO STA. 75+45.99 - 24.9 FT
STA. 77+98.46 TO STA. 77+86.82 - 82.8 FT

STORM SEWER REMOVAL - 12"
STA. 70+00.12 TO STA. 70+00.00 - 65.1 FT
STA. 70+14.89 TO STA. 70+12.09 - 6.1 FT
STA. 71+99.44 TO STA. 71+98.96 - 81.9 FT
STA. 78+01.13 TO STA. 78+27.17 - 30.5 FT

STORM SEWER REMOVAL - 15"
STA. 70+00.00 TO STA. 70+10.45 - 68.2 FT
STA. 70+10.45 TO STA. 70+12.15 - 12.8 FT

STORM SEWER REMOVAL - 18"
STA. 75+43.12 TO STA. 75+45.99 - 69.6 FT
STA. 81+20.17 TO STA. 81+45.19 - 158.6 FT

STORM SEWER REMOVAL - 24"
STA. 68+00.00 TO STA. 70+12.15 - 217.2 FT
STA. 70+12.15 TO STA. 72+11.50 - 204.3 FT
STA. 72+11.50 TO STA. 75+45.77 - 342.4 FT
STA. 75+45.77 TO STA. 77+94.38 - 248.6 FT
STA. 77+94.38 TO STA. 78+53.91 - 59.5 FT
STA. 78+53.91 TO STA. 81+43.08 - 289.2 FT
STA. 81+43.08 TO STA. 82+00.00 - 56.9 FT

REMOVAL LEGEND



- | | |
|--------------------------|-------------------------|
| PAVEMENT REMOVAL | CONCRETE MEDIAN REMOVAL |
| SHOULDER REMOVAL | PAVED DITCH REMOVAL |
| HMA SURFACE REMOVAL, 4" | STORM SEWER REMOVAL |
| DRAINAGE STR. ADJUSTMENT | LINEAR ITEM REMOVAL |
| DRAINAGE STR. REMOVAL | ITEM REMOVAL |

REMOVING INLETS
STA. 72+02.85, 65.41' LT

REMOVING CATCH BASINS
STA. 70+00.12, 65.25' LT
STA. 70+14.84, 73.81' RT
STA. 77+98.46, 0.00' LT
STA. 78+01.13, 66.23' RT

REMOVING FLARED END SECTIONS - 18"
STA. 75+43.12, 152.50' RT

REMOVING MANHOLES
STA. 70+00.00, 0.20' LT
STA. 70+12.15, 79.42' RT
STA. 71+99.44, 0.37' LT
STA. 72+11.50, 81.50' RT
STA. 72+96.42, 47.57' RT
STA. 75+46.99, 58.02' RT
STA. 75+45.77, 82.91' RT
STA. 77+94.38, 81.76' RT
STA. 78+53.91, 82.46' RT
STA. 81+43.08, 80.94' RT

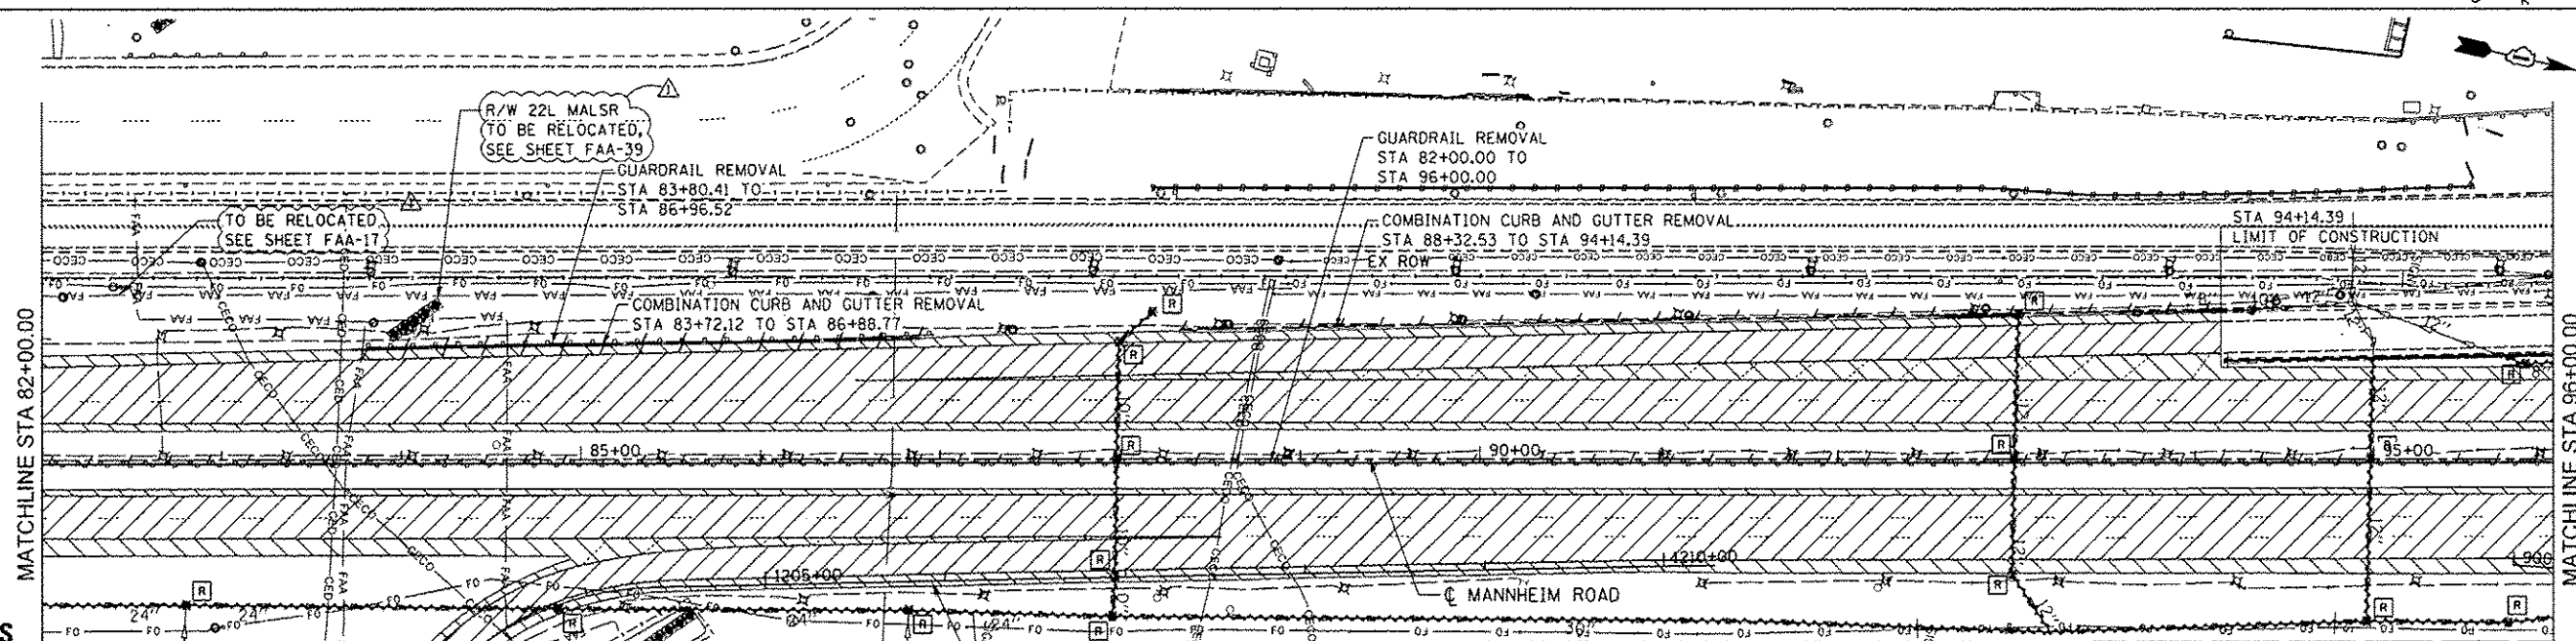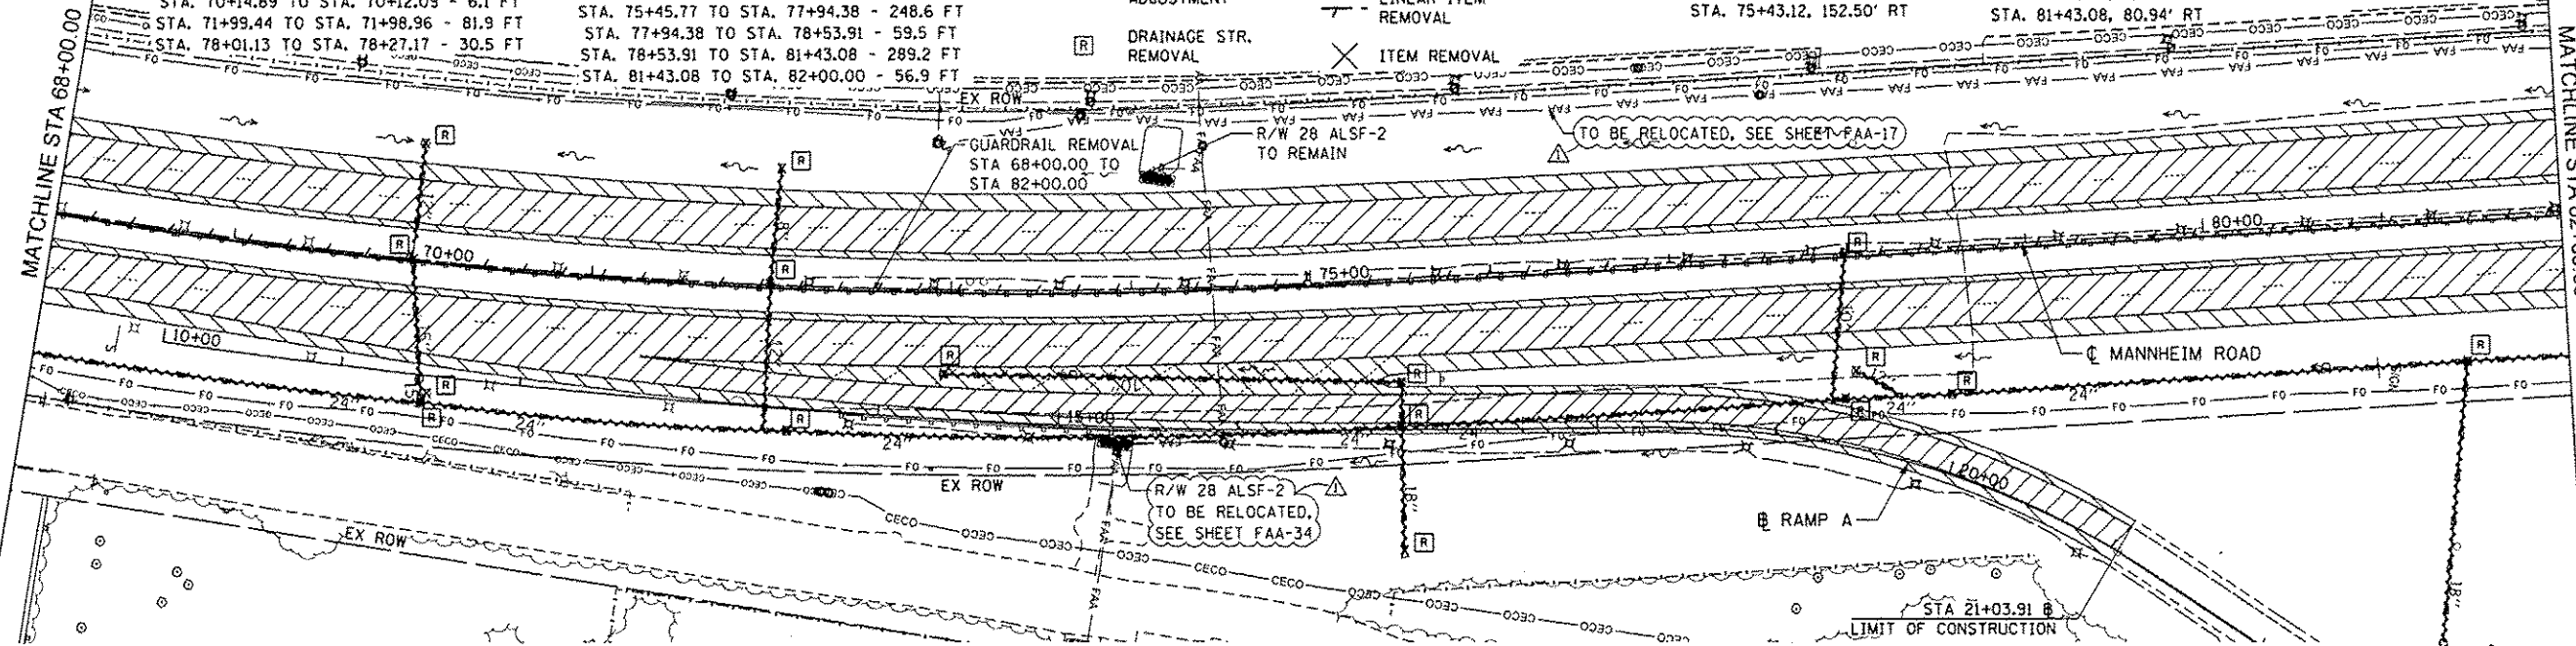

NOTES

- SEE PAVEMENT MARKING AND SIGNING PLANS, LIGHTING PLANS, LANDSCAPING PLANS, AND TRAFFIC SIGNAL PLANS FOR ADDITIONAL REMOVALS NOT SHOWN ON THIS SHEET.
- REMOVAL AND DISPOSAL OF EXISTING SHOULDER STABILIZATION UNDER EXISTING GUARDRAIL SHALL NOT BE MEASURED FOR PAYMENT BUT SHALL BE INCLUDED IN THE COST OF SHOULDER REMOVAL.
- REMOVAL AND DISPOSAL OF EXISTING BURIED MOUNTABLE CURB SHALL NOT BE MEASURED FOR PAYMENT BUT SHALL BE INCLUDED IN THE COST OF SHOULDER REMOVAL.

STORM SEWER REMOVAL - 12"
STA. 93+01.00 TO STA. 92+98.59 - 80.5 FT
STA. 92+98.59 TO STA. 92+97.39 - 64.9 FT
STA. 92+97.39 TO STA. 93+18.78 - 38.3 FT
STA. 95+84.53 TO STA. 95+73.9 - 12 FT
STA. 94+99.49 TO STA. 94+97.91 - 54 FT
STA. 94+97.91 TO STA. 94+95.67 - 90.9 FT

STORM SEWER REMOVAL - 10"
STA. 88+17.60 TO STA. 87+98.87 - 25.2 FT
STA. 87+98.87 TO STA. 87+97.61 - 65.1 FT
STA. 87+97.61 TO STA. 87+96.69 - 66.4 FT
STA. 87+96.69 TO STA. 87+95.22 - 22.6 FT

STORM SEWER REMOVAL - 24"
STA. 82+00.00 TO STA. 82+80.00 - 80.0 FT
STA. 82+80.00 TO STA. 84+87.42 - 207.4 FT
STA. 84+87.42 TO STA. 86+82.36 - 195.0 FT
STA. 86+82.36 TO STA. 87+95.22 - 112.9 FT

STORM SEWER REMOVAL - 30"
STA. 87+95.22 TO STA. 94+95.67 - 700.6 FT
STA. 94+95.67 TO STA. 95+74.63 - 79.0 FT

REMOVING MANHOLES
STA. 82+80.00, 81.08' RT
STA. 84+87.42, 83.42' RT
STA. 86+82.36, 84.61' RT
STA. 88+17.60, 82.00' LT
STA. 87+98.87, 65.13' LT
STA. 87+97.61, 0.00' LT
STA. 87+96.69, 66.33' RT
STA. 87+95.22, 88.07' RT

REMOVING MANHOLES
STA. 93+01.00, 80.70' LT
STA. 92+98.59, 0.25' LT
STA. 92+97.39, 64.59' RT
STA. 95+84.53, 52.77' LT
STA. 94+97.91, 0.30' LT
STA. 94+95.67, 90.57' RT
STA. 95+74.63, 91.28' RT

HNTB

USER NAME = mhk
DESIGNED LLS/MMK
DRAWN MMK
CHECKED LLS
PLOT SCALE = 50:1
PLOT DATE = 27-DEC-2012

DATE
REVISED

REVISED
REVISED
REVISED
REVISED 12/28/12 ADDENDUM 1

STATE OF ILLINOIS
DEPARTMENT OF TRANSPORTATION

REMOVAL PLAN
MANNHEIM ROAD

SCALE: 1" = 50' SHEET NO. 3 OF 6 SHEETS STA. 68+00.00 TO STA. 96+00.00

F.A.P. RTE.	SECTION	COUNTY	TOTAL SHEETS	SHEET NO.
330	0105 WRS&H	COOK	605	60
CONTRACT NO. 60637				
ILLINOIS FED. AID PROJECT				

REM-03