


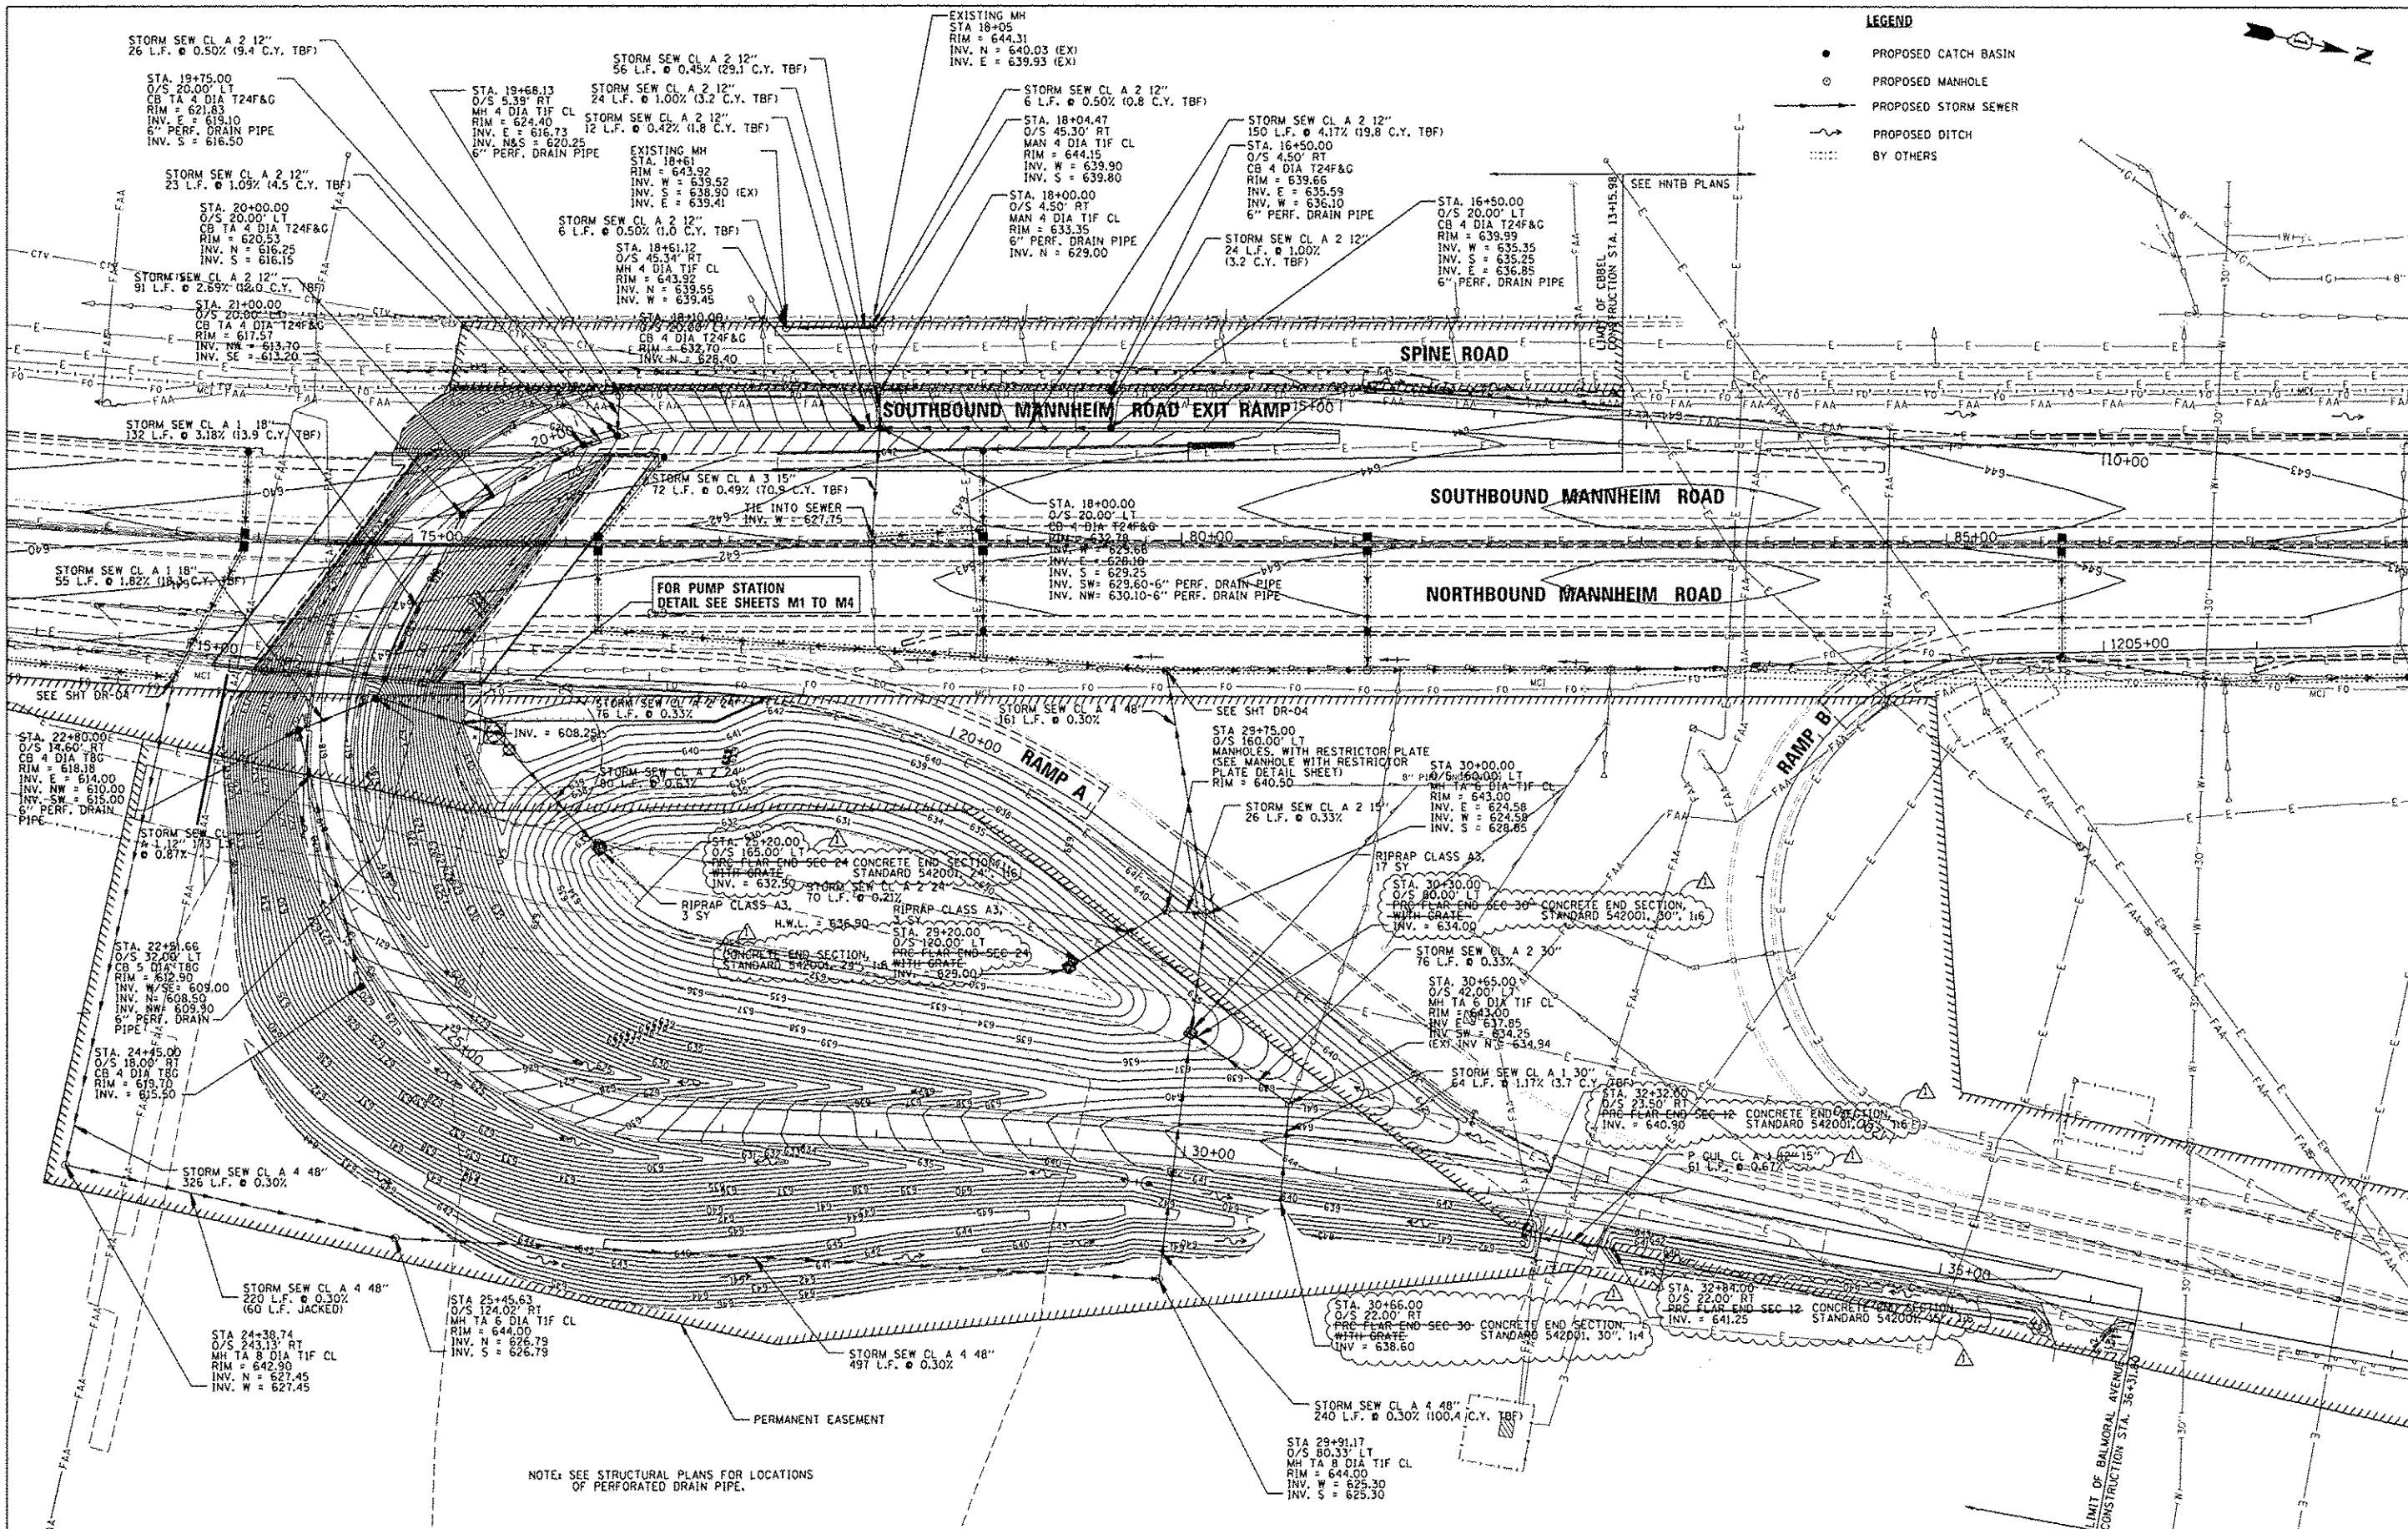

	CHRISTOPHER B. BURKE ENGINEERS, LTD. 1015 W. Higgins Road, Suite 100 Rosemont, Illinois 60018 (708) 947-0001	USER NAME: cgoldenberg	DESIGNED: NJM	REVISED: -	STATE OF ILLINOIS DEPARTMENT OF TRANSPORTATION	PROPOSED DRAINAGE PLAN BALMORAL UNDERPASS	F.A. RTE. 330	SECTION 0105 WRS&HB	COUNTY COOK	TOTAL SHEETS 605	SHEET NO. 186	CONTRACT NO. 60G37
			DRAWN: PWN	REVISED: -								
		PLOT SCALE: 1"=50'	CHECKED: SNS	REVISED: -								
		PLOT DATE: 12/21/2012	DATE: 12/21/2012	REVISED: 12/21/12 ADDENDUM 1								
		SCALE: SHEET NO. OF SHEETS STA. TO STA.			ILLINOIS FED. AID PROJECT							

FILE NAME: N:\AROSEMONT\11209\CA00_Sheets\11209\CA00-37-Sub-drain-01-01.dwg