
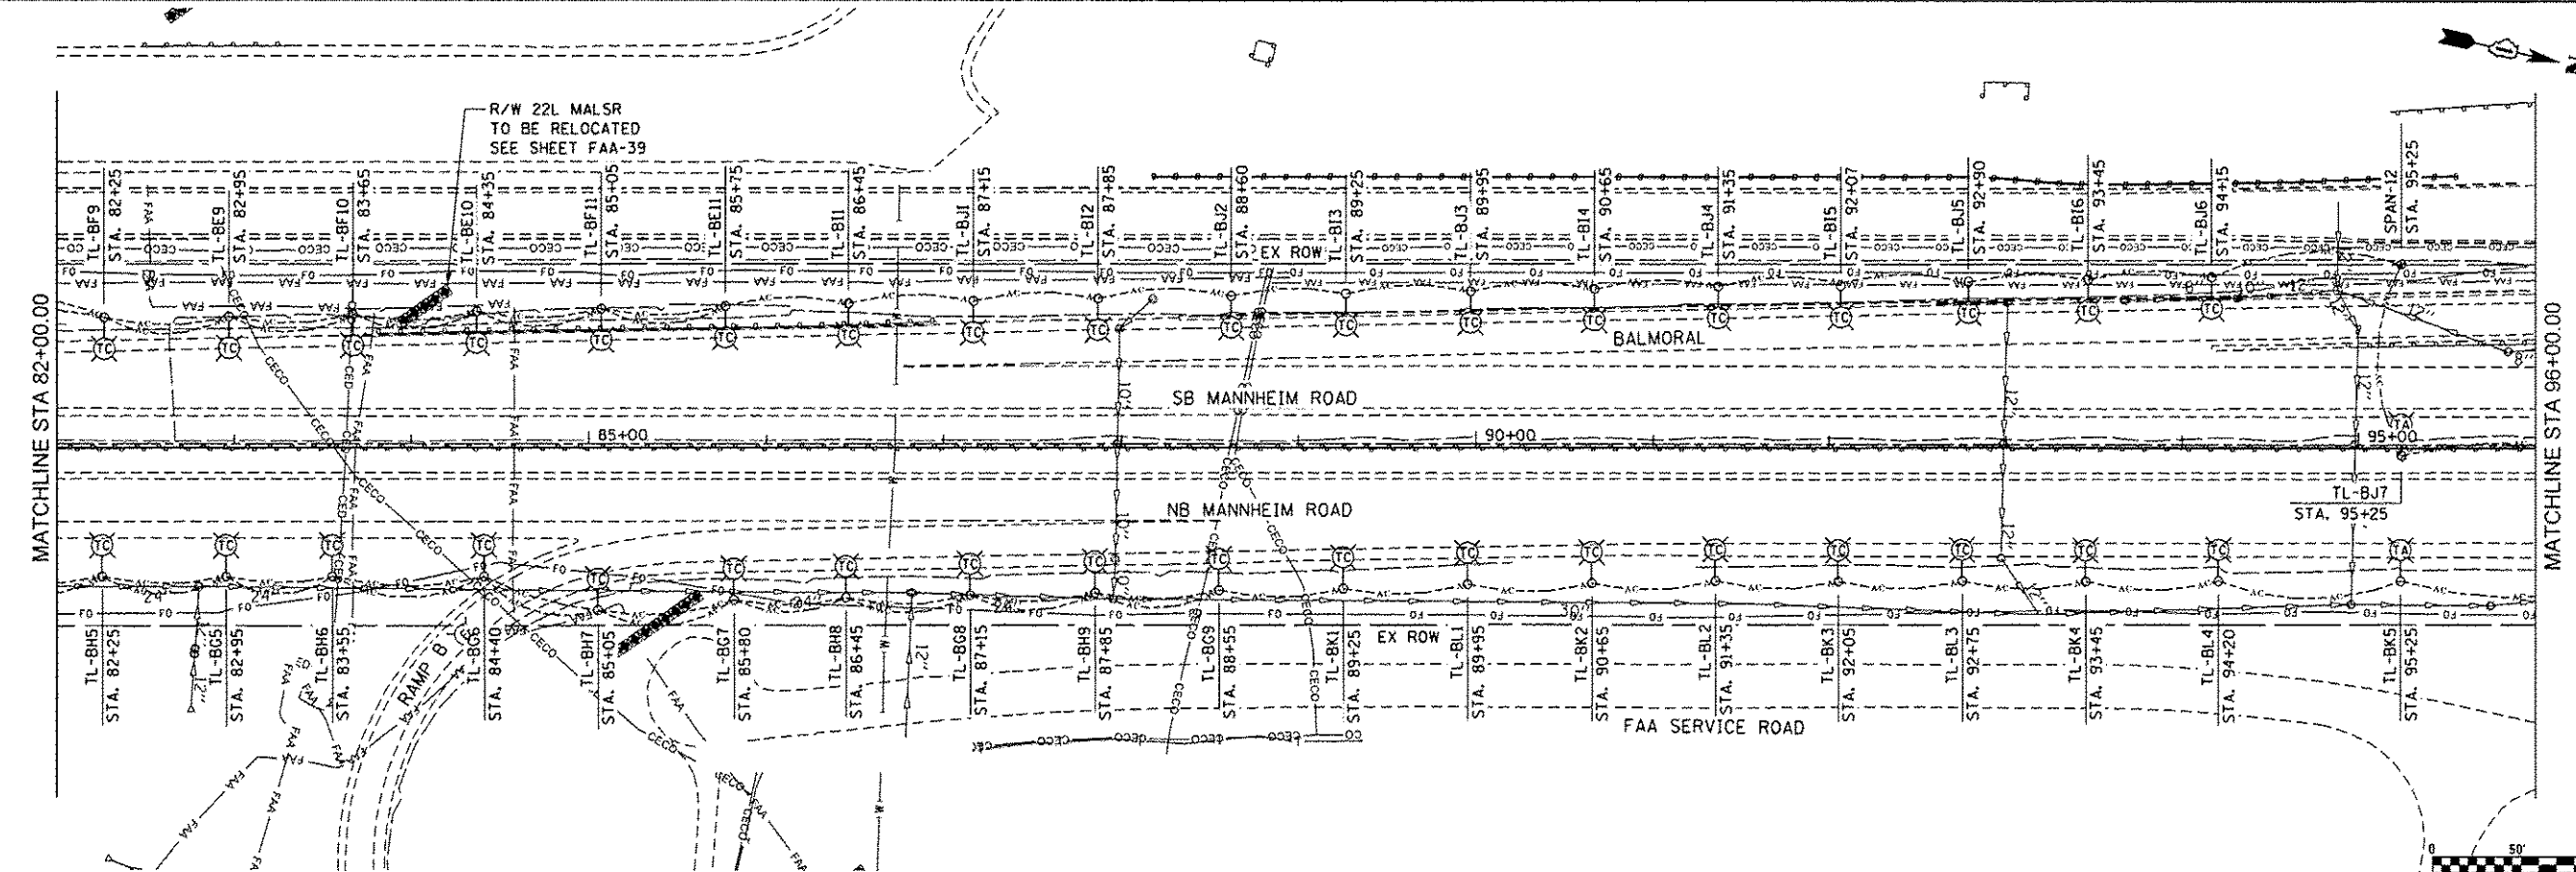


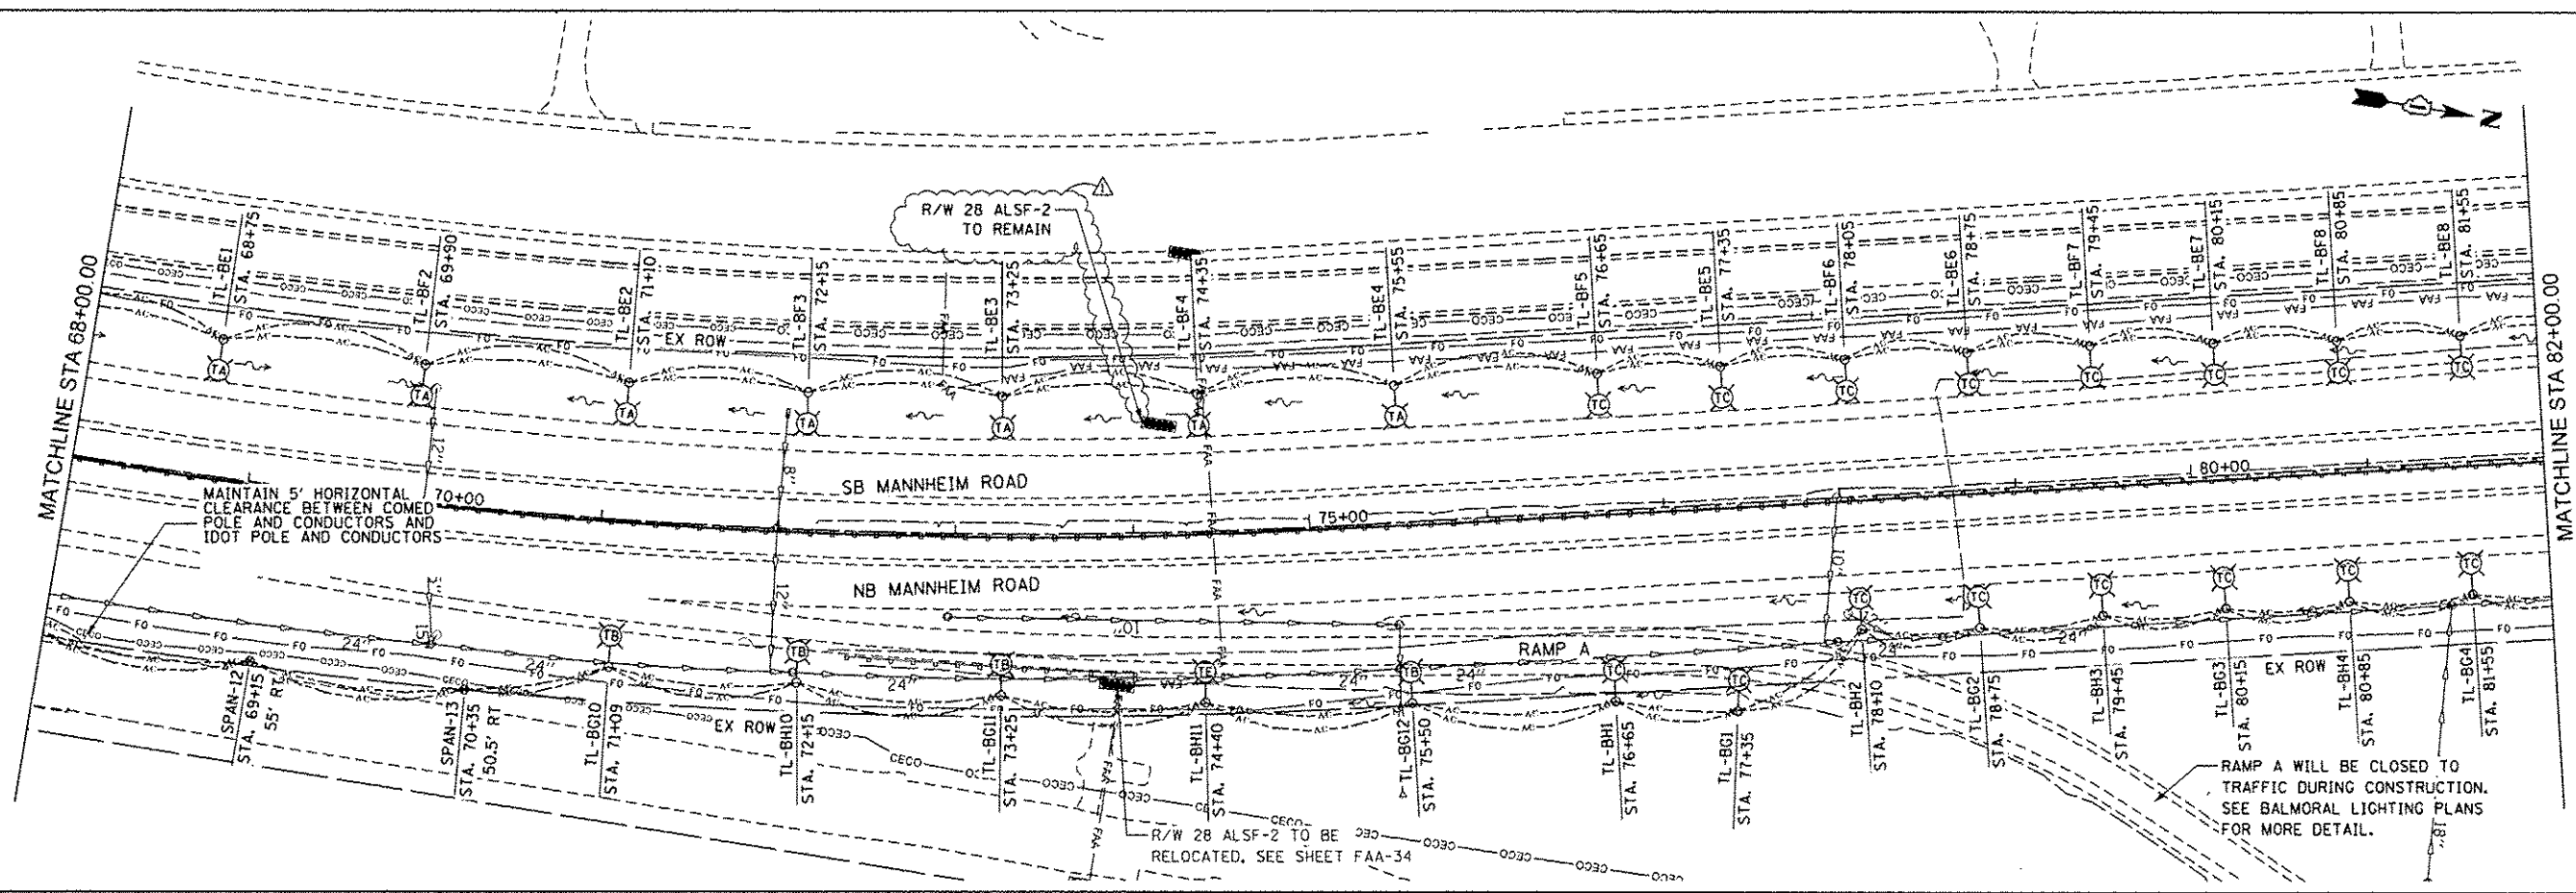

HNTB FILE NAME = IP:\P\dm47844\0160637-ht-templgt-prestage-B3.dgn	USER NAME = mhoss	DESIGNED KA	REVISED -	STATE OF ILLINOIS DEPARTMENT OF TRANSPORTATION	TEMPORARY LIGHTING PLAN PRESTAGE MANNHEIM ROAD	F.A.P. RTE.	SECTION	COUNTY	TOTAL SHEET NO.
	PLOT SCALE = 50:1	DRAWN MMK	REVISED -			330	0105 WRS&HB	COOK	605 304
	PLOT DATE = 27-DEC-2012	CHECKED MCD	REVISED -			CONTRACT NO. 60637			
		DATE	REVISED 12/28/12 ADDENDUM 1			ILLINOIS FED. AID PROJECT			
						SCALE: 1" = 50' SHEET NO. 3 OF 5 SHEETS STA. 68+00.00 TO STA. 96+00.00			