
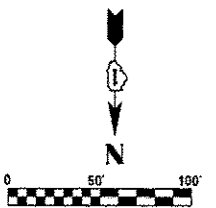


PLAN	DATE
REVISED	BY
NOTED	DATE
NOTE BOOK	NO.
ADD FILE NAME	

MATCH LINE - STA. 58 + 50.0 SEE SHEET FAA-20

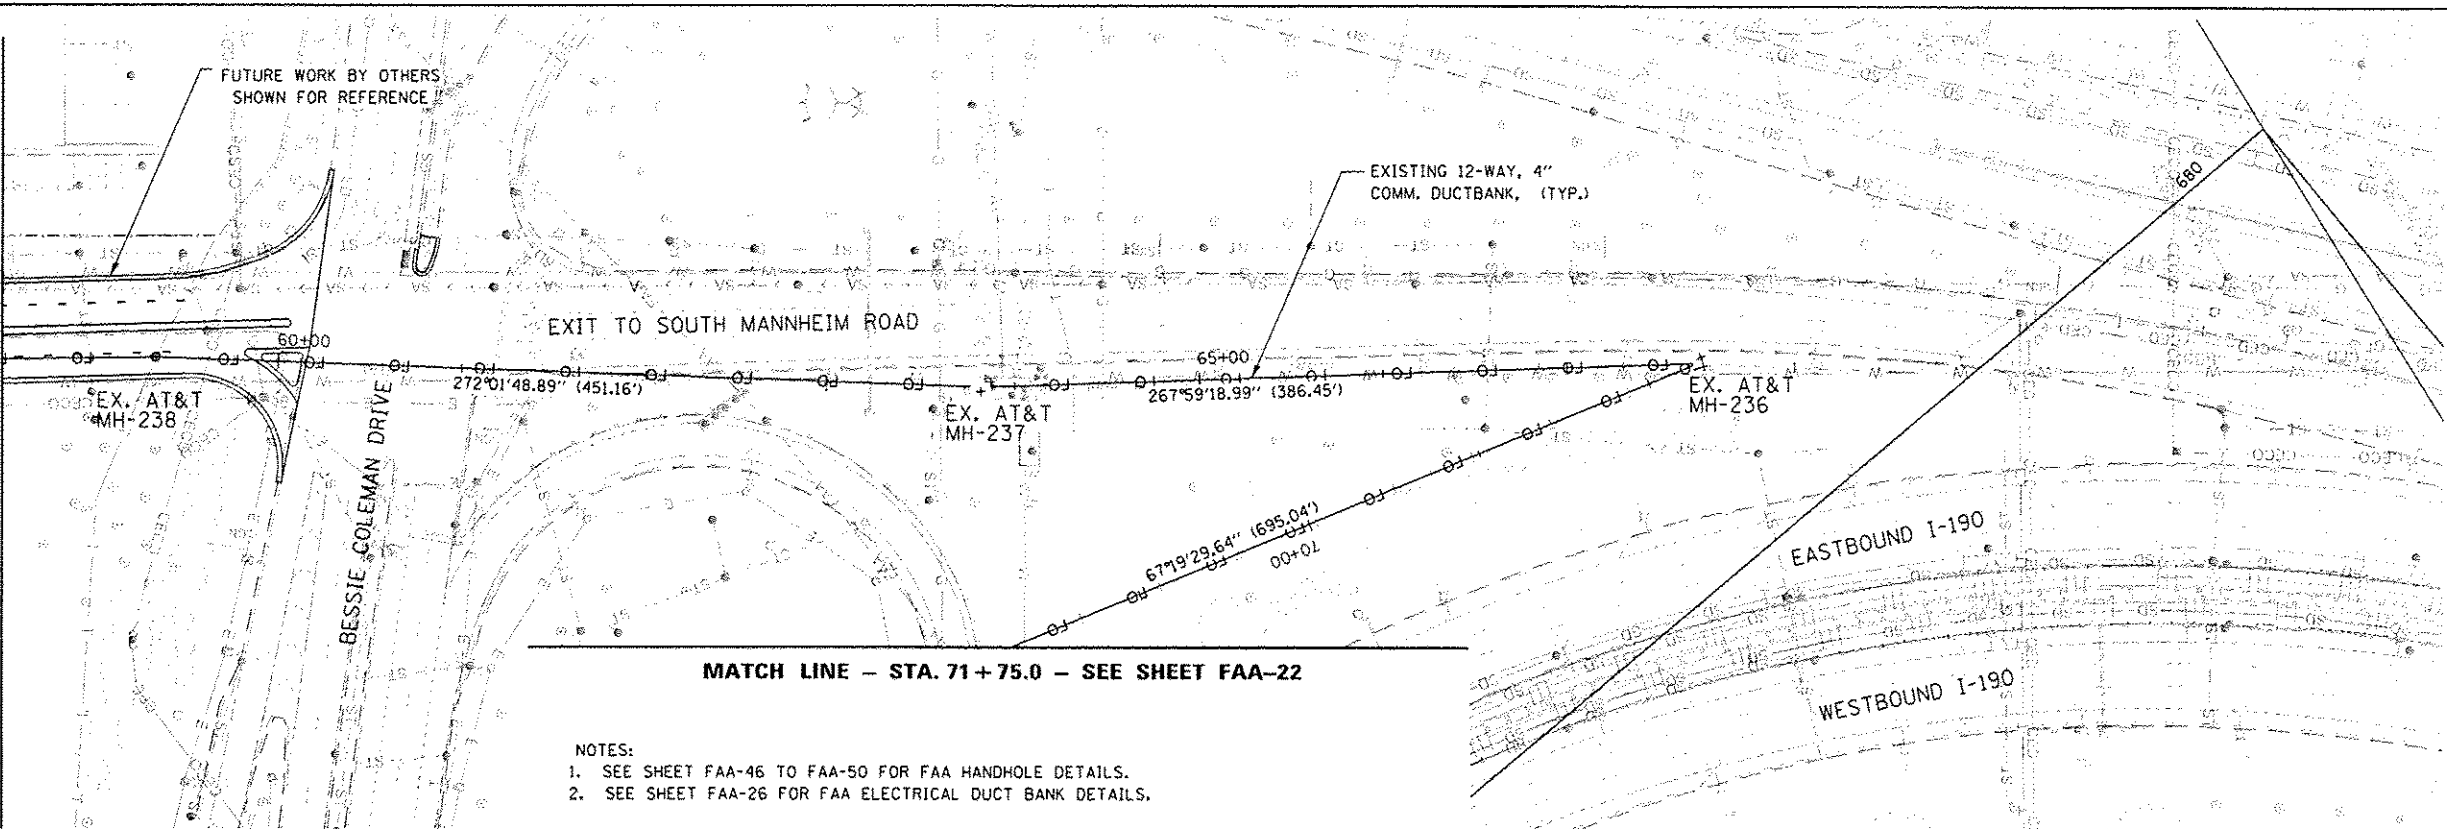


MATCH LINE - STA. 71 + 75.0 - SEE SHEET FAA-22

- NOTES:
1. SEE SHEET FAA-46 TO FAA-50 FOR FAA HANDHOLE DETAILS.
 2. SEE SHEET FAA-26 FOR FAA ELECTRICAL DUCT BANK DETAILS.

PROFILE	DATE
REVISED	BY
NOTED	DATE
NOTE BOOK	NO.
ADD FILE NAME	

MATCH LINE - STA. 58 + 50.0

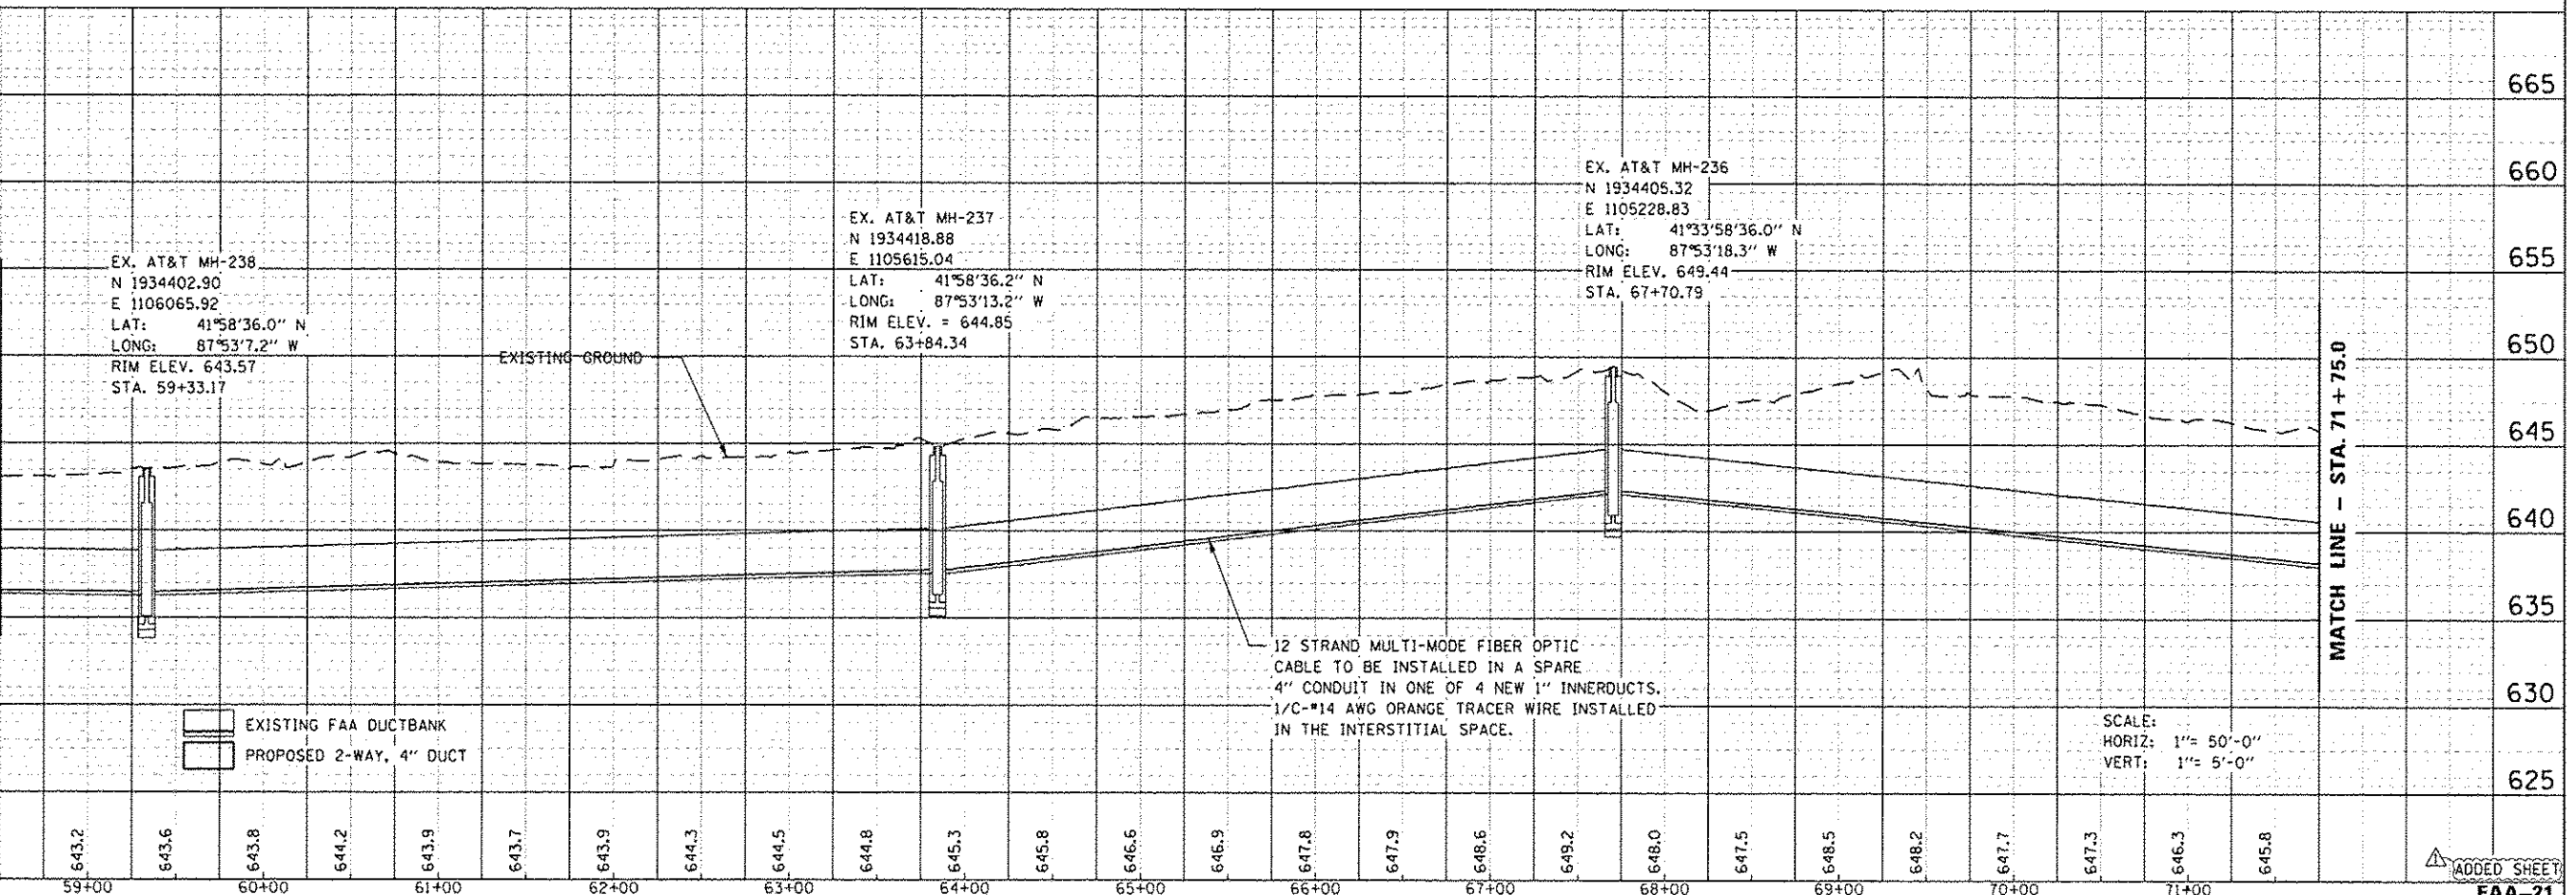

MATCH LINE - STA. 71 + 75.0

EXISTING FAA DUCTBANK
PROPOSED 2-WAY, 4" DUCT

12 STRAND MULTI-MODE FIBER OPTIC
CABLE TO BE INSTALLED IN A SPARE
4" CONDUIT IN ONE OF 4 NEW 1" INNERDUCTS.
1/C-#14 AWG ORANGE TRACER WIRE INSTALLED
IN THE INTERSTITIAL SPACE.

SCALE:
HORIZ: 1" = 50'-0"
VERT: 1" = 5'-0"

HNTB

USER NAME = mksir	DESIGNED CFB	REVISED -
PLOT SCALE = 100.00071	DRAWN CFB	REVISED -
PLOT DATE = 26-DEC-2012	CHECKED SPG	REVISED -
	DATE 10/19/12	REVISED 12/27/12 ADDENDUM 1

STATE OF ILLINOIS
DEPARTMENT OF TRANSPORTATION

FOTS LOOP 3
PLAN AND PROFILE

SCALE: SHEET NO. 6 OF 8 SHEETS STA. TO STA.

F.A.P. RTE. 330	SECTION 0105 WRS&HB	COUNTY COOK	TOTAL SHEET NO. 605
		CONTRACT NO. 60637	

FILE NAME JP_PWPdms47844\0168037-shr-FAA01521.dgn

ADDED SHEET
FAA-21