



MATCH LINE STA. 937+00 (NB)
SEE DRAWING DE-03

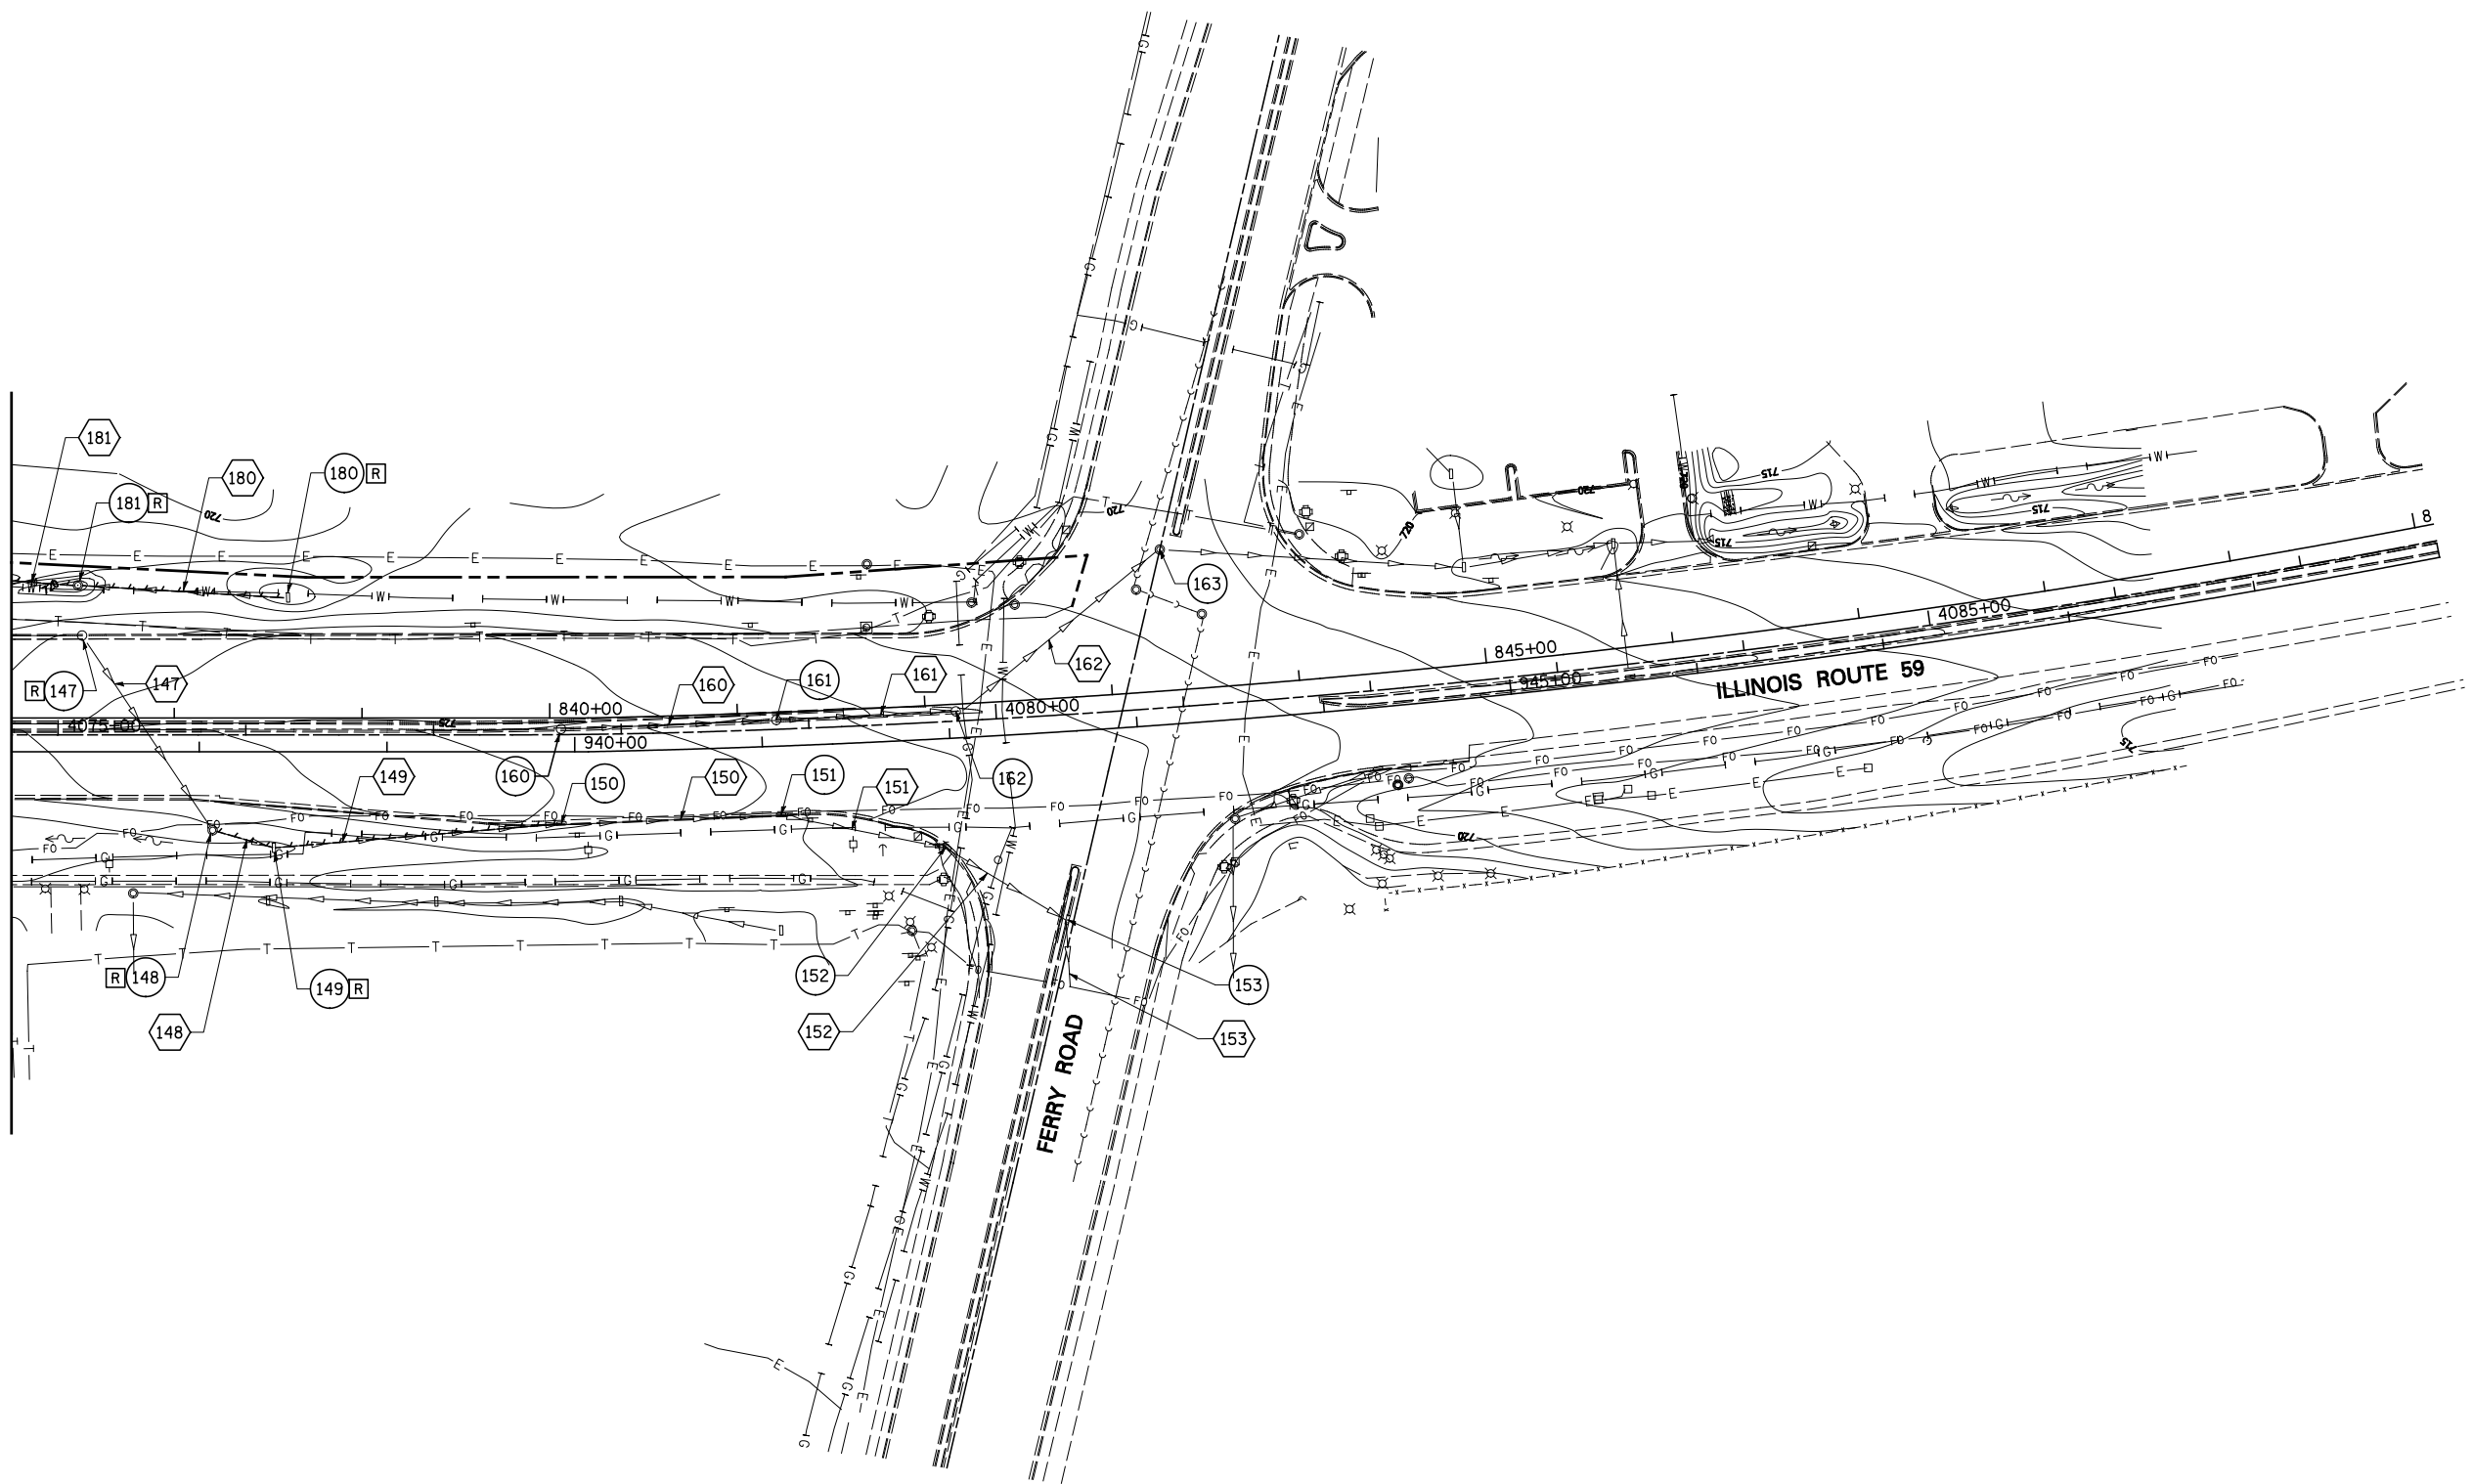

NOTE:
1. SEE DRAWING DN-01 FOR EXISTING DRAINAGE LEGEND.

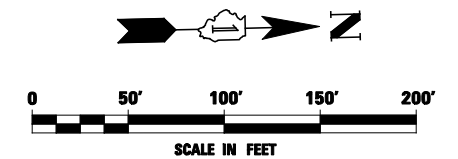

FILE NAME = *FILEL*	USER NAME = *USER*	DESIGNED <i>PJO</i>	REVISED -
		DRAWN <i>KES</i>	REVISED -
		CHECKED <i>JCM</i>	REVISED -
		DATE <i>10/15/2012</i>	REVISED -

**STATE OF ILLINOIS
DEPARTMENT OF TRANSPORTATION**

EXISTING DRAINAGE PLAN - ILLINOIS ROUTE 59

SCALE: 1"=50' SHEET NO. 4 OF 10 SHEETS STA. 937+00 TO STA. END

F.A.P. RTE.	SECTION	COUNTY	TOTAL SHEETS	SHEET NO.
338	(112 & 113) WRS-5	DUPAGE	963	331
DE-04			CONTRACT NO. 60I31	
ILLINOIS FED. AID PROJECT				