
 


MATCH LINE STA. 8975+00  
SEE BELOW

MATCH LINE STA. 8975+00  
SEE ABOVE

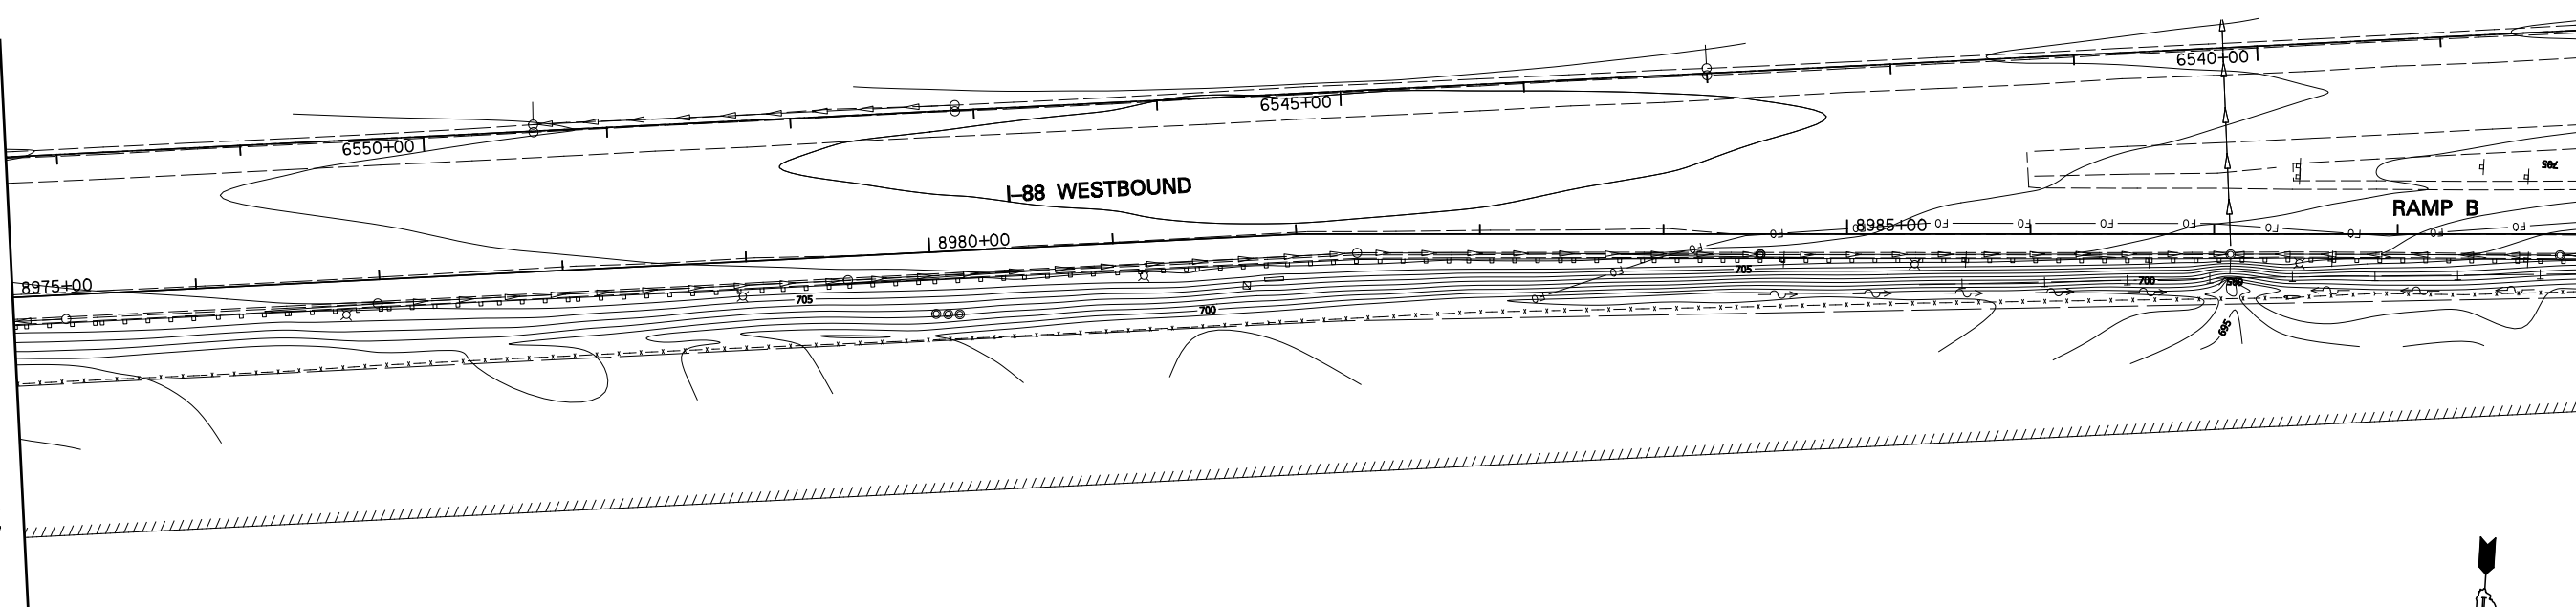

MATCH LINE STA. 8989+00  
SEE DRAWING DE-07



NOTE:  
1. SEE DRAWING DN-01 FOR EXISTING DRAINAGE LEGEND.

FILE NAME = #FILE#	USER NAME = #USER#	DESIGNED <i>PJO</i>	REVISED -	<b>STATE OF ILLINOIS DEPARTMENT OF TRANSPORTATION</b>	<b>EXISTING DRAINAGE PLAN - RAMP B</b>			F.A.P. RTE. 338	SECTION (112 & 113) WRS-5	COUNTY DUPAGE	TOTAL SHEETS 963	SHEET NO. 333
	PLOT SCALE = #SCALE#	CHECKED <i>JCM</i>	REVISED -		SCALE: 1"=50'	SHEET NO. 6 OF 10 SHEETS	STA. BEGIN TO STA. 8989+00	<b>DE-06</b>		CONTRACT NO. 60I31		
	PLOT DATE = #DATE#	DATE <i>10/15/2012</i>	REVISED -		ILLINOIS FED. AID PROJECT							