



MATCH LINE STA. 8974+00

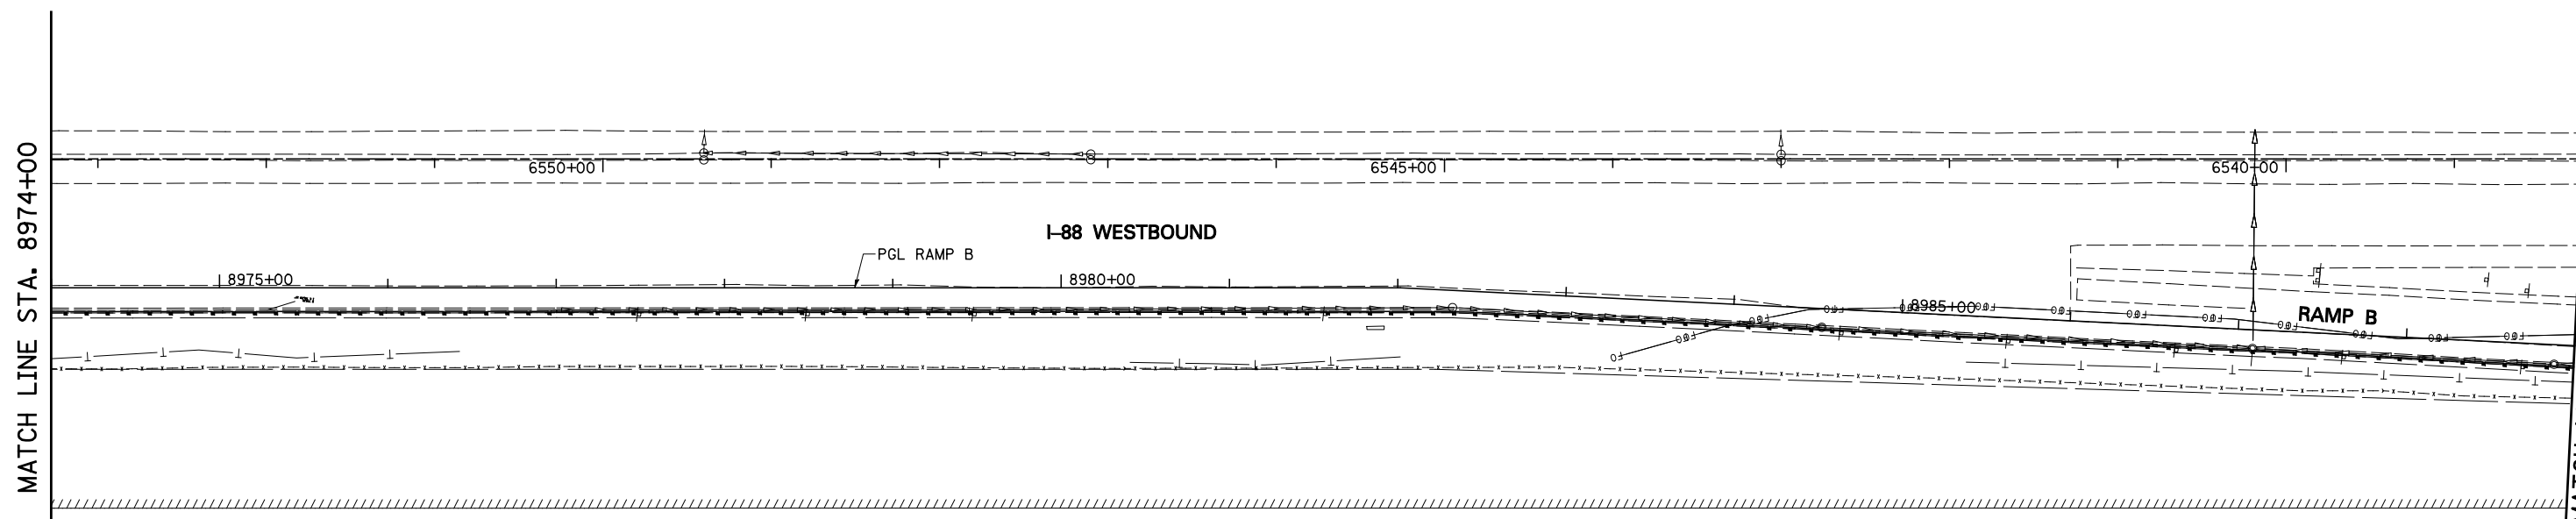

MATCH LINE STA. 8974+00

MATCH LINE STA. 8989+00
SEE DRAWING DP-08

 NOTE:
SEE DRAWING DN-01 FOR DRAINAGE LEGEND.



FILE NAME = #FILE#	USER NAME = #USER#	DESIGNED <i>PJO</i>	REVISED -	STATE OF ILLINOIS DEPARTMENT OF TRANSPORTATION	PROPOSED DRAINAGE PLAN - RAMP B			F.A.P. RTE.	SECTION	COUNTY	TOTAL SHEETS	SHEET NO.
		DRAWN <i>KES</i>	REVISED -					338	(112 & 113) WRS-5	DUPAGE	963	346
		PLOT SCALE = #SCALE#	CHECKED <i>JCM</i>		REVISED -	DP-09			CONTRACT NO. 60I31			
		PLOT DATE = #DATE#	DATE <i>10/15/2012</i>		REVISED -	SCALE: 1"=50'	SHEET NO. 9 OF 12 SHEETS	STA. BEGIN TO STA. 8989+00	ILLINOIS FED. AID PROJECT			