


SIGN DETAIL
1:75

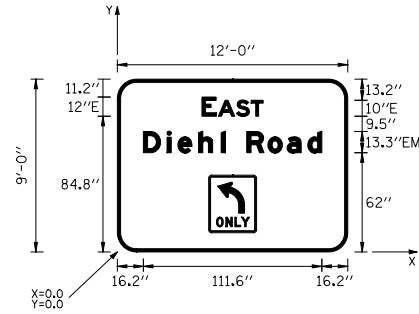

SIGN NUMBER	SB-IL59-TR-7
WIDTH x HGHT.	12'-0" x 10'-0"
BORDER WIDTH	2"
CORNER RADIUS	12"
MOUNTING	Overhead
BACKGROUND	TYPE: ZZ SHEETING COLOR: Green
LEGEND/BORDER	TYPE: ZZ SHEETING COLOR: White/White


SYMBOL	ROT	X	Y	WID	HT
R3-SL	0	57	12	30	36

Panel Style: guide_exp_advance_intermediate.ssi
Dimensions are in Inches.tenths

Letter locations are panel edge to lower left corner

LETTER POSITIONS (X)											LENGTH	SERIES/SIZE
E	A	S	T									E 2000
52.9	63.1	74.4	83.6									38.3 12,10
D	I	E	H	I	R	O	A	D				EM 2000
16.2	31	37.8	50.7	64.9	67.5	80.9	94.1	106.1	119			111.6 13.3/10

SIGN DETAIL
1:75

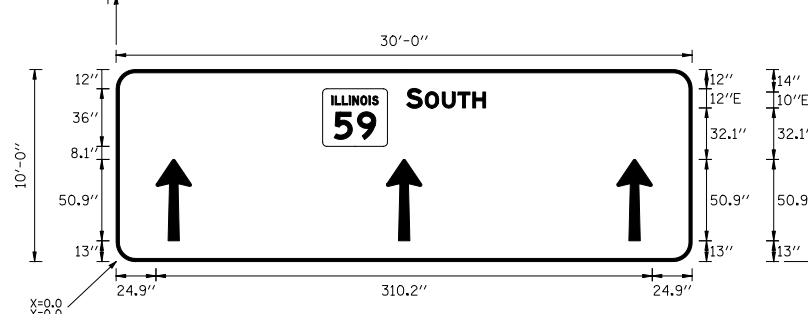

SIGN NUMBER	SB-IL59-TR-8
WIDTH x HGHT.	30'-0" x 10'-0"
BORDER WIDTH	2"
CORNER RADIUS	12"
MOUNTING	Overhead
BACKGROUND	TYPE: ZZ SHEETING COLOR: Green
LEGEND/BORDER	TYPE: ZZ SHEETING COLOR: White/White


SYMBOL	ROT	X	Y	WID	HT
MI-R004-2-32-150	0	129.1	72	40.5	36
AR Type A - Extended	0	24.9	13	22.2	50.9
AR Type A - Extended	0	168.9	13	22.2	50.9
AR Type A - Extended	0	318	13	13.3	50.9

Panel Style: guide_exp_advance_intermediate.ssi
Dimensions are in Inches.tenths

Letter locations are panel edge to lower left corner

LETTER POSITIONS (X)						LENGTH	SERIES/SIZE
S	O	U	T	H			E 2000
181.6	193.1	203.8	213.6	222.8			49.4 12,10

SIGN DETAIL
1:75

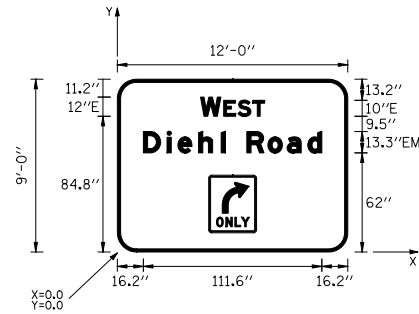


SIGN NUMBER	SB-IL59-TR-9
WIDTH x HGHT.	12'-0" x 10'-0"
BORDER WIDTH	2"
CORNER RADIUS	12"
MOUNTING	Overhead
BACKGROUND	TYPE: ZZ SHEETING COLOR: Green
LEGEND/BORDER	TYPE: ZZ SHEETING COLOR: White/White

SYMBOL	ROT	X	Y	WID	HT
R3-SR	0	57	12	30	36

Panel Style: guide_exp_advance_intermediate.ssi
Dimensions are in Inches.tenths

Letter locations are panel edge to lower left corner

LETTER POSITIONS (X)											LENGTH	SERIES/SIZE
W	E	S	T									E 2000
52	66.5	75.4	84.6									40.1 12,10
D	I	E	H	I	R	O	A	D				EM 2000
16.2	31	37.8	50.7	64.9	67.5	80.9	94.1	106.1	119			111.6 13.3/10

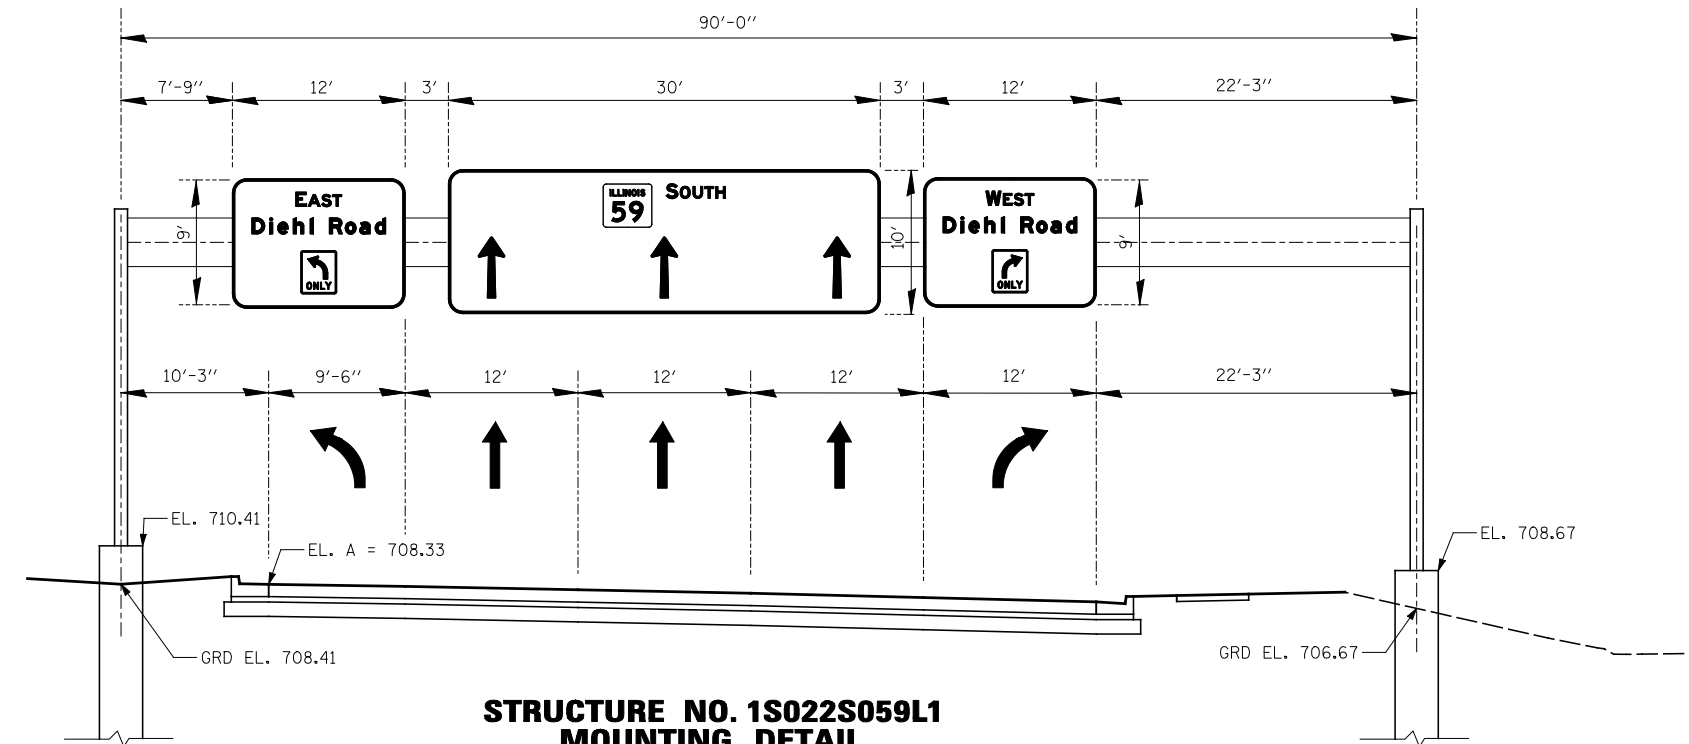

**STRUCTURE NO. 1S022S059L1
MOUNTING DETAIL
PROPOSED OVERHEAD SIGN STRUCTURE - SPAN
SB IL RTE 59, STA 810+00
(LOOKING SOUTH)**

FILE NAME =	USER NAME = #USER#	DESIGNED <i>PJO</i>	REVISED -
#FILEL#		DRAWN <i>KES</i>	REVISED -
	PLOT SCALE = #SCALE#	CHECKED <i>JCM</i>	REVISED -
	PLOT DATE = #DATE#	DATE <i>10/15/2012</i>	REVISED -

**STATE OF ILLINOIS
DEPARTMENT OF TRANSPORTATION**

**SIGN STRUCTURES
SPAN 1S022S059L1 (IDOT)**

SCALE: SHEET NO. 1 OF 15 SHEETS STA. 810+00 TO STA.

F.A.P. RTE.	SECTION	COUNTY	TOTAL SHEETS	SHEET NO.
338	(112 & 113) WRS-5	DUPAGE	963	401
CONTRACT NO. 60131				
ILLINOIS FED. AID PROJECT				