


**SIGN DETAIL**  
1:75

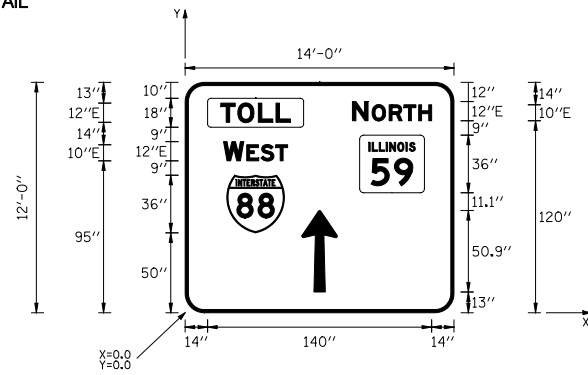

Panel Style: *guide\_exp\_advance\_intermediate.ssi*  
Dimensions are in Inches.tenths


Letter locations are panel edge to lower left corner

|               |   |
|---------------|---|
| SIGN NUMBER   | NB-IL59-TR-1                                  |
| WIDTH x HGHT. | 14'-0" x 12'-0"                               |
| BORDER WIDTH  | 2"  |
| CORNER RADIUS | 12"   |
| MOUNTING      | Overhead                                      |
| BACKGROUND    | TYPE: ZZ SHEETING<br>COLOR: Green             |
| LEGEND/BORDER | TYPE: ZZ SHEETING<br>COLOR: White /BlackWhite |

| SYMBOL               | ROT | X    | Y  | WID  | HT   |
|----------------------|-----|------|----|------|------|
| M1-100A-2-32-150     | 0   | 109  | 75 | 40.5 | 36   |
| M1_1                 | 0   | 26   | 50 | 36   | 36   |
| AR_Type A - Extended | 0   | 72.9 | 13 | 22.2 | 50.9 |

| LETTER POSITIONS (X) |       |       |       |       |  | LENGTH | SERIES/SIZE |
|----------------------|-------|-------|-------|-------|--|--------|-------------|
| N                    | O     | R     | T     | H     |  |        | E 2000      |
| 104.5                | 116.8 | 127.5 | 136.7 | 145.9 |  | 49.5   | 12,10       |
| T                    | O     | L     | L     |       |  |        | E 2000      |
| 22.2                 | 32.9  | 45.7  | 56.8  |       |  | 43.6   | 12          |
| W                    | E     | S     | T     |       |  |        | E 2000      |
| 24                   | 38.5  | 47.4  | 56.6  |       |  | 40.1   | 12,10       |

**SIGN DETAIL**  
1:75

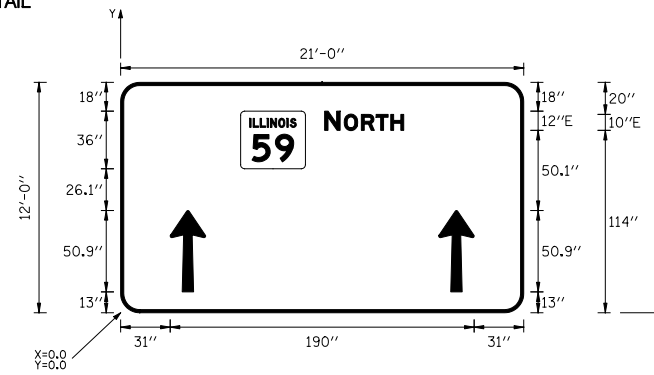

Panel Style: *guide\_exp\_advance\_intermediate.ssi*  
Dimensions are in Inches.tenths


Letter locations are panel edge to lower left corner

|               |   |
|---------------|---|
| SIGN NUMBER   | NB-IL59-TR-2                            |
| WIDTH x HGHT. | 21'-0" x 12'-0"                         |
| BORDER WIDTH  | 2"                                      |
| CORNER RADIUS | 12"                                     |
| MOUNTING      | Overhead                                |
| BACKGROUND    | TYPE: ZZ SHEETING<br>COLOR: Green       |
| LEGEND/BORDER | TYPE: ZZ SHEETING<br>COLOR: White/White |

| SYMBOL               | ROT | X     | Y  | WID  | HT   |
|----------------------|-----|-------|----|------|------|
| M1-100A-2-32-150     | 0   | 75    | 90 | 40.5 | 36   |
| AR_Type A - Extended | 0   | 31    | 13 | 22.2 | 50.9 |
| AR_Type A - Extended | 0   | 198.9 | 13 | 22.2 | 50.9 |

| LETTER POSITIONS (X) |       |       |       |       |  | LENGTH | SERIES/SIZE |
|----------------------|-------|-------|-------|-------|--|--------|-------------|
| N                    | O     | R     | T     | H     |  |        | E 2000      |
| 127.5                | 139.8 | 150.5 | 159.7 | 168.9 |  | 49.5   | 12,10       |

**SIGN DETAIL**  
1:75

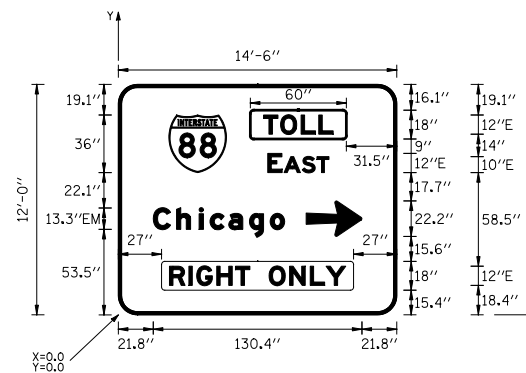


Panel Style: *guide\_exp\_advance\_intermediate.ssi*  
Dimensions are in Inches.tenths

Letter locations are panel edge to lower left corner

|               |   |
|---------------|---|
| SIGN NUMBER   | NB-IL59-TR-3                                  |
| WIDTH x HGHT. | 14'-6" x 12'-0"                               |
| BORDER WIDTH  | 2"  |
| CORNER RADIUS | 12"   |
| MOUNTING      | Overhead                                      |
| BACKGROUND    | TYPE: ZZ SHEETING<br>COLOR: Green             |
| LEGEND/BORDER | TYPE: ZZ SHEETING<br>COLOR: White /BlackWhite |

| SYMBOL    | ROT | X     | Y    | WID  | HT   |
|-----------|-----|-------|------|------|------|
| M1_1      | 0   | 31.5  | 88.9 | 36   | 36   |
| AR_Type A | 270 | 117.3 | 49   | 22.2 | 34.9 |

| LETTER POSITIONS (X) |       |       |       |      |      |      |     |       |       |  |  | LENGTH | SERIES/SIZE |         |         |
|----------------------|-------|-------|-------|------|------|------|-----|-------|-------|--|--|--------|-------------|---------|---------|
| T                    | O     | L     | L     |      |      |      |     |       |       |  |  |        |             | E 2000  |         |
| 90.7                 | 101.4 | 114.2 | 125.3 |      |      |      |     |       |       |  |  |        |             | 43.6    | 12      |
| E                    | A     | S     | T     |      |      |      |     |       |       |  |  |        |             | E 2000  |         |
| 93.4                 | 103.6 | 114.9 | 124.1 |      |      |      |     |       |       |  |  |        |             | 38.3    | 12,10   |
| C                    | h     | i     | c     | a    | g    | o    |     |       |       |  |  |        |             | EM 2000 |         |
| 21.8                 | 36.3  | 50.5  | 57.3  | 69   | 81.9 | 94.9 |     |       |       |  |  |        |             | 82.1    | 13,3/10 |
| R                    | I     | G     | H     | T    | O    | N    | L   | Y     |       |  |  |        |             | E 2000  |         |
| 31.9                 | 44    | 49    | 61.4  | 73.2 | 82.2 | 94.2 | 107 | 119.9 | 129.8 |  |  |        |             | 110.2   | 12      |

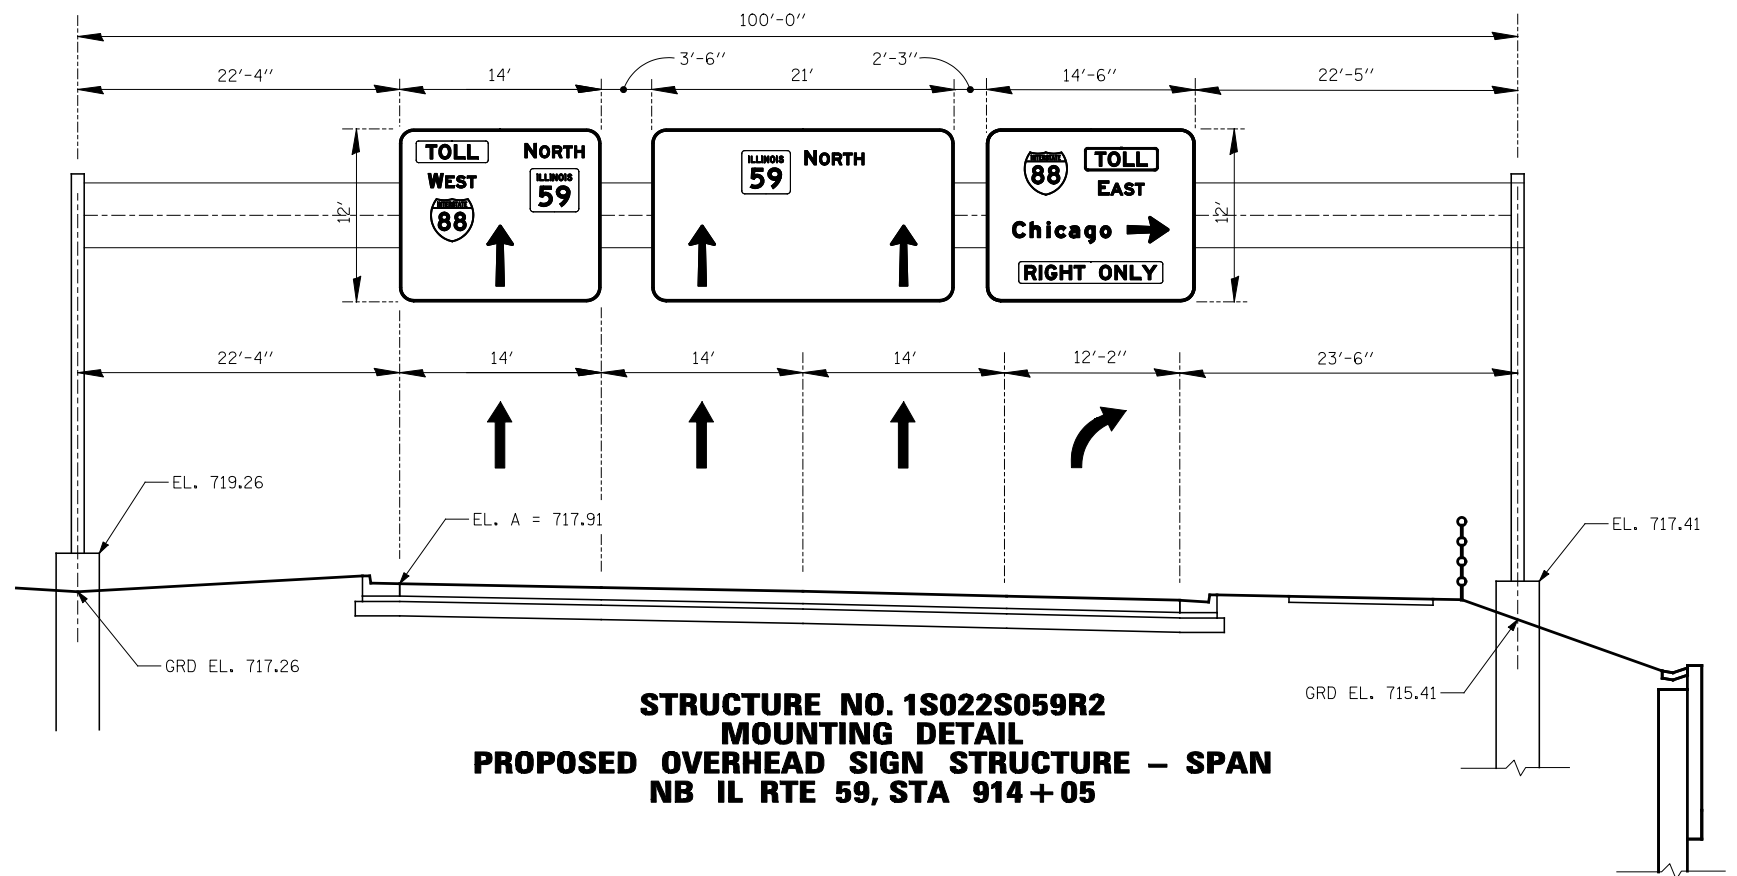

**STRUCTURE NO. 1S022S059R2  
MOUNTING DETAIL  
PROPOSED OVERHEAD SIGN STRUCTURE - SPAN  
NB IL RTE 59, STA 914 + 05**

|             |                      |                        |           |
|-------------|----------------------|------------------------|-----------|
| FILE NAME = | USER NAME = #USER*   | DESIGNED <i>PJO</i>    | REVISED - |
| #FILEL#     |                      | DRAWN <i>KES</i>       | REVISED - |
|             | PLOT SCALE = #SCALE* | CHECKED <i>JCM</i>     | REVISED - |
|             | PLOT DATE = #DATE*   | DATE <i>10/15/2012</i> | REVISED - |

**STATE OF ILLINOIS  
DEPARTMENT OF TRANSPORTATION**

**SIGN STRUCTURES  
SPAN 1S022S059R2 (IDOT)**

SCALE: SHEET NO. 2 OF 15 SHEETS STA. 914+05 TO STA.

| F.A.P. RTE.               | SECTION           | COUNTY | TOTAL SHEETS | SHEET NO. |
|---------------------------|-------------------|--------|--------------|-----------|
| 338                       | (112 & 113) WRS-5 | DUPAGE | 963          | 402       |
| CONTRACT NO. 60131        |                   |        |              |           |
| ILLINOIS FED. AID PROJECT |                   |        |              |           |