


**SIGN DETAIL**  
1:75

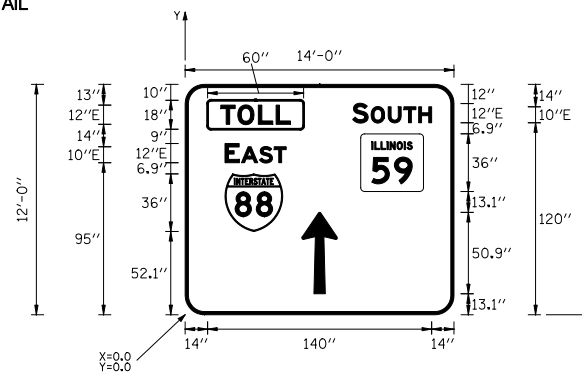

Panel Style: *guide\_exp\_advance\_intermediate.ssi*  
Dimensions are in *inches.tenths*


Letter locations are panel edge to lower left corner

SIGN NUMBER	SB-IL59-TR-4
WIDTH x HGHT.	14'-0" x 12'-0"
BORDER WIDTH	2"
CORNER RADIUS	12"
MOUNTING	Overhead
BACKGROUND	TYPE: ZZ SHEETING COLOR: Green
LEGEND/BORDER	TYPE: ZZ SHEETING COLOR: White/BlackWhite

SYMBOL	ROT	X	Y	WID	HT
M1-100A-2-22-100	0	108.7	77.1	39.3	36
M1_1	0	24.9	52.1	36	36
AR_Type A - Extended	0	72.9	13.1	22.2	50.9

LETTER POSITIONS (X)					LENGTH	SERIES/SIZE
S	O	U	T	H		E 2000
104.6	116.2	126.9	136.7	145.9	49.4	12,10
T	O	L	L			E 2000
22.2	32.9	45.8	56.8		43.6	12
E	A	S	T			E 2000
24.9	35.1	46.4	55.6		38.2	12,10

**SIGN DETAIL**  
1:75

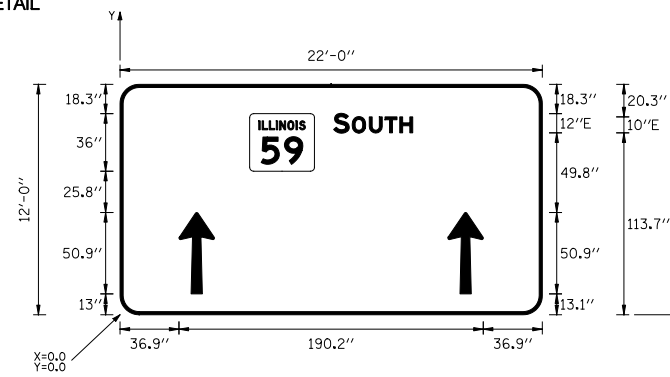

Panel Style: *guide\_exp\_advance\_intermediate.ssi*  
Dimensions are in *inches.tenths*


Letter locations are panel edge to lower left corner

SIGN NUMBER	SB-IL59-TR-5
WIDTH x HGHT.	22'-0" x 12'-0"
BORDER WIDTH	2"
CORNER RADIUS	12"
MOUNTING	Overhead
BACKGROUND	TYPE: ZZ SHEETING COLOR: Green
LEGEND/BORDER	TYPE: ZZ SHEETING COLOR: White/White

SYMBOL	ROT	X	Y	WID	HT
M1-100A-2-32-150	0	81.1	89.7	40.5	36
AR_Type A - Extended	0	36.9	13	22.2	50.9
AR_Type A - Extended	0	205	13.1	22.2	50.9

LETTER POSITIONS (X)					LENGTH	SERIES/SIZE
S	O	U	T	H		E 2000
133.6	145.1	155.8	165.6	174.8	49.4	12,10

**SIGN DETAIL**  
1:75

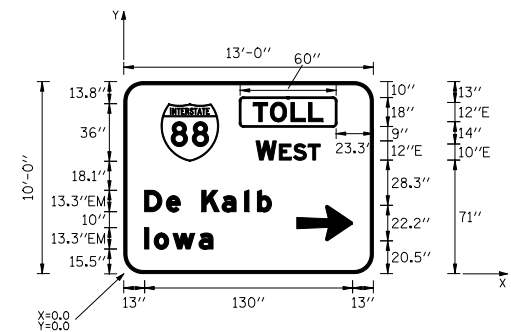


Panel Style: *guide\_exp\_advance\_intermediate.ssi*  
Dimensions are in *inches.tenths*

Letter locations are panel edge to lower left corner

SIGN NUMBER	SB-IL59-TR6
WIDTH x HGHT.	13'-0" x 10'-0"
BORDER WIDTH	2"
CORNER RADIUS	12"
MOUNTING	Overhead
BACKGROUND	TYPE: ZZ SHEETING COLOR: Green
LEGEND/BORDER	TYPE: ZZ SHEETING COLOR: White/BlackWhite

SYMBOL	ROT	X	Y	WID	HT
M1_1	0	23.3	70.2	36	36
AR_Type A	270	108.1	20.5	22.2	34.9

LETTER POSITIONS (X)					LENGTH	SERIES/SIZE	
T	O	L	L			E 2000	
80.9	91.6	104.5	115.5		43.6	12	
W	E	S	T			E 2000	
82.7	97.2	106.1	115.3		40.1	12,10	
D	e	K	a	I	b	EM 2000	
13	26.6	35.4	48.7	61.4	75.5	79.3	13.310
I	o	w	a			EM 2000	
13	19	30.7	47			42.8	13.310

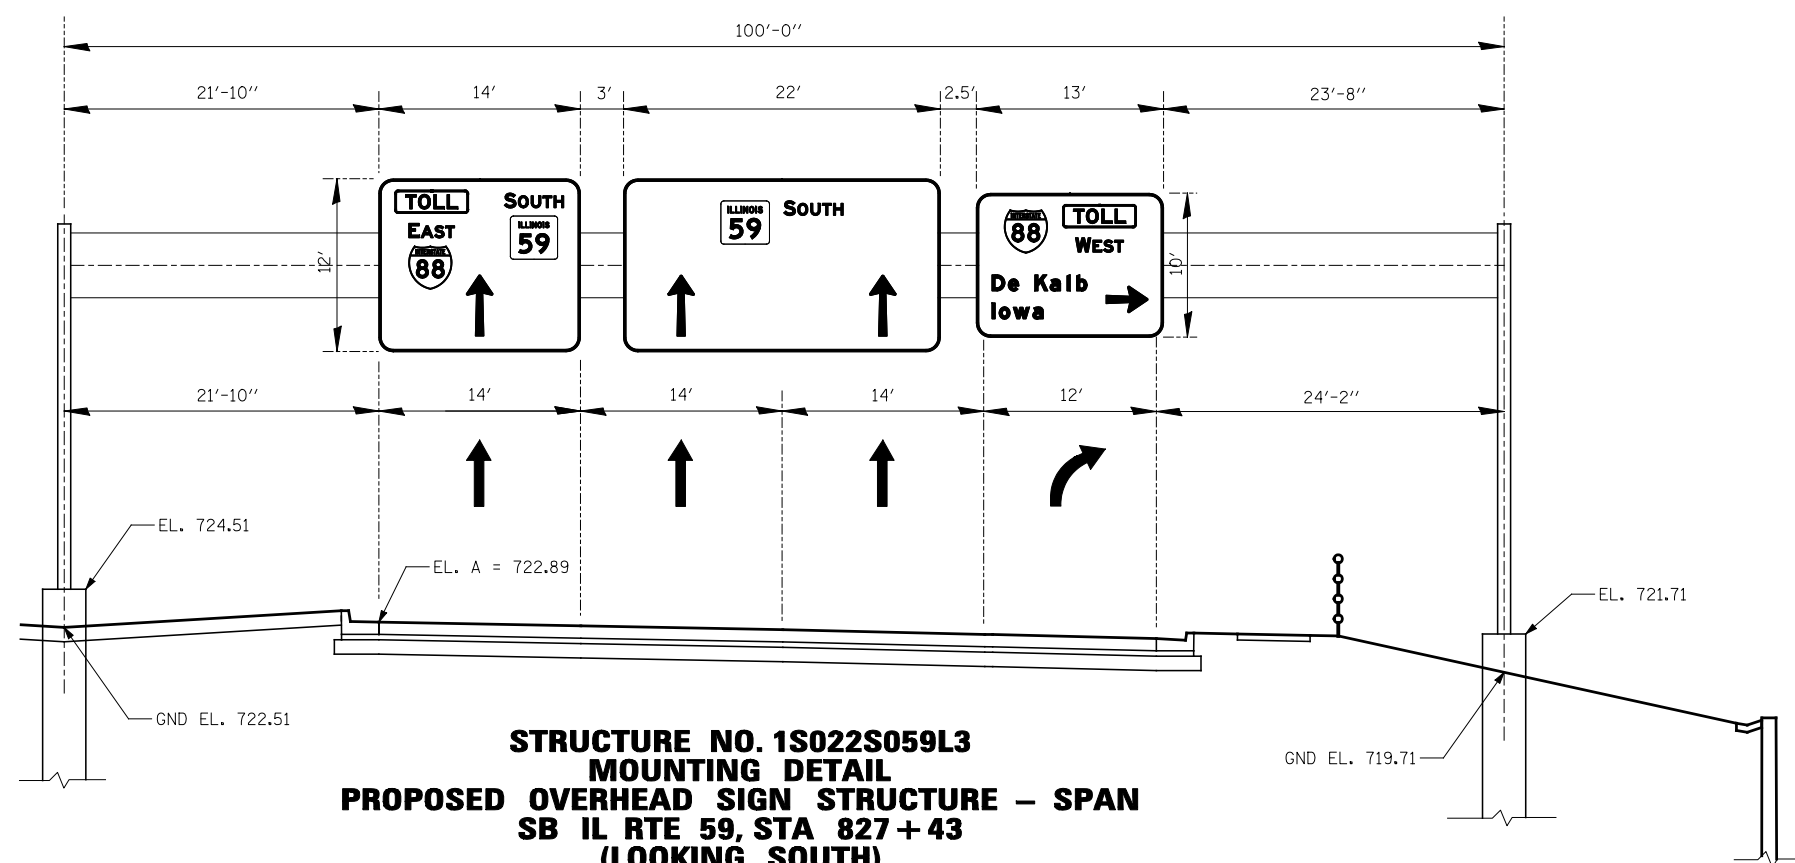

**STRUCTURE NO. 1S022S059L3  
MOUNTING DETAIL  
PROPOSED OVERHEAD SIGN STRUCTURE - SPAN  
SB IL RTE 59, STA 827 + 43  
(LOOKING SOUTH)**

FILE NAME =	USER NAME = #USER*	DESIGNED <i>PJO</i>	REVISED -
#FILEL#		DRAWN <i>KES</i>	REVISED -
	PLOT SCALE = #SCALE*	CHECKED <i>JCM</i>	REVISED -
	PLOT DATE = #DATE*	DATE <i>10/15/2012</i>	REVISED -

**STATE OF ILLINOIS  
DEPARTMENT OF TRANSPORTATION**

<b>SIGN STRUCTURES SPAN 1S022S059L3 (IDOT)</b>	
SCALE:	SHEET NO. 3 OF 15 SHEETS STA. 827+43 TO STA.

F.A.P. RTE.	SECTION	COUNTY	TOTAL SHEETS	SHEET NO.
338	(112 & 113) WRS-5	DUPAGE	963	403
CONTRACT NO. 60I31				
ILLINOIS FED. AID PROJECT				