



- NOTES:**
- COORDINATE REMOVAL OF EXISTING UNDERPASS LIGHTING WITH THE REMOVAL OF THE STRUCTURE.
  - EXISTING LIGHTING CONTROLLER SHALL REMAIN ACTIVE UNTIL ALL LIGHTING IS TRANSFERRED TO THE NEW CONTROLLER. COORDINATE THE REMOVAL OF EXISTING CONTROLLER WITH ALL TRADES.
  - FOR SYMBOL LIST AND GENERAL ELECTRICAL NOTES, SEE SHEET LT-6.
  - NEW TOLLWAY LIGHTING CONTROLLER SHALL BE INSTALLED AND TEMPORARY AERIAL CONNECTIONS SHALL BE PROVIDED TO ALL TEMPORARY AND EXISTING TO REMAIN LIGHTING UNITS. AERIAL CABLES SHALL BE RUN DOWN THE TEMPORARY WOOD POLE UNDERGROUND AND THROUGH THE CONDUIT ELBOWS IN THE CONTROLLER FOUNDATION TO THE PROPER CIRCUIT BREAKERS. AERIAL CONNECTIONS SHALL BE REMOVED AFTER ALL NEW LIGHTING UNITS AND WIRING BECOME FUNCTIONAL.
  - FOR COMED SERVICE TO NEW LIGHTING CONTROLLER, SEE DETAIL ON SHEET LT-19.

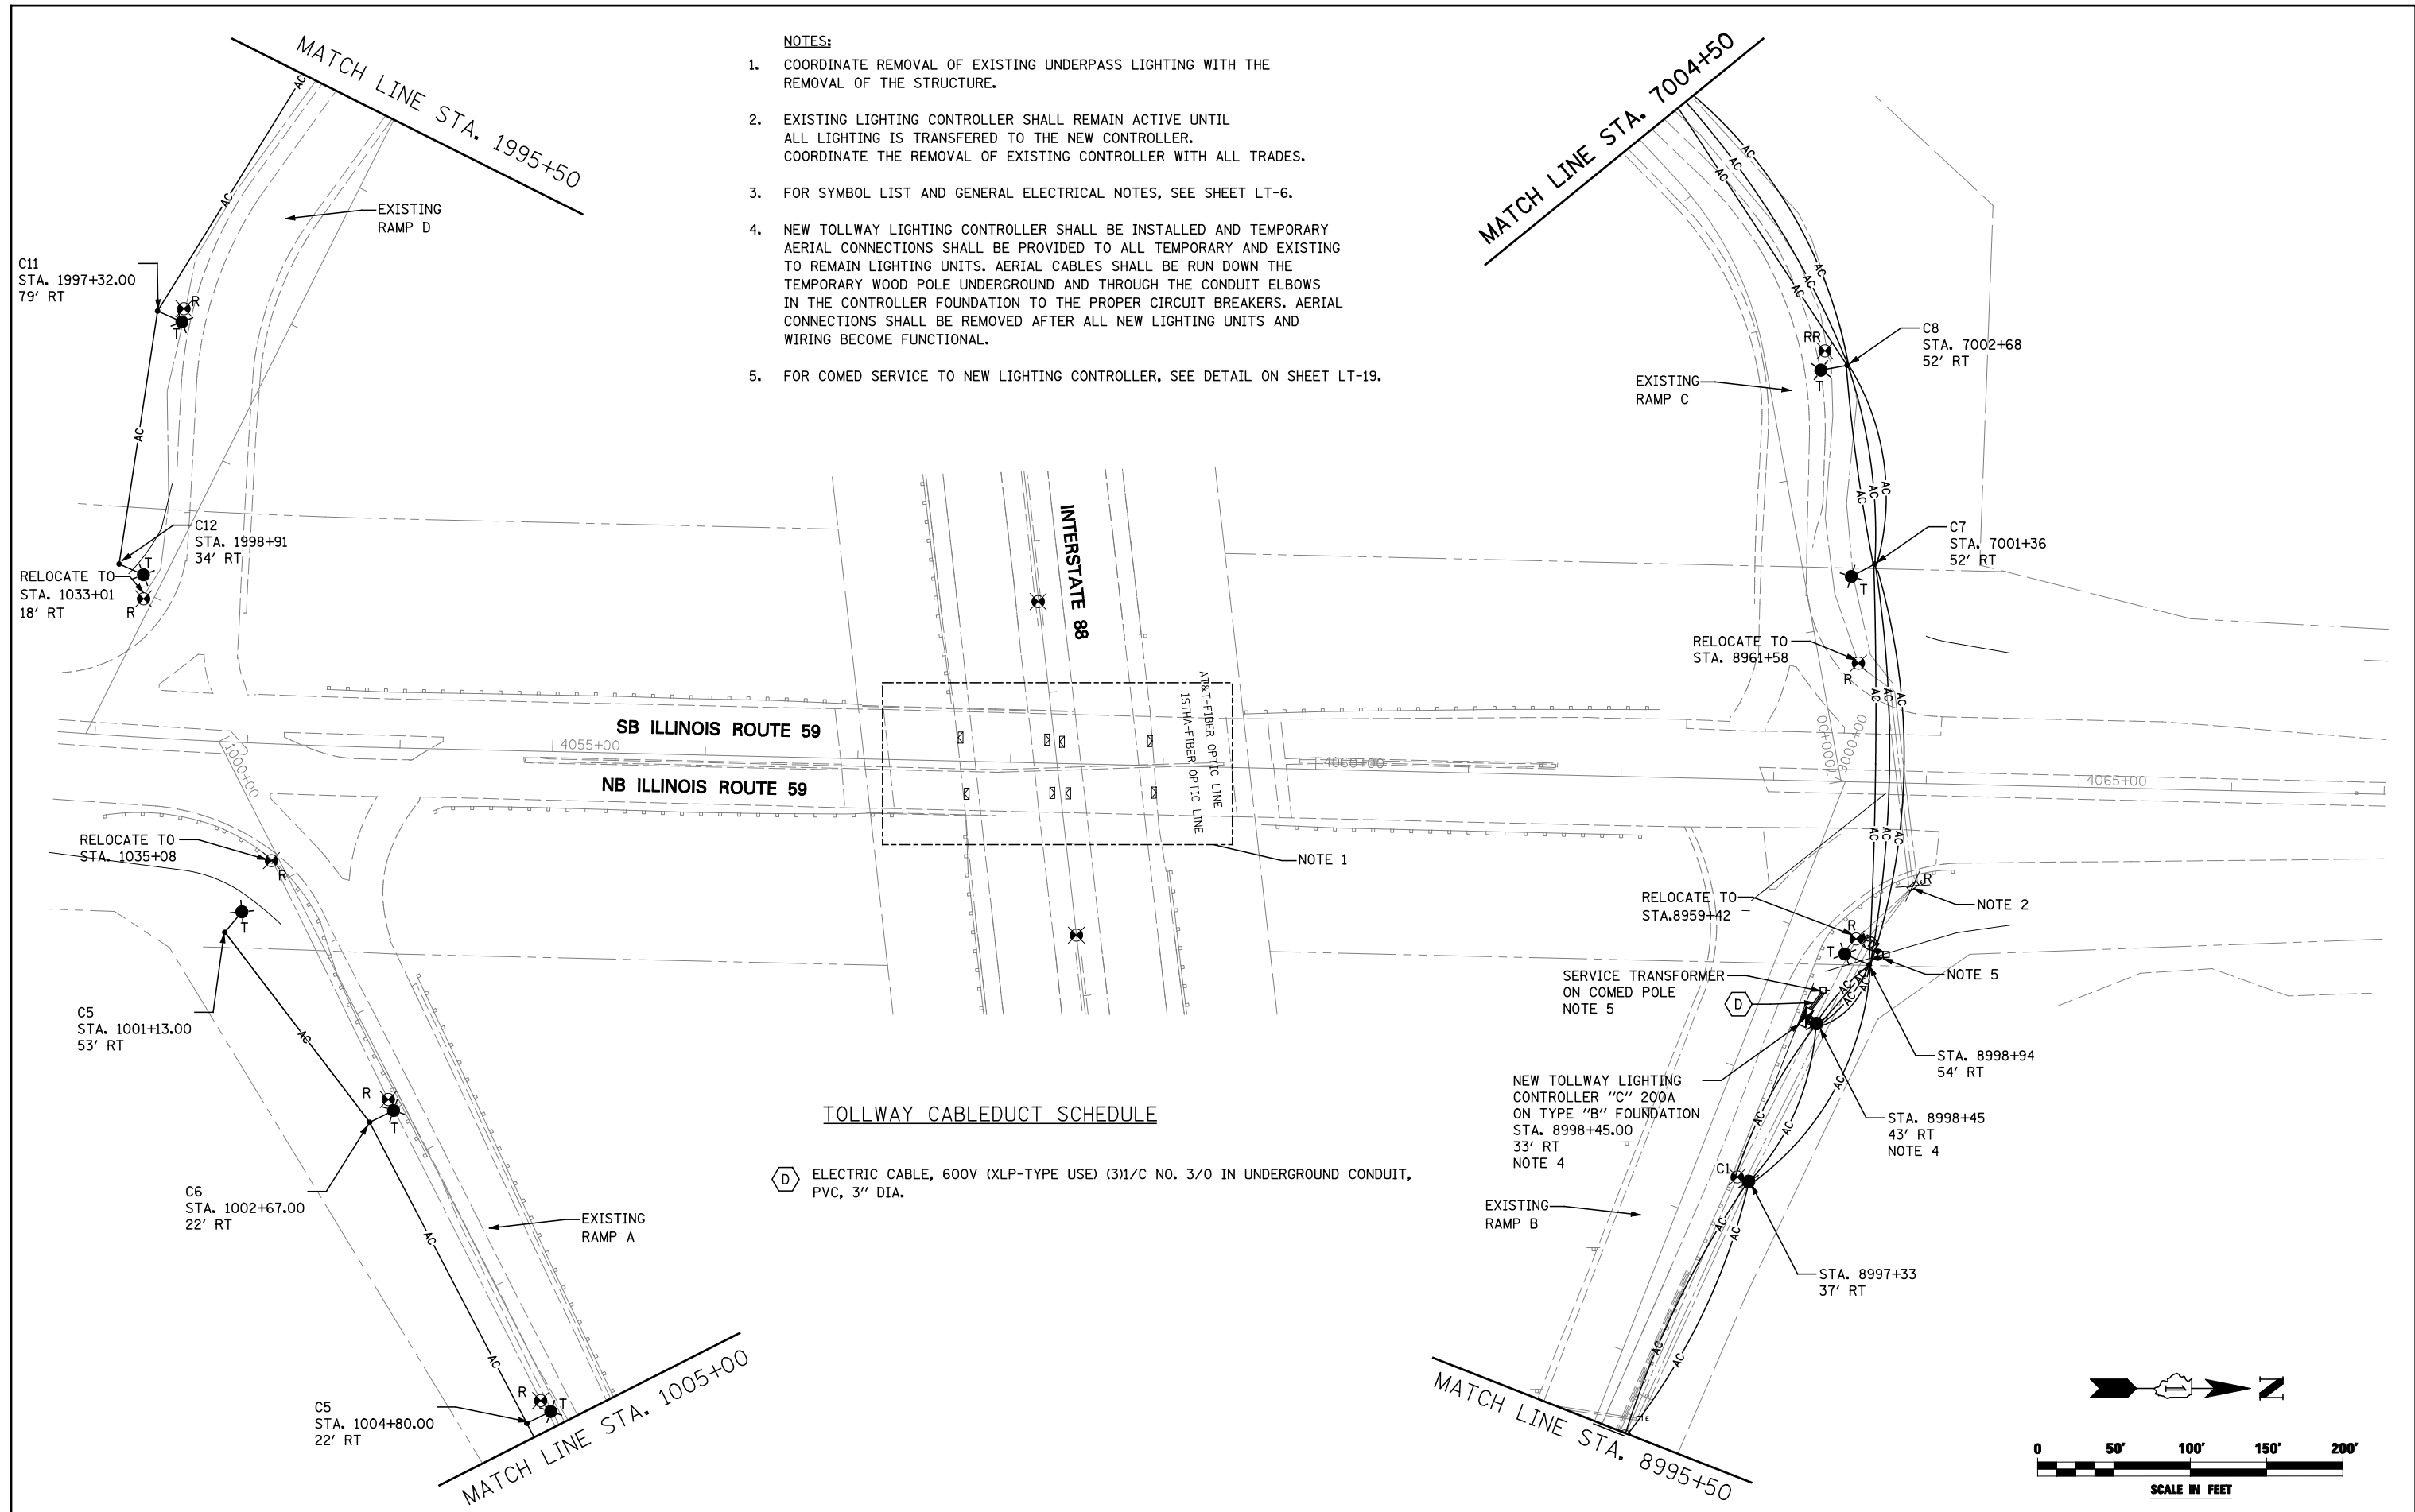

**TOLLWAY CABLEDUCT SCHEDULE**

**D** ELECTRIC CABLE, 600V (XLP-TYPE USE) (3)1/C NO. 3/0 IN UNDERGROUND CONDUIT, PVC, 3" DIA.

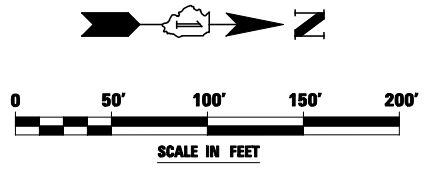

FILE NAME = #FILE#	USER NAME = #USER#	DESIGNED MCP	REVISED -
		DRAWN MLB	REVISED -
		CHECKED MCP	REVISED -
		DATE 10/15/2012	REVISED -

**STATE OF ILLINOIS  
DEPARTMENT OF TRANSPORTATION**

<b>TOLLWAY DEMOLITION AND TEMPORARY LIGHTING PLAN</b>			
<b>ILLINOIS ROUTE 59 AT INTERSTATE 88</b>			
SCALE: AS SHOWN	SHEET NO. 1 OF 5 SHEETS	STA. 4051+75	TO STA. 4067+00

F.A.P. RTE.	SECTION	COUNTY	TOTAL SHEETS	SHEET NO.
338	(112 & 113) WRS-5	DUPAGE	963	562
<b>LT-07</b>			CONTRACT NO. 60I31	
ILLINOIS FED. AID PROJECT				