
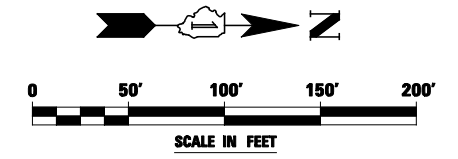


NOTES:

1. FOR SYMBOL LIST AND GENERAL ELECTRICAL NOTES, SEE SHEET LT-6.
2. EXISTING POLE AND LUMINAIRE SHALL BE REMOVED DURING CONSTRUCTION AND SHALL BE REINSTALLED ON THE SAME FOUNDATION AT THE COMPLETION OF CONSTRUCTION.

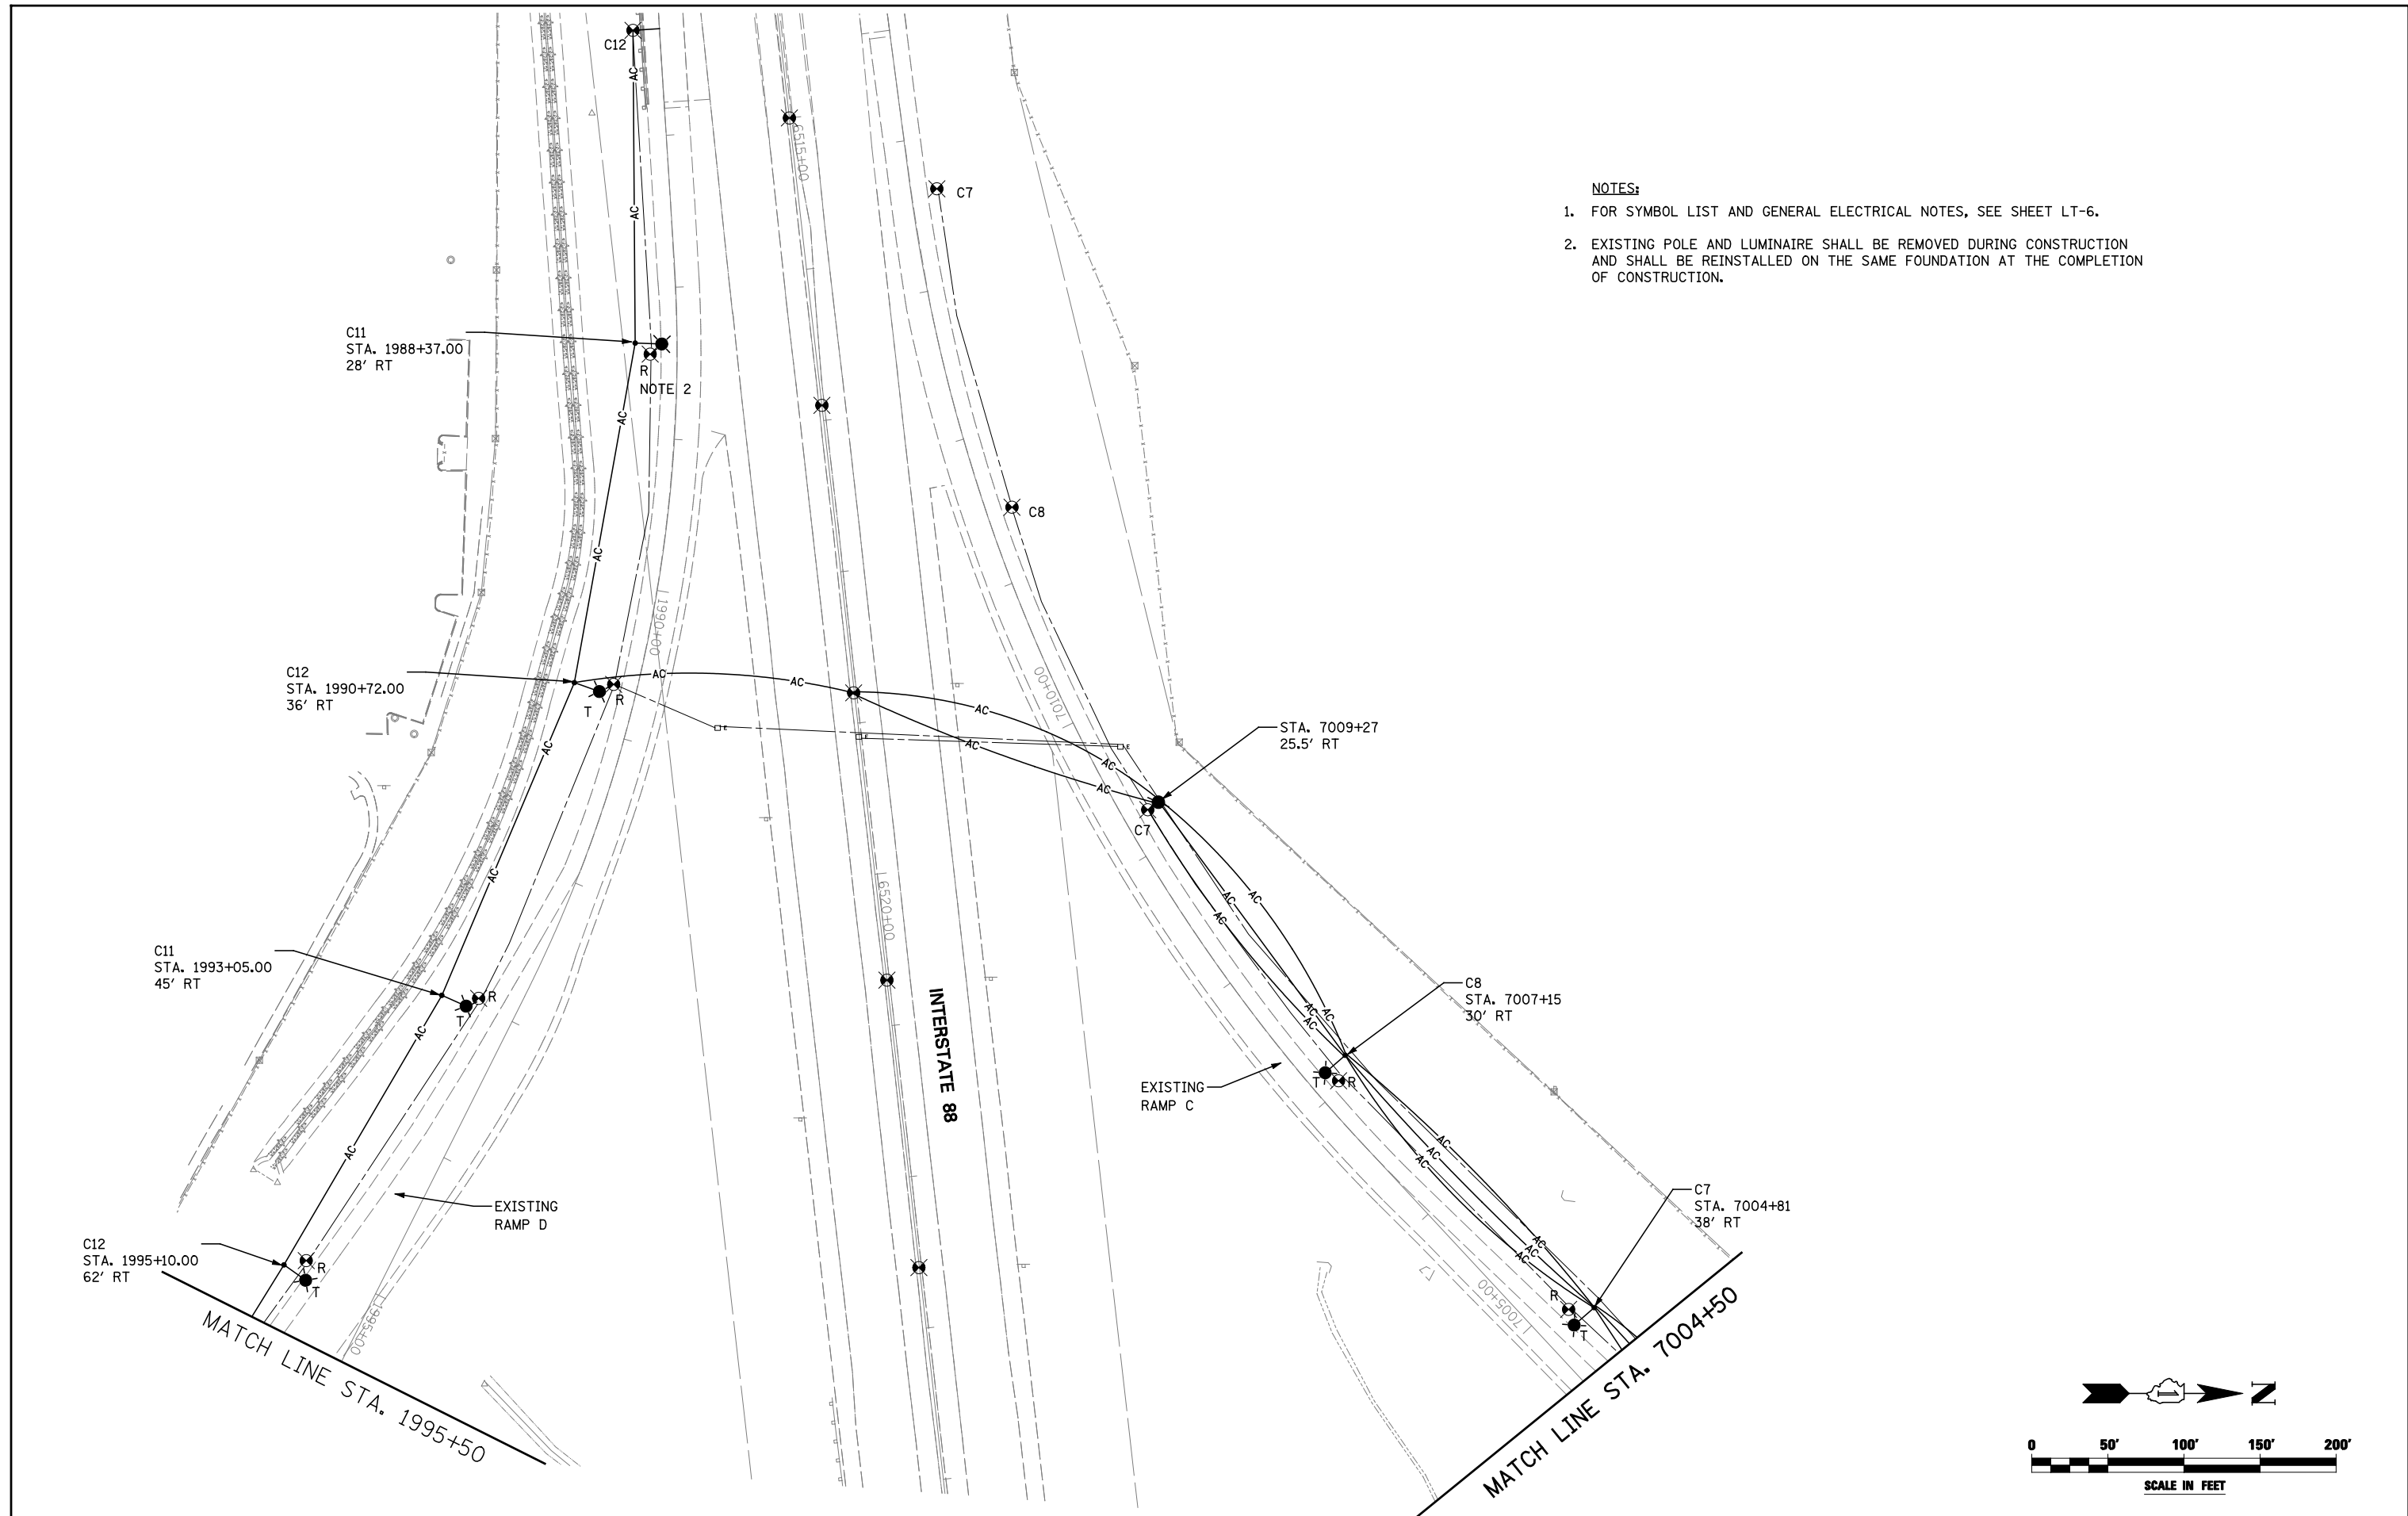

| | | | |
|------------------------|--------------------|-----------------|-----------|
| FILE NAME = #FILEL# | USER NAME = #USER# | DESIGNED MCP | REVISED - |
| | | DRAWN MLB | REVISED - |
| | | CHECKED MCP | REVISED - |
| | | DATE 10/15/2012 | REVISED - |

**STATE OF ILLINOIS
DEPARTMENT OF TRANSPORTATION**

**TOLLWAY DEMOLITION AND TEMPORARY LIGHTING PLAN
ILLINOIS ROUTE 59 AT INTERSTATE 88 - RAMPS C & D**

| | | | | |
|---------------------------|-------------------|--------|--------------------|-----------|
| F.A.P. RTE. | SECTION | COUNTY | TOTAL SHEETS | SHEET NO. |
| 338 | (112 & 113) WRS-5 | DUPAGE | 963 | 563 |
| LT-08 | | | CONTRACT NO. 60I31 | |
| ILLINOIS FED. AID PROJECT | | | | |

SCALE: AS SHOWN | SHEET NO. 2 OF 5 SHEETS | STA. TO STA.