


RELOCATE EXISTING LIGHT POLE WITH LUMINAIRE (TYP - SEE LIGHTING PLANS)
 WAUKEGAN ROAD (IL-43) STA 217+80.79
 JEFFERSON AVENUE STA 20+00

WAUKEGAN ROAD (IL-43)

AMMER ROAD

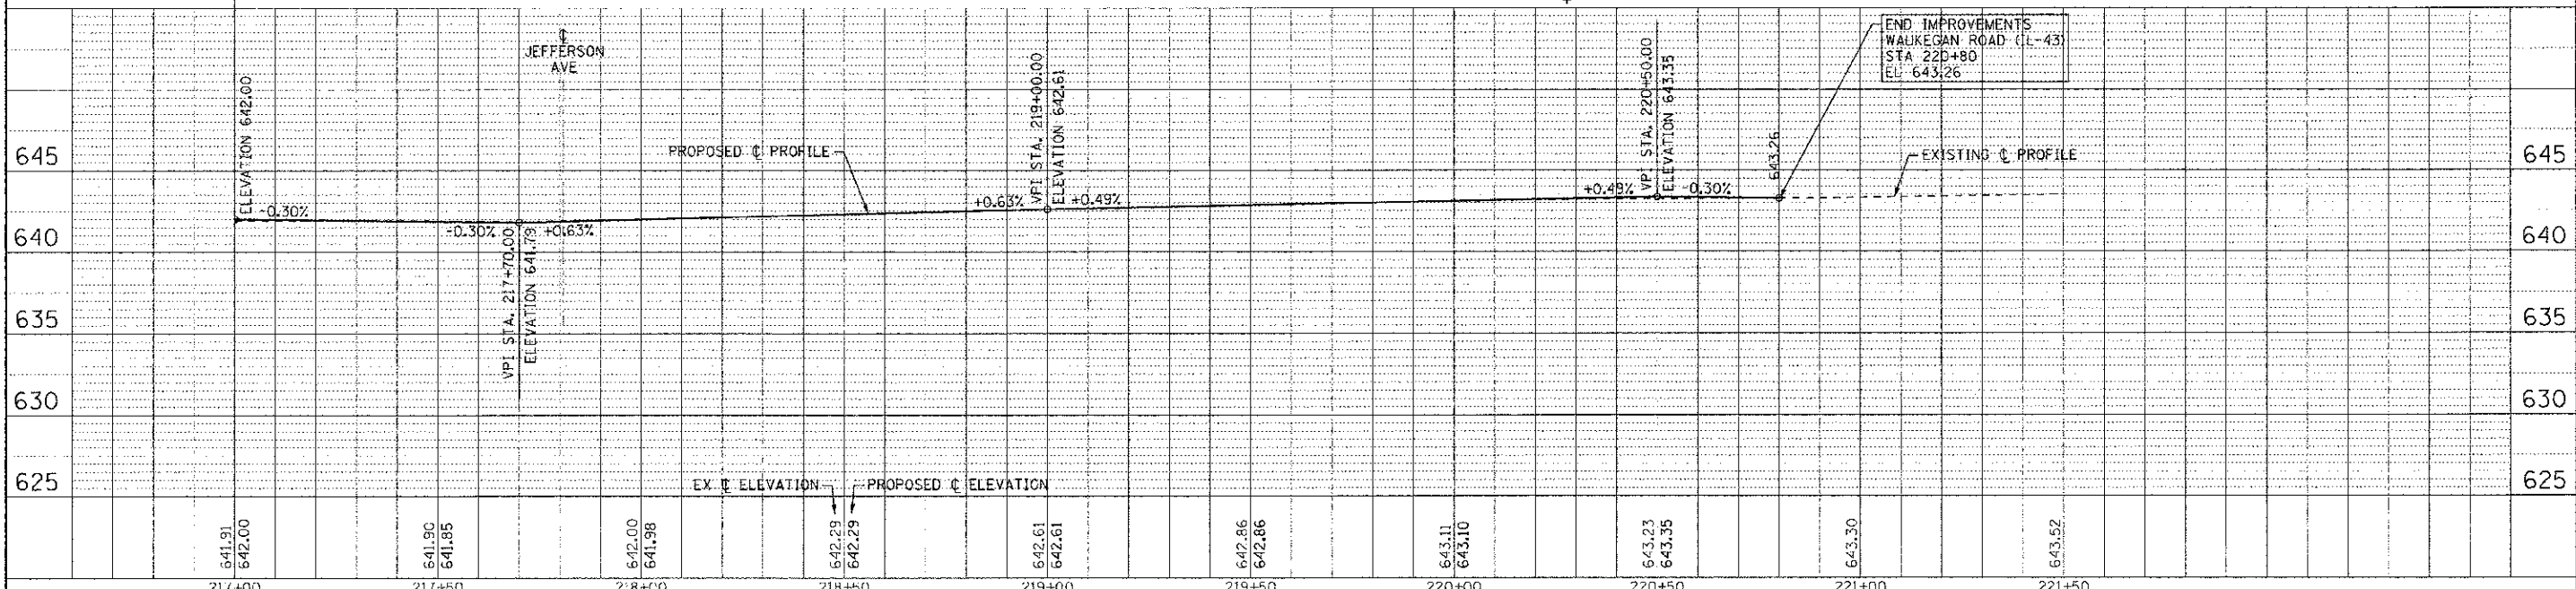

DESIGNED - DSH	REVISED - 10-12-12 PER IDOT
DRAWN - MAC	REVISED
CHECKED - TLH	REVISED
DATE - 8/23/12	FILE - 110025-12-PP4.6h+1

217+00	217+50	218+00	218+50	219+00	219+50	220+00	220+50	221+00	221+50
641.91 642.00	641.90 641.85	642.00 641.98	642.29 642.29	642.61 642.61	642.86 642.86	643.11 643.10	643.23 643.35	643.30	643.52

GEOMETRIC PLAN AND PROFILE
WAUKEGAN ROAD (IL-43)

SCALE: H: 1"=20' V: 1"=5'

STA. 217+00 TO STA. 221+00

F.A.P./F.A.U. FILE	SECTION	COUNTY	TOTAL SHEETS	SHEET NO.
0348/1352	05 00160 00 CH	COOK	109	24
C-91-070-06		CONTRACT NO. 63756		
FED. ROAD DIST. NO. 1 ILLINOIS		FED. AID PROJECT F-03481351		

COPYRIGHT © 2012 BY BAKER & WOODMAN, INC.
 STATE OF ILLINOIS PROFESSIONAL ENGINEERING FIRM
 LICENSE NO. 034-00177 - EMPLOYEES 4300/PAL
 ADDRESS: 1000 W. MONROE STREET, SUITE 200, CHICAGO, IL 60606-4000
 TEL: 312.467.1000 FAX: 312.467.1001