


NOTE: PLAN OMISSION
STA 10+00 TO STA 17+00 (RAMP C)

 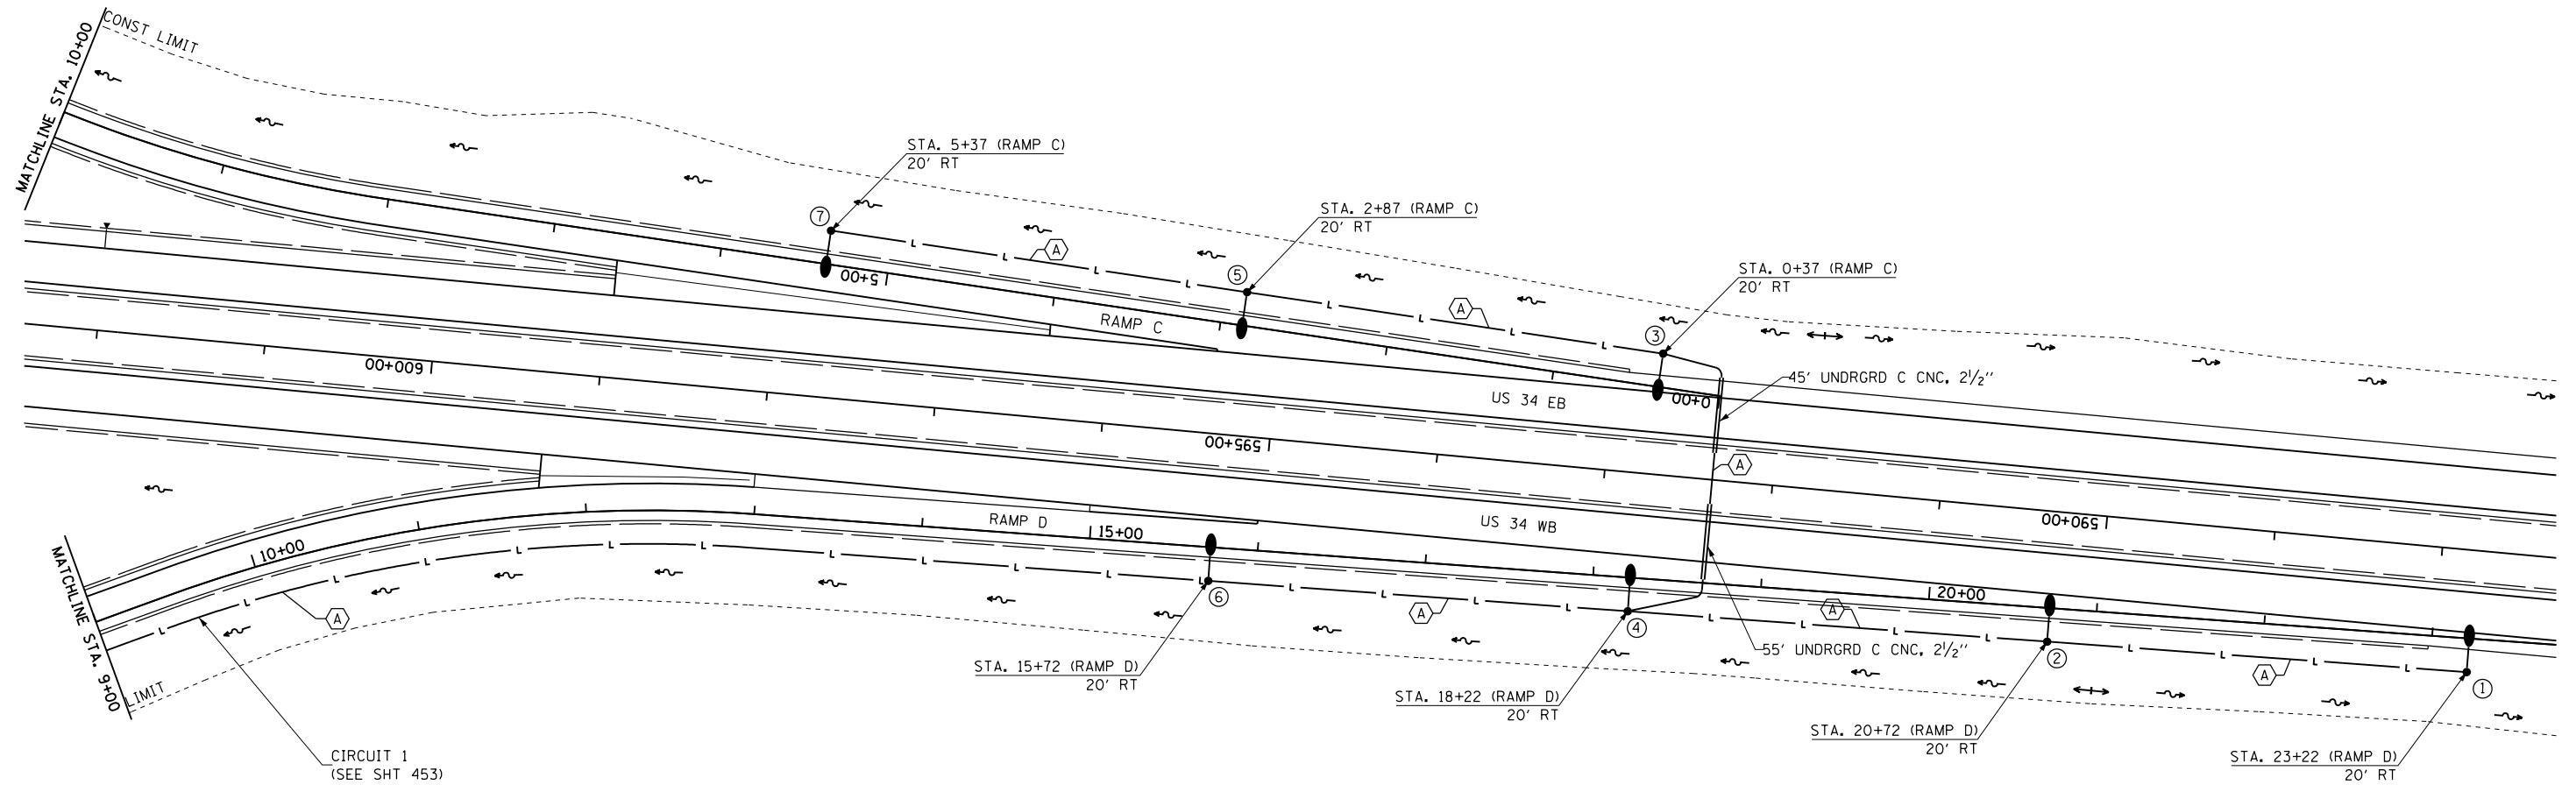


CIRCUIT 1
(SEE SHT 453)

CIRCUIT 1 (A) OMISSION RAMP D
STA. 5+00.00 TO STA. 9+00.00
SEE SHEET 448

LEGEND

- ELECTRIC SERVICE INSTALLATION, 240/480 VOLT, 1 PHASE, 4 WIRE
- LIGHTING CONTROLLER, BASE MOUNTED, 480 VOLT, 100 AMP
- LIGHT POLE, ALUMINUM, 50' M.H., 15' DAVIT ARM
400 WATT HORIZ. MOUNT LUMINAIRE, WITH TRANSFORMER BASE
- LIGHT POLE, ALUMINUM, 45' M.H., 10' DAVIT ARM
400 WATT HORIZ. MOUNT LUMINAIRE, MOUNTED TO PARAPET WALL
- UNDERGROUND CONDUIT, COILABLE NON-METALLIC CONDUIT,
2 1/2" DIA., SCHEDULE 80, UNLESS NOTED OTHERWISE
- JUNCTION BOX, STAINLESS STEEL, ATTACHED TO STRUCTURE,
12" X 10" X 6"
- UNIT DUCT, SIZE AS INDICATED (SEE BELOW)
- UNIT DUCT, 600 V, 2-1C NO. 8, 1/C NO. 8 GROUND,
(XLP-TYPE USE), 3/4" DIA. POLYETHYLENE
- UNIT DUCT, 600 V, 2-1C NO. 10, 1/C NO. 10 GROUND,
(XLP-TYPE USE), 3/4" DIA. POLYETHYLENE



FILE NAME = D468409-PLAN-LIGHTING-RAMPD-SHT1.dgn	USER NAME = danw	DESIGNED - DBS	REVISED -
		DRAWN - PSBA	REVISED -
	PLOT SCALE = 100.0000' / 1" =	CHECKED - CSB	REVISED -
	PLOT DATE = 11/12/2012	DATE - 10/2012	REVISED -

STATE OF ILLINOIS
DEPARTMENT OF TRANSPORTATION

LIGHTING PLAN
RAMP C & RAMP D

SCALE: 1" = 50' SHEET NO. 4 OF 6 SHEETS STA. TO STA.

F.A.P. RTE.	SECTION	COUNTY	TOTAL SHEETS	SHEET NO.
313	7-2 ; 6-1	HENDERSON	976	451
CONTRACT NO. 68409				
ILLINOIS FED. AID PROJECT				