


F.A.P. RTE.	SECTION	COUNTY	TOTAL SHEETS	SHEET NO.
328	5R, Y, RS-1	CLAY	242	30
STA.		TO STA.		
FED. ROAD DIST. NO. 7		ILLINOIS FED. AID PROJECT		
CONTRACT NO. 74078				

STAGE 1-A (PHASE 3)


- PAVEMENT PATCH
- IMPACT ATTENUATORS, TEMPORARY (NON-REDIRECTIVE), TEST LEVEL 2

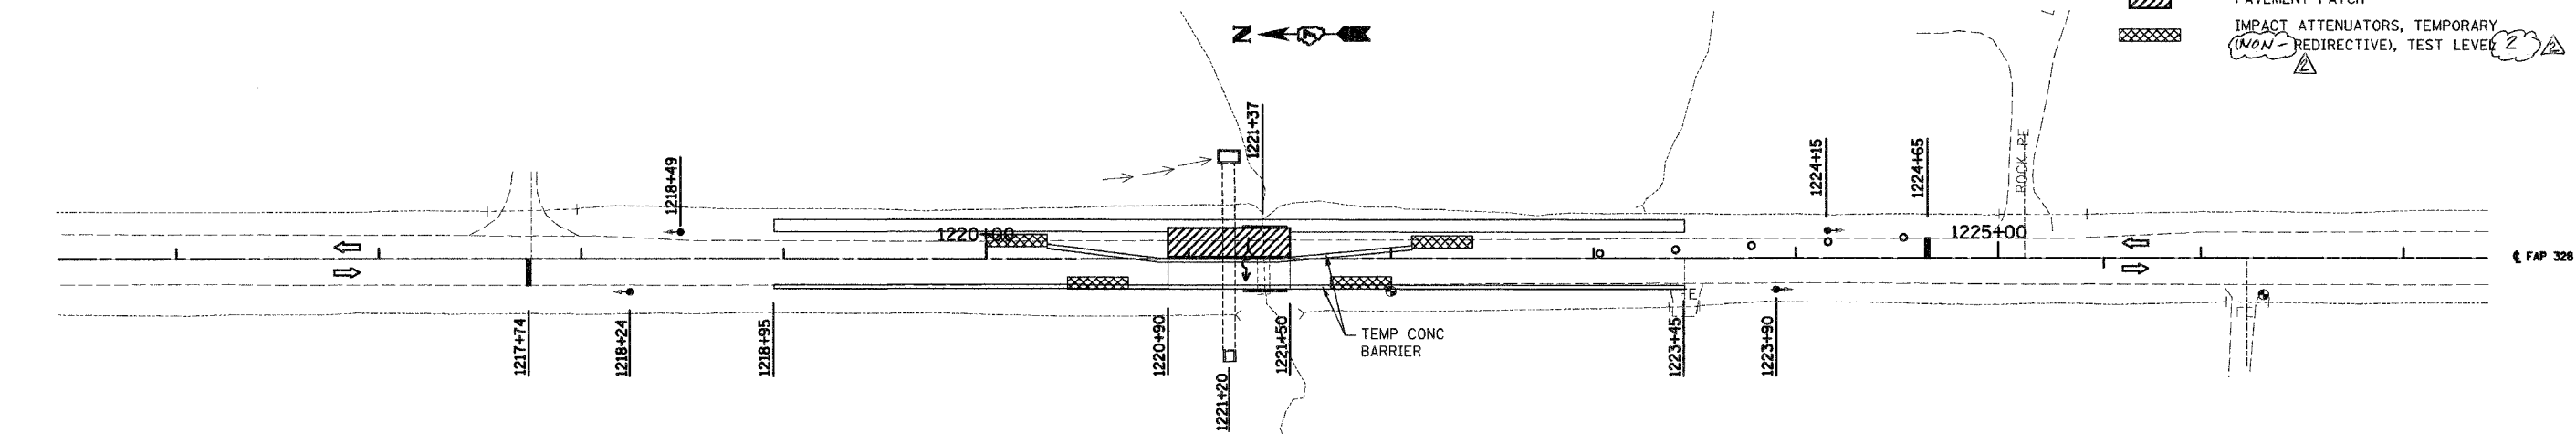

NOTE:
ALL TRAFFIC CONTROL SHALL BE IN ACCORDANCE WITH STANDARD 701321.

- SUGGESTED SEQUENCE OF OPERATIONS**
- REMOVE EXISTING CULVERT ON EAST SIDE TO 1'-0" WEST OF CENTERLINE.
 - * DRIVE SHEET PILING WHERE BOX CULVERT WAS REMOVED.
 - CONSTRUCT ROADWAY EAST OF CENTERLINE.
 - SWITCH TRAFFIC TO EAST SIDE.
 - REMOVE REMAINDER OF EXISTING BOX CULVERT ON WEST SIDE OF CENTERLINE.
 - CONSTRUCT ROADWAY WEST OF CENTERLINE.
 - ANY CHANGES TO STAGING SHALL BE APPROVED BY THE ENGINEER.

* CONTINUE TEMP SHEET PILE ALIGNMENT USING A PILE TIP EL. OF 457.38

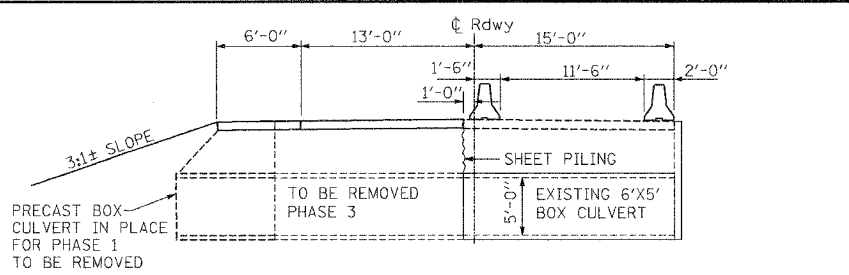

PAVEMENT PATCHING, TYPE IV, 10 INCH
RT 1220+90 TO RT 1221+50 120 SQ YD



WORK ZONE PAVEMENT MARKING REMOVAL
CL 1220+71 TO 1221+68 32 SQ FT
RT 1218+95 TO 1223+45 150 SQ FT

STAGE 1-A (PHASE 4)

IMPACT ATTENUATORS, RELOCATE (NON-REDIRECTIVE), TEST LEVEL 2

- CL 1220+30 1 EACH
- CL 1222+10 1 EACH

 TEMPORARY PAVEMENT MARKING - LINE 4"
CL 1220+59 TO 1221+82 123 FT
RT 1218+95 TO 1223+45 450 FT

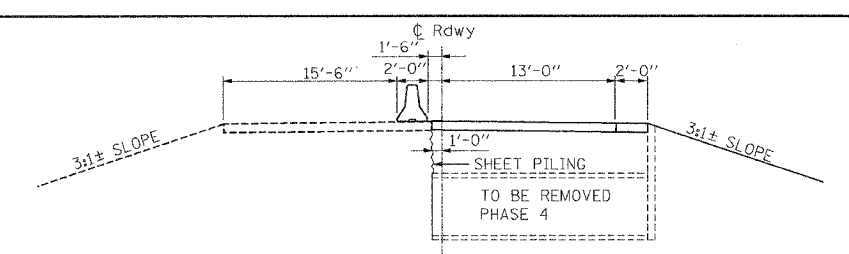

PAVEMENT PATCHING, TYPE IV, 10 INCH
RT 1220+00 TO RT 1222+40 107 SQ YD

RELOCATE TEMPORARY CONCRETE BARRIER (STATE OWNED)
CL 1220+30 TO 1222+10 180 FT

WORK ZONE PAVEMENT MARKING REMOVAL
CL 1220+59 TO 1221+82 41 SQ FT
RT 1218+95 TO 1223+45 150 SQ FT

REVISIONS	
NAME	DATE

ILLINOIS DEPARTMENT OF TRANSPORTATION

STAGE 1 CONSTRUCTION BOX CULVERT REMOVAL STA 1221 + 37

SCALE: VERT. HORIZ. DATE: 10-21-05

DRAWN BY: UJ CHECKED BY: MAR

Rev. 1-9-05

Rev.