


STAGE 1-A (PHASE 3)

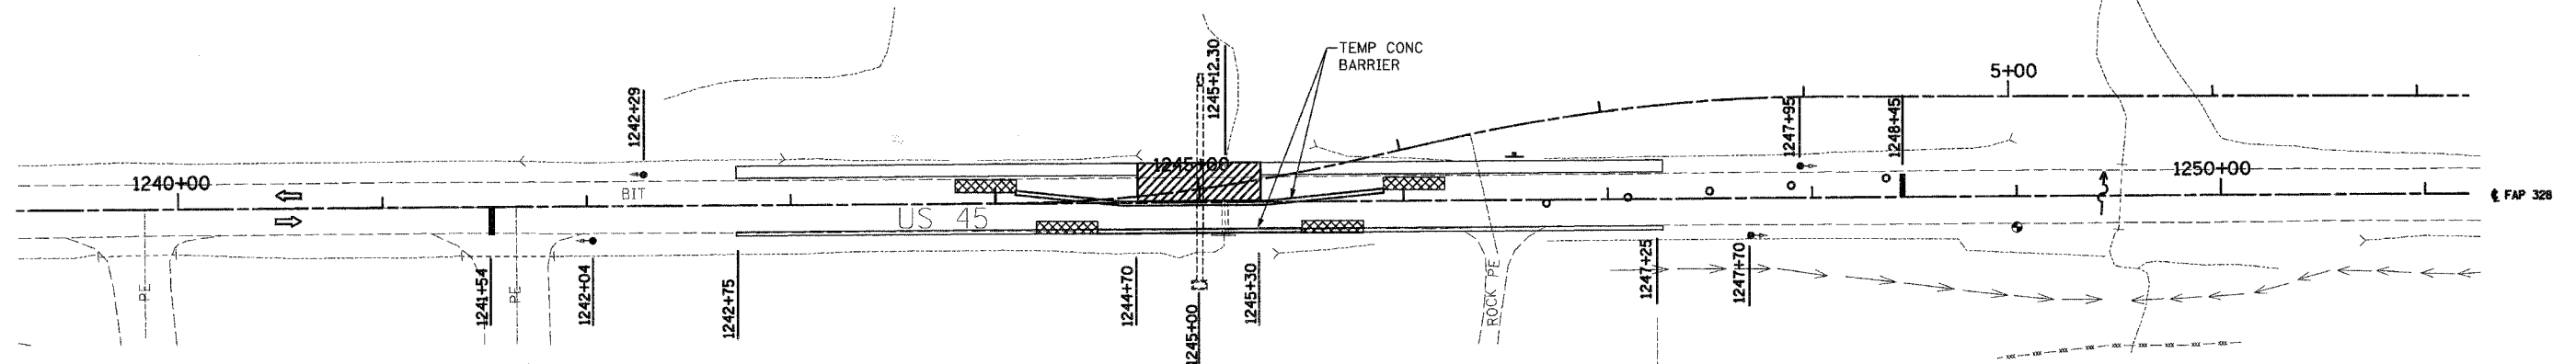

PAVEMENT PATCH
IMPACT ATTENUATORS, TEMPORARY
(NON-REDIRECTIVE), TEST LEVEL 2

F.A.P. RTE.	SECTION	COUNTY	TOTAL SHEETS	SHEET NO.
328	5R, Y, RS-1	CLAY	242	32
STA.		TO STA.		
FED. ROAD DIST. NO. 7		ILLINOIS FED. AID PROJECT		
CONTRACT NO. 74078				




NOTE:

ALL TRAFFIC CONTROL SHALL BE IN ACCORDANCE WITH STANDARD 701321.

SUGGESTED SEQUENCE OF OPERATIONS

- REMOVE EXISTING CULVERT ON EAST SIDE TO 1'-0" WEST OF CENTERLINE.
- * DRIVE SHEET PILING WHERE BOX CULVERT WAS REMOVED.
- CONSTRUCT ROADWAY EAST OF CENTERLINE.
- SWITCH TRAFFIC TO EAST SIDE.
- REMOVE REMAINDER OF EXISTING BOX CULVERT ON WEST SIDE OF CENTERLINE.
- CONSTRUCT ROADWAY WEST OF CENTERLINE.
- ANY CHANGES TO STAGING SHALL BE APPROVED BY THE ENGINEER.



* CONTINUE TEMP SHEET PILE ALIGNMENT USING A PILE TIP EL OF 457.38

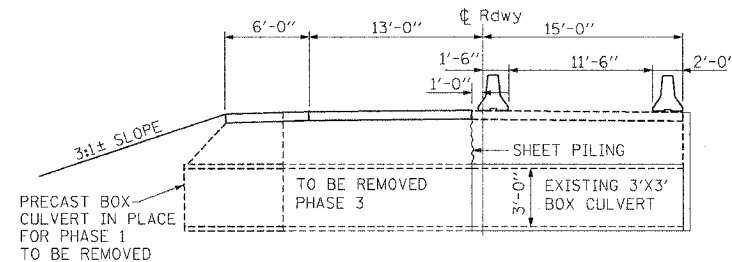

PAVEMENT PATCHING, TYPE IV, 10 INCH
LT 1244+70 TO LT 1245+30 120 SQ YD

WORK ZONE PAVEMENT MARKING REMOVAL
CL 1244+51 TO 1245+48 32 SQ FT
LT 1242+75 TO 1223+45 149 SQ FT

 STAGE 1-A (PHASE 4)

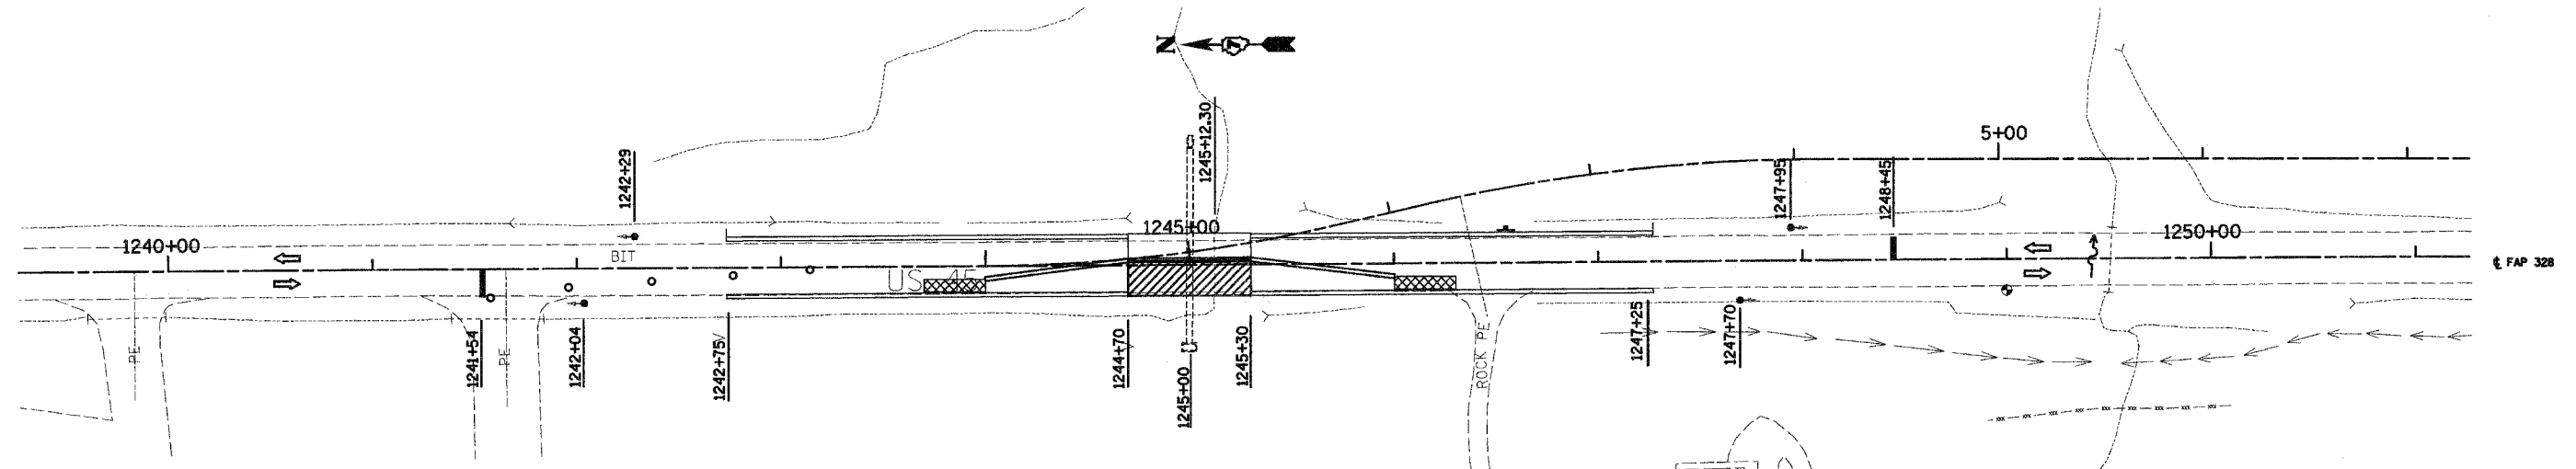

TEMPORARY PAVEMENT MARKING - LINE 4"
CL 1244+39 TO 1245+62 123 FT
RT 1242+75 TO 1247+25 450 FT

IMPACT ATTENUATORS, RELOCATE (NON-REDIRECTIVE), TEST LEVEL 2
CL 1244+00 1 EACH
CL 1146+00 1 EACH

PAVEMENT PATCHING, TYPE IV, 10 INCH
RT 1244+70 TO RT 1245+30 107 SQ YD

RELOCATE TEMPORARY CONCRETE BARRIER (STATE OWNED)
CL 1244+00 TO 1246+00 200 FT

WORK ZONE PAVEMENT MARKING REMOVAL
CL 1244+39 TO 1245+62 41 SQ FT
RT 1242+75 TO 1247+25 150 SQ FT

REVISIONS	
NAME	DATE

ILLINOIS DEPARTMENT OF TRANSPORTATION

**STAGE 1 CONSTRUCTION
BOX CULVERT REMOVAL
STA 1245 + 12.30**

SCALE: VERT.
HORIZ.
DATE: 10-21-05

DRAWN BY: UJ
CHECKED BY: MAR

