



F.A.U.	SECTION	COUNTY	TOTAL SHEETS	SHEET NO.
2832	00-00218-00-PP	COOK	108	50
STA		TO STA		
FED. ROAD DIST. NO. 7 ILLINOIS		FED. AID PROJECT		

CONTRACT NO. 83773

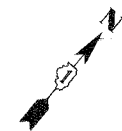

LOAD TABULATIONS FOR LIGHTING CONTROLLER

CIRCUIT	EXISTING		PROPOSED	
	AMPS	WATTS	AMPS	WATTS
C	4.80	1050	4.0	875
D	12.23	2675	13.83	3025
TOTAL	17.03	3725	17.83	3900

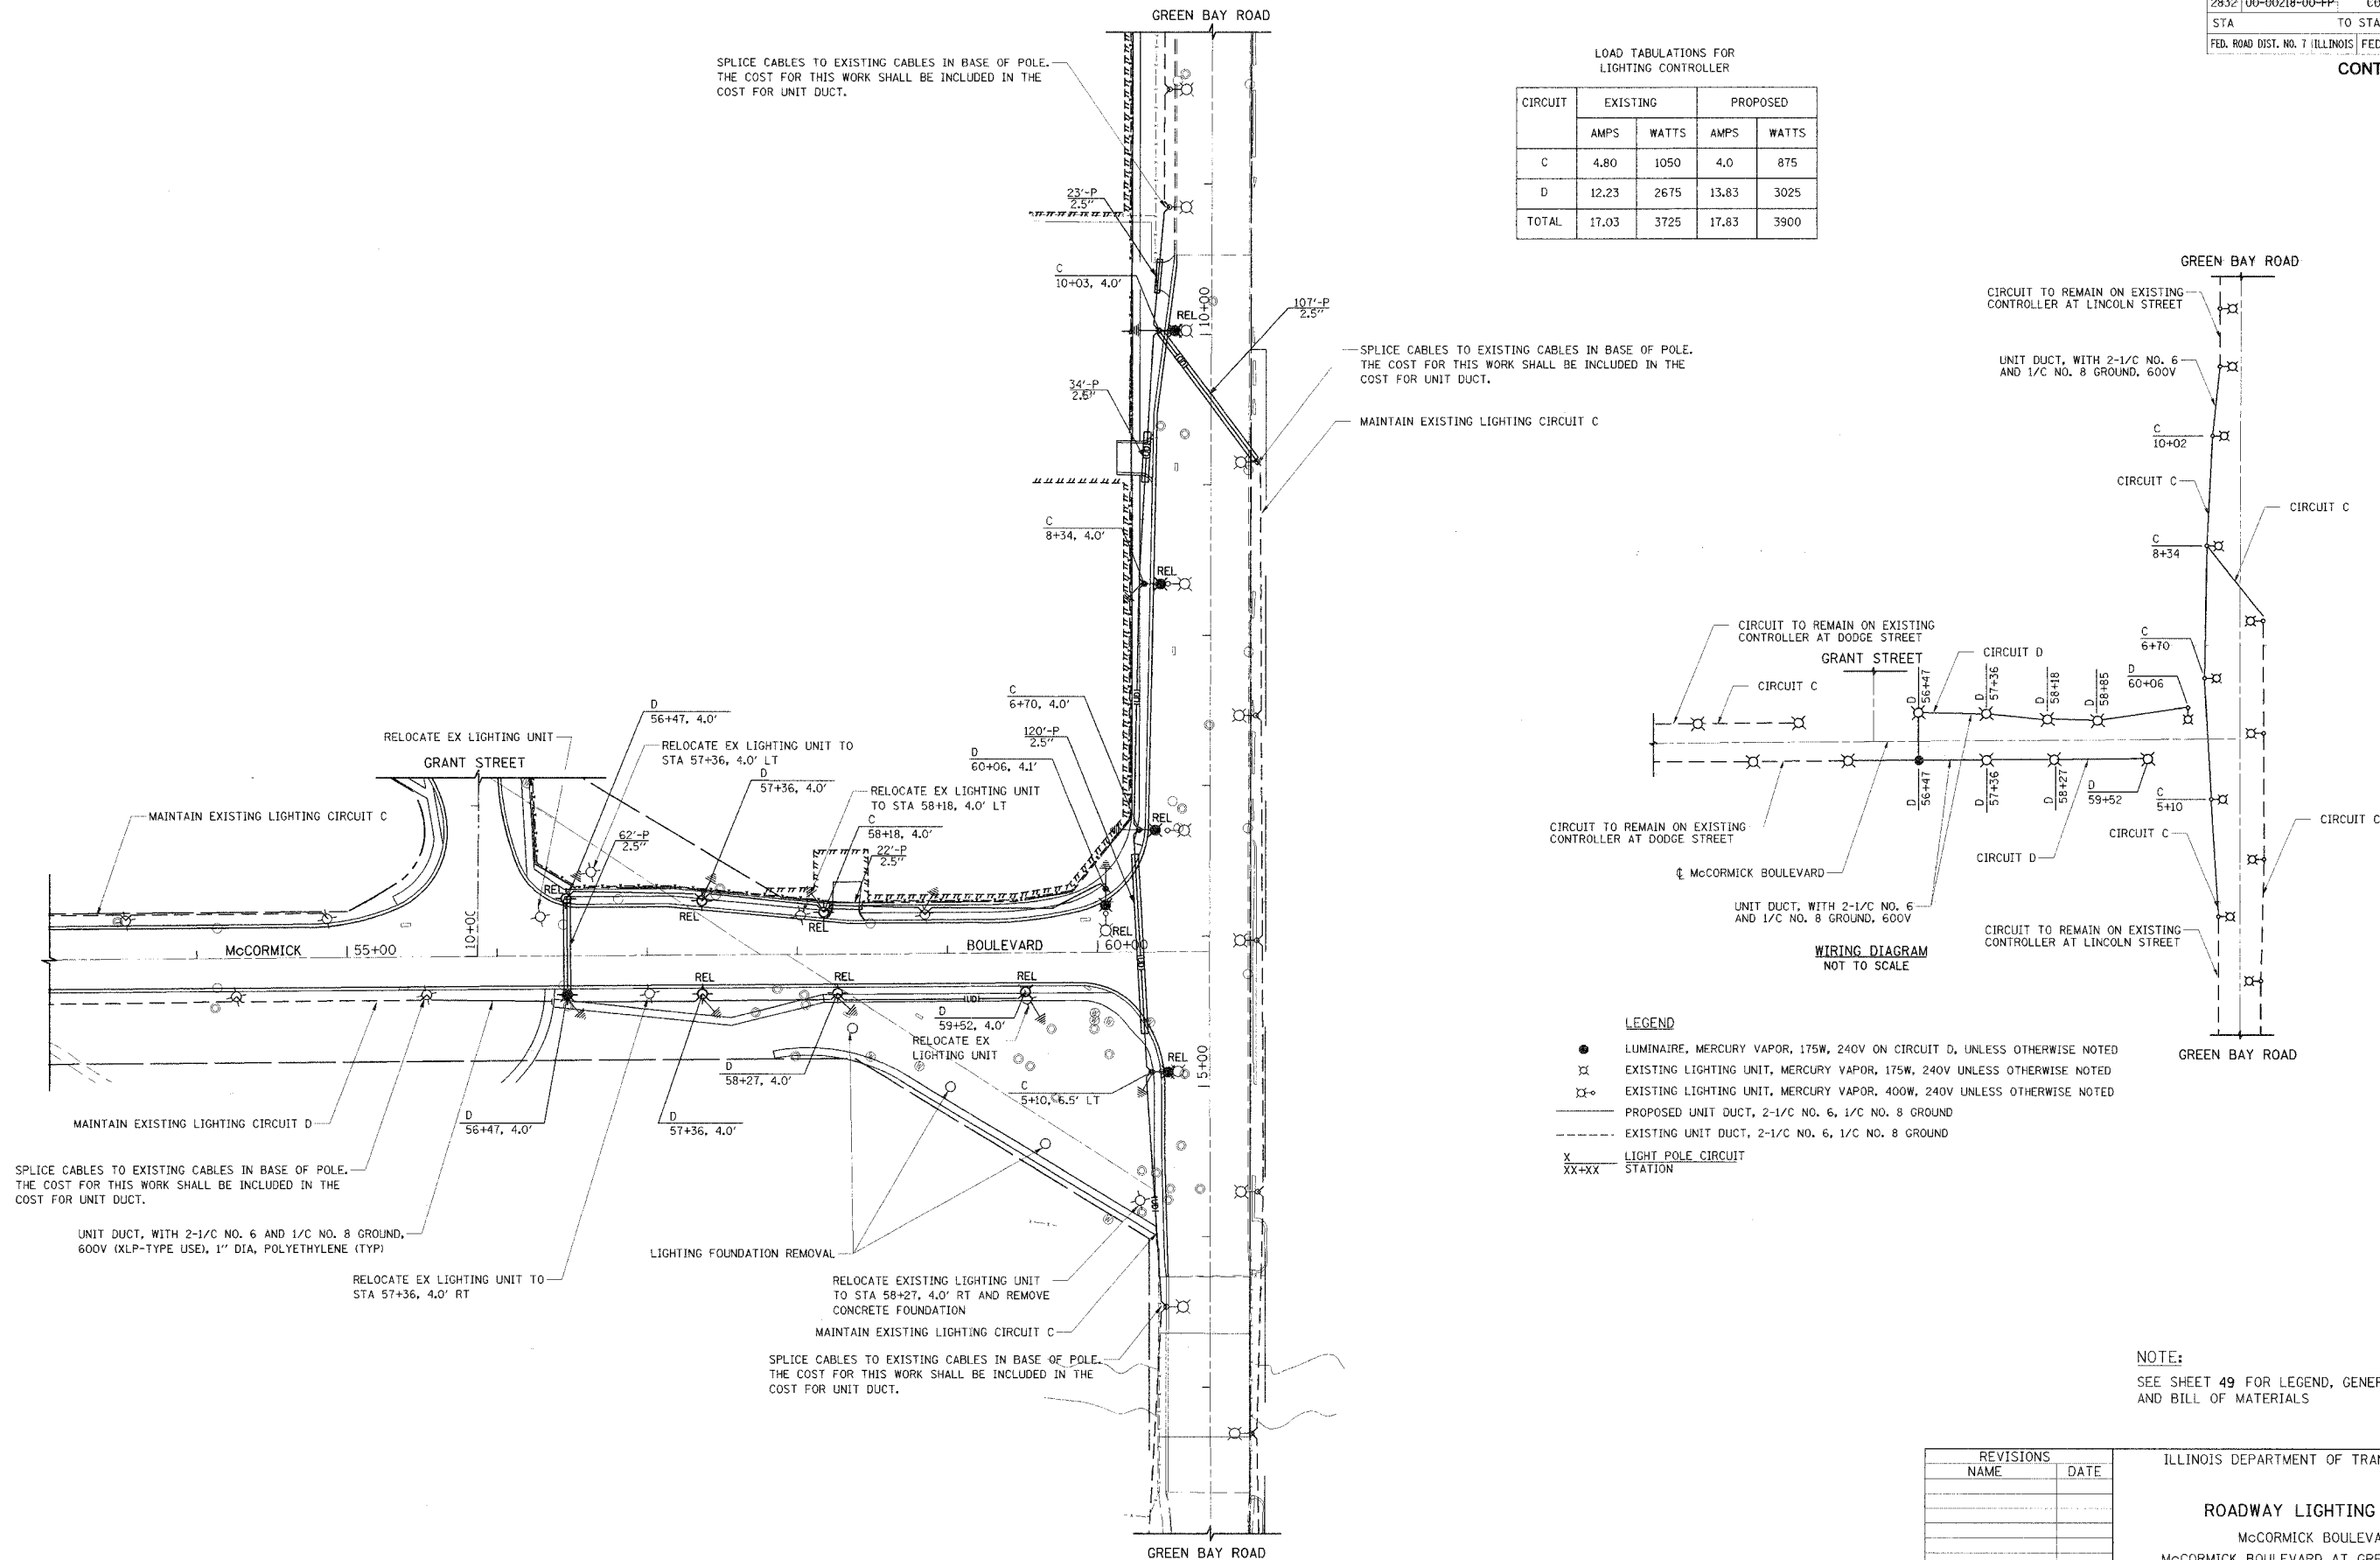

- LEGEND
- LUMINAIRE, MERCURY VAPOR, 175W, 240V ON CIRCUIT D, UNLESS OTHERWISE NOTED
 - ⊗ EXISTING LIGHTING UNIT, MERCURY VAPOR, 175W, 240V UNLESS OTHERWISE NOTED
 - ⊗ EXISTING LIGHTING UNIT, MERCURY VAPOR, 400W, 240V UNLESS OTHERWISE NOTED
 - PROPOSED UNIT DUCT, 2-1/C NO. 6, 1/C NO. 8 GROUND
 - - - EXISTING UNIT DUCT, 2-1/C NO. 6, 1/C NO. 8 GROUND
 - X LIGHT POLE CIRCUIT
 - XX+XX STATION

NOTE:
SEE SHEET 49 FOR LEGEND, GENERAL NOTES,
AND BILL OF MATERIALS

REVISIONS		ILLINOIS DEPARTMENT OF TRANSPORTATION	
NAME	DATE	ROADWAY LIGHTING PLAN	
		McCORMICK BOULEVARD	
		McCORMICK BOULEVARD AT GREEN BAY ROAD	
		<div>0 25' 50'</div> <div>1"=50'</div>	
		DATE 9/03/04 DRAWN BY SRS CHECKED BY SRF	