



| F.A.I. RTE.         | SECTION  | COUNTY   | TOTAL SHEETS     | SHEET NO. |
|---------------------|----------|----------|------------------|-----------|
| 190                 | 0102.1 S | COOK     | 107              | 41        |
| FED. ROAD DIST. NO. |          | ILLINOIS | FED. AID PROJECT |           |

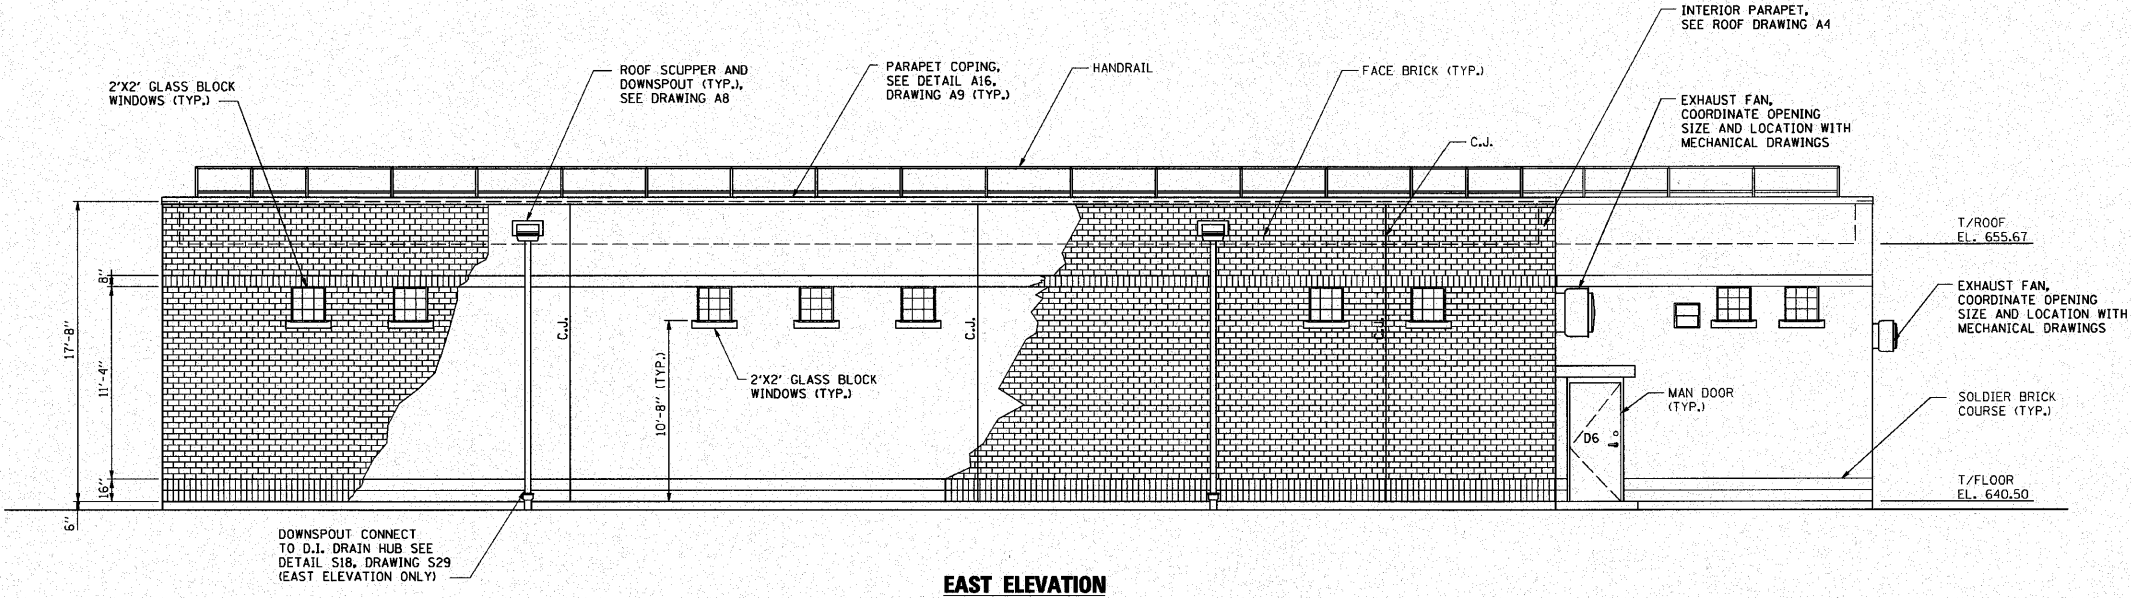

EAST ELEVATION

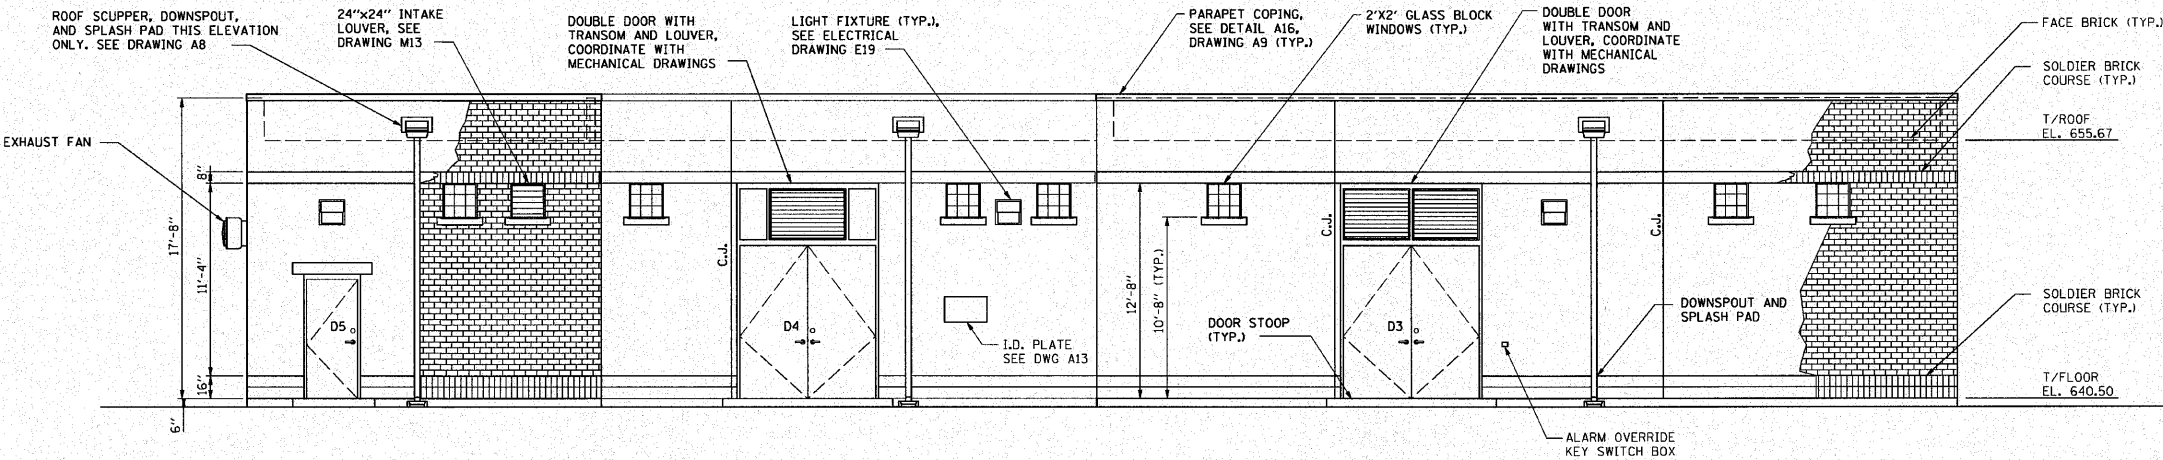

WEST ELEVATION

- NOTE:
1. C.J. = CONTROL JOINT. REFER TO DETAIL A30, DRAWING A10
  2. COORDINATE FINAL HEIGHT AND LOCATION OF MECHANICAL EXHAUST FANS AND LOUVERS WITH MECHANICAL DRAWINGS AND SPECIFICATIONS.
  3. COORDINATE FINAL HEIGHT AND LOCATION OF LIGHT FIXTURES WITH ELECTRICAL DRAWINGS AND SPECIFICATIONS.



A1

| REVISIONS |      |
|-----------|------|
| NAME      | DATE |
|           |      |
|           |      |
|           |      |
|           |      |
|           |      |
|           |      |

ILLINOIS DEPARTMENT OF TRANSPORTATION

PUMP STATION NO. 24  
RELOCATION

ARCHITECTURAL ELEVATIONS  
EAST AND WEST

SCALE: AS SHOWN

DATE: 11-22-10

DRAWN BY: MW

CHECKED BY: KHC