
 


F.A.I. RTE.	SECTION	COUNTY	TOTAL SHEETS	SHEET NO.
190	0102.1 S	COOK	107	63
FED. ROAD DIST. NO.		ILLINOIS	FED. AID PROJECT	

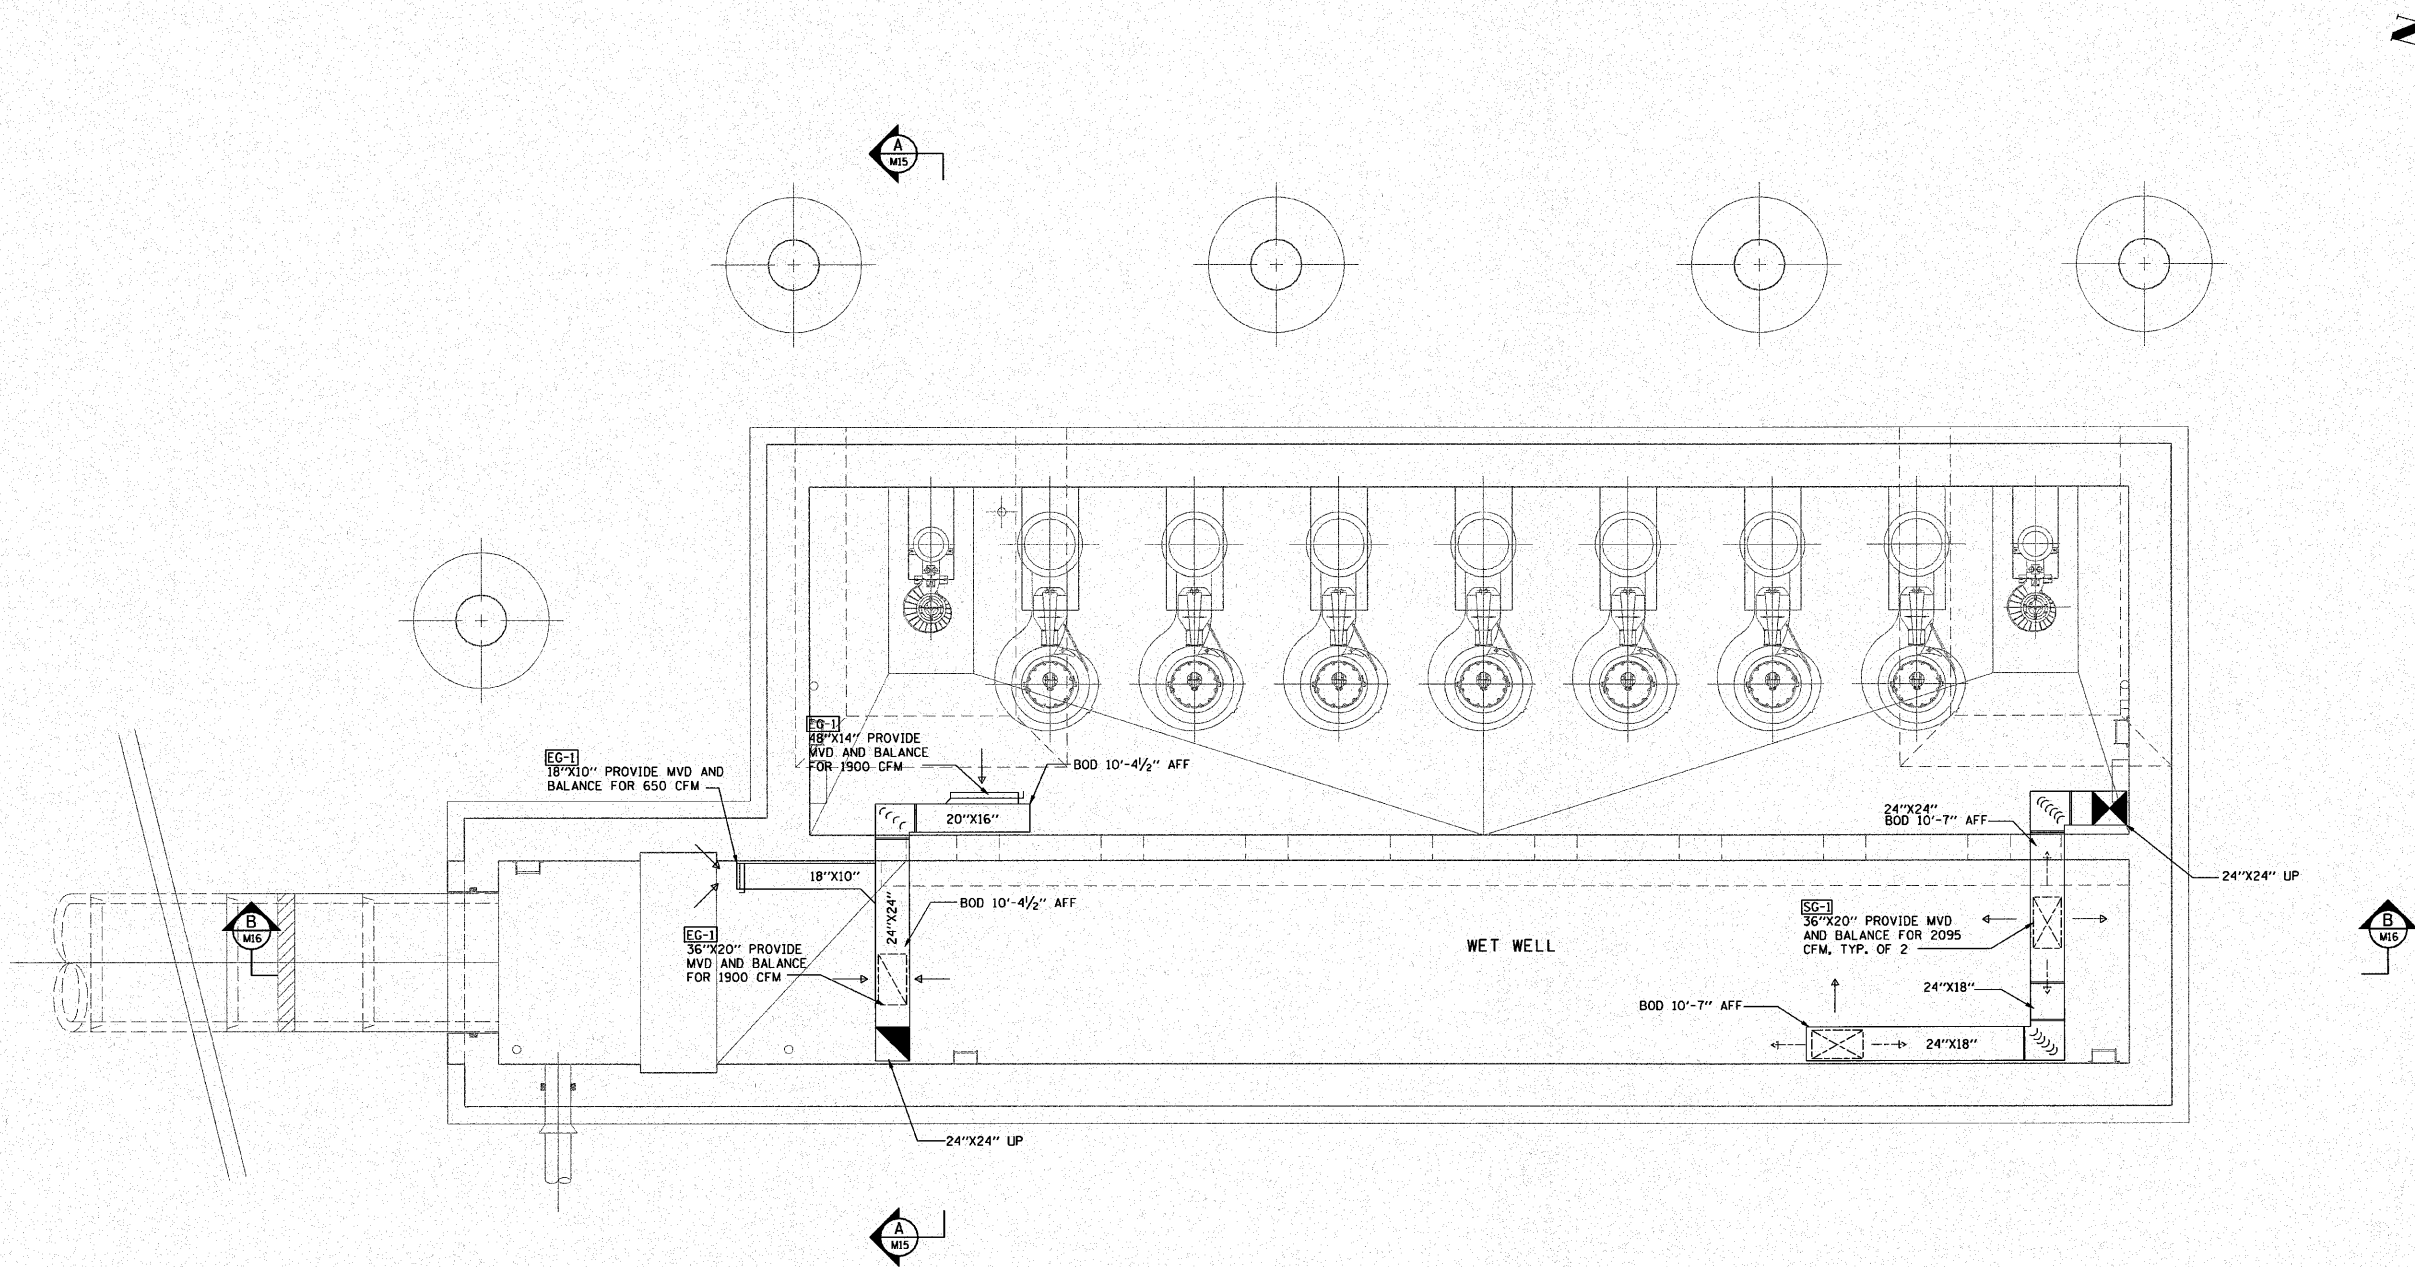

PLAN @ EL. 597.5

- GENERAL NOTE:
- ALL ROOMS EXCEPT ELECTRICAL ROOM SHALL BE CLASS 1, DIVISION 1, GROUP D EXPLOSION PROOF.
 - COORDINATE DUCTWORK ROUTING WITH CABLE TRAY SEE E15.



M10

REVISIONS	
NAME	DATE

ILLINOIS DEPARTMENT OF TRANSPORTATION

PUMP STATION NO. 24
RELOCATION

HVAC PLAN

SCALE: AS SHOWN
DATE: 11-22-10

DRAWN BY: MJH
CHECKED BY: KHC