


F.A.I. RTE.	SECTION	COUNTY	TOTAL SHEETS	SHEET NO.
190	0102.1 S	COOK	107	65
FED. ROAD DIST. NO.		ILLINOIS	FED. AID PROJECT	

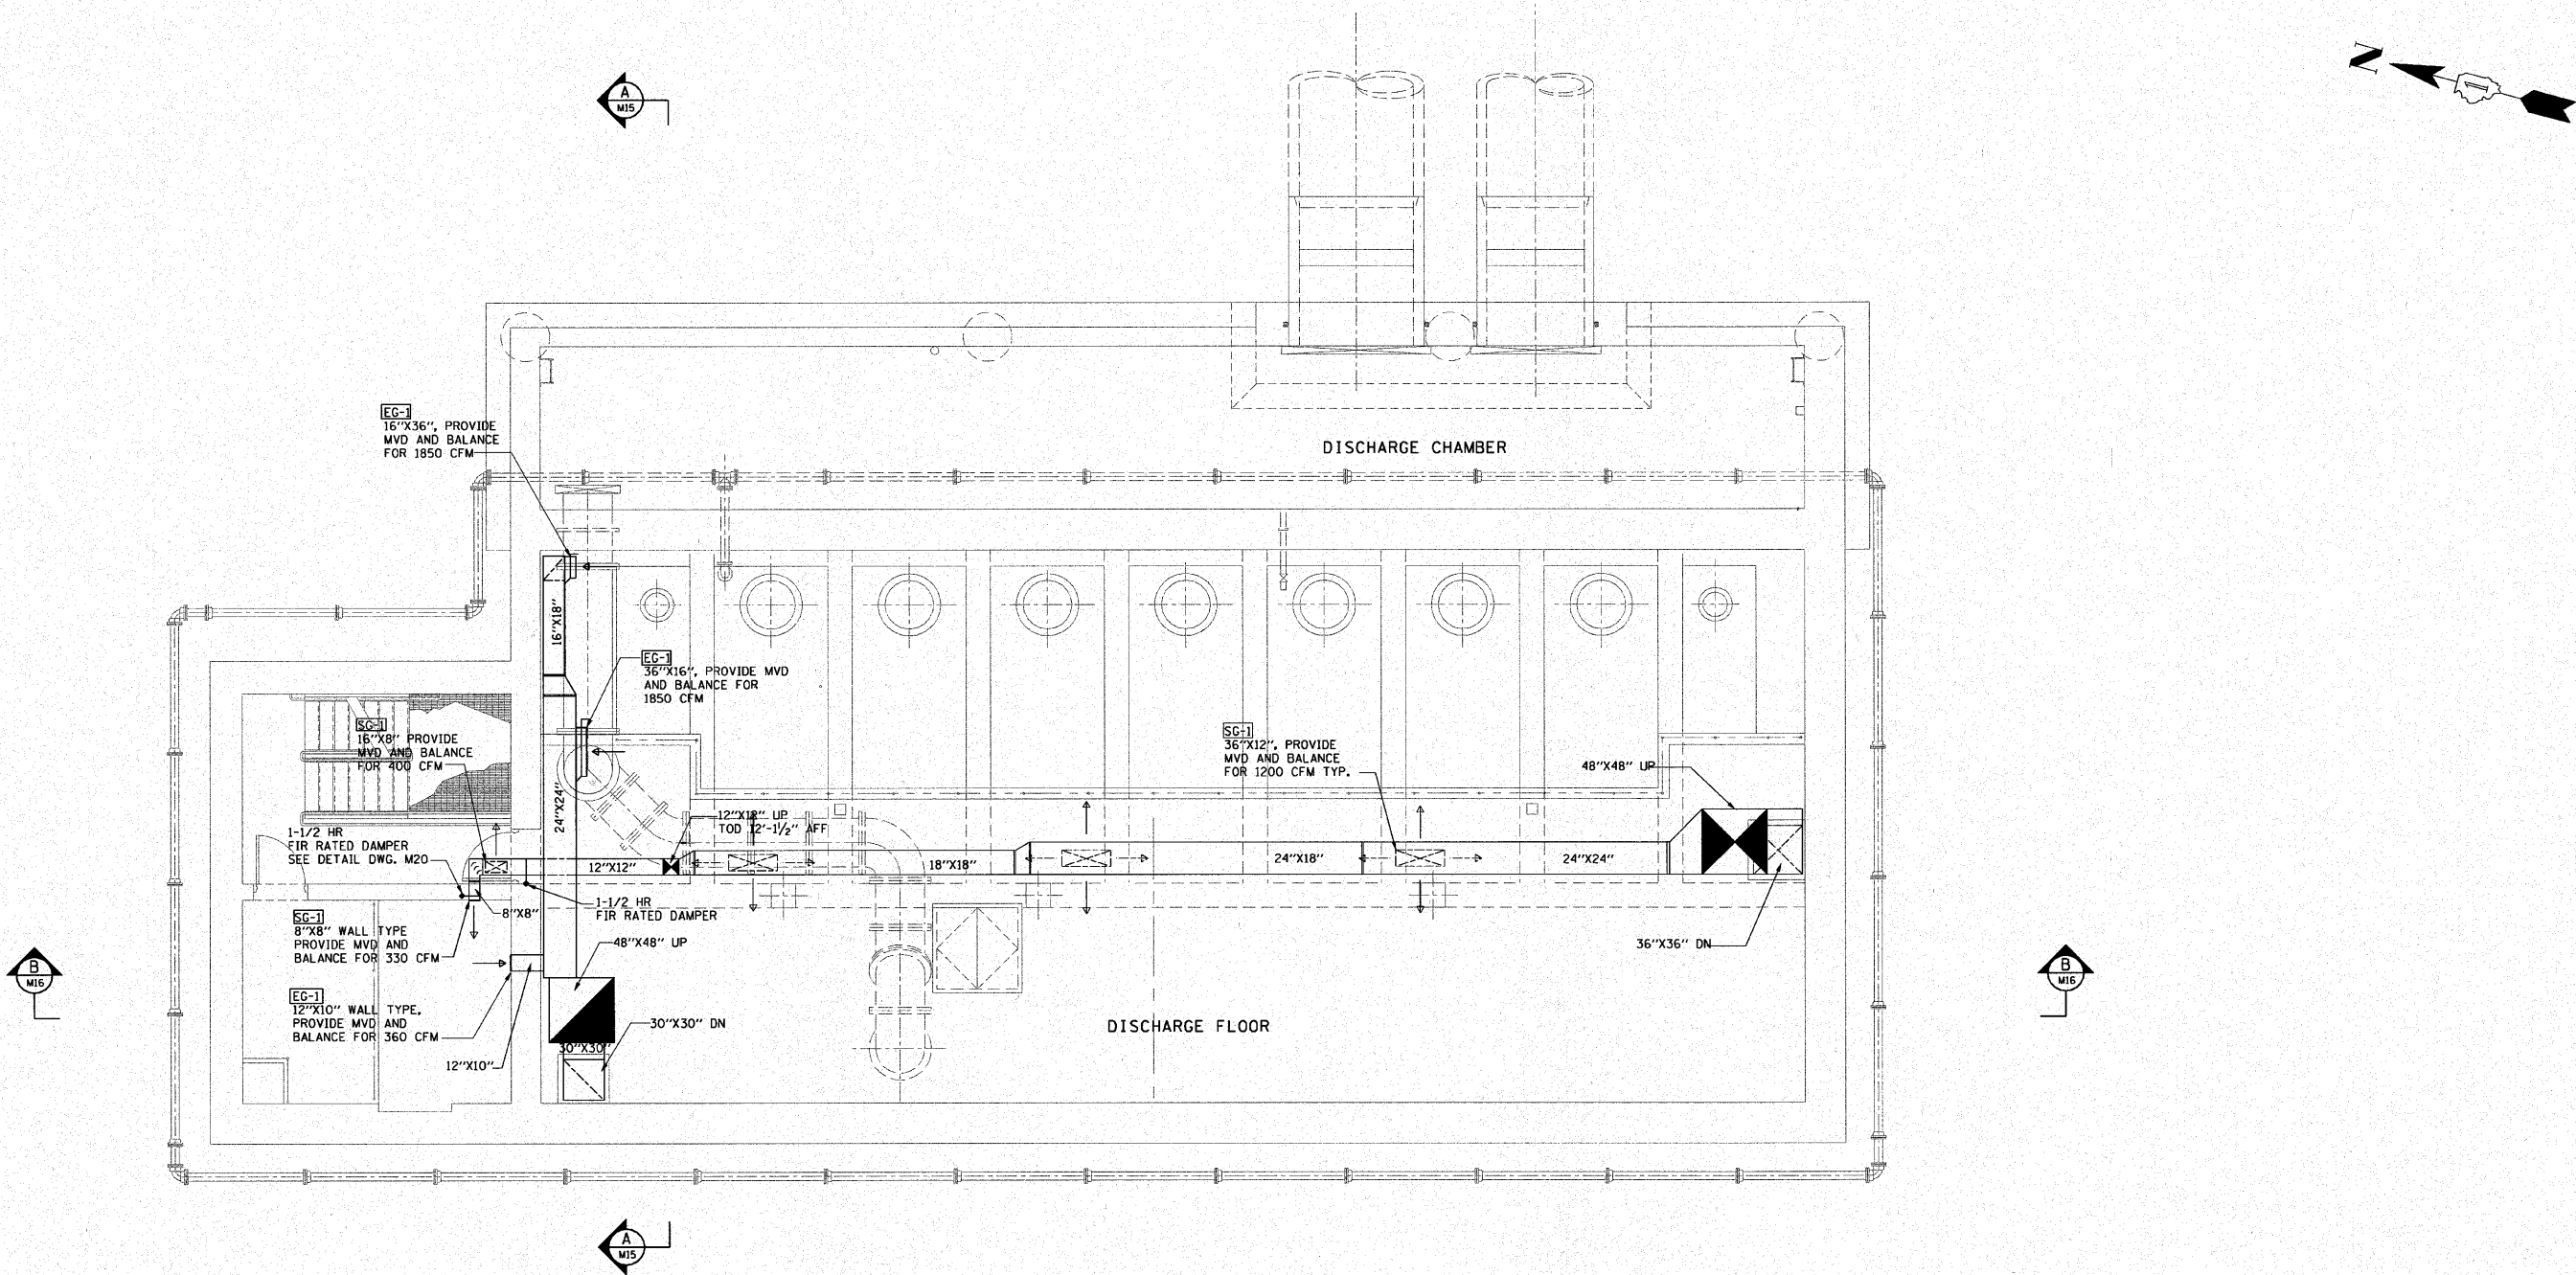

PLAN @ EL. 627.00

NOTE:
ALL ROOMS EXCEPT ELECTRICAL ROOM SHALL BE CLASS 1,
DIVISION 1, GROUP D EXPLOSION PROOF.



SCALE: 0 4 8 12

M12

REVISIONS	
NAME	DATE

ILLINOIS DEPARTMENT OF TRANSPORTATION

PUMP STATION NO. 24
RELOCATION

HVAC PLAN

SCALE: AS SHOWN

DATE: 11-22-10

DRAWN BY: MJH

CHECKED BY: KHC