
 


F.A.I. RTE.	SECTION	COUNTY	TOTAL SHEETS	SHEET NO.
190	0102.1 S	COOK	107	76
FED. ROAD DIST. NO.	ILLINOIS	FED. AID PROJECT		

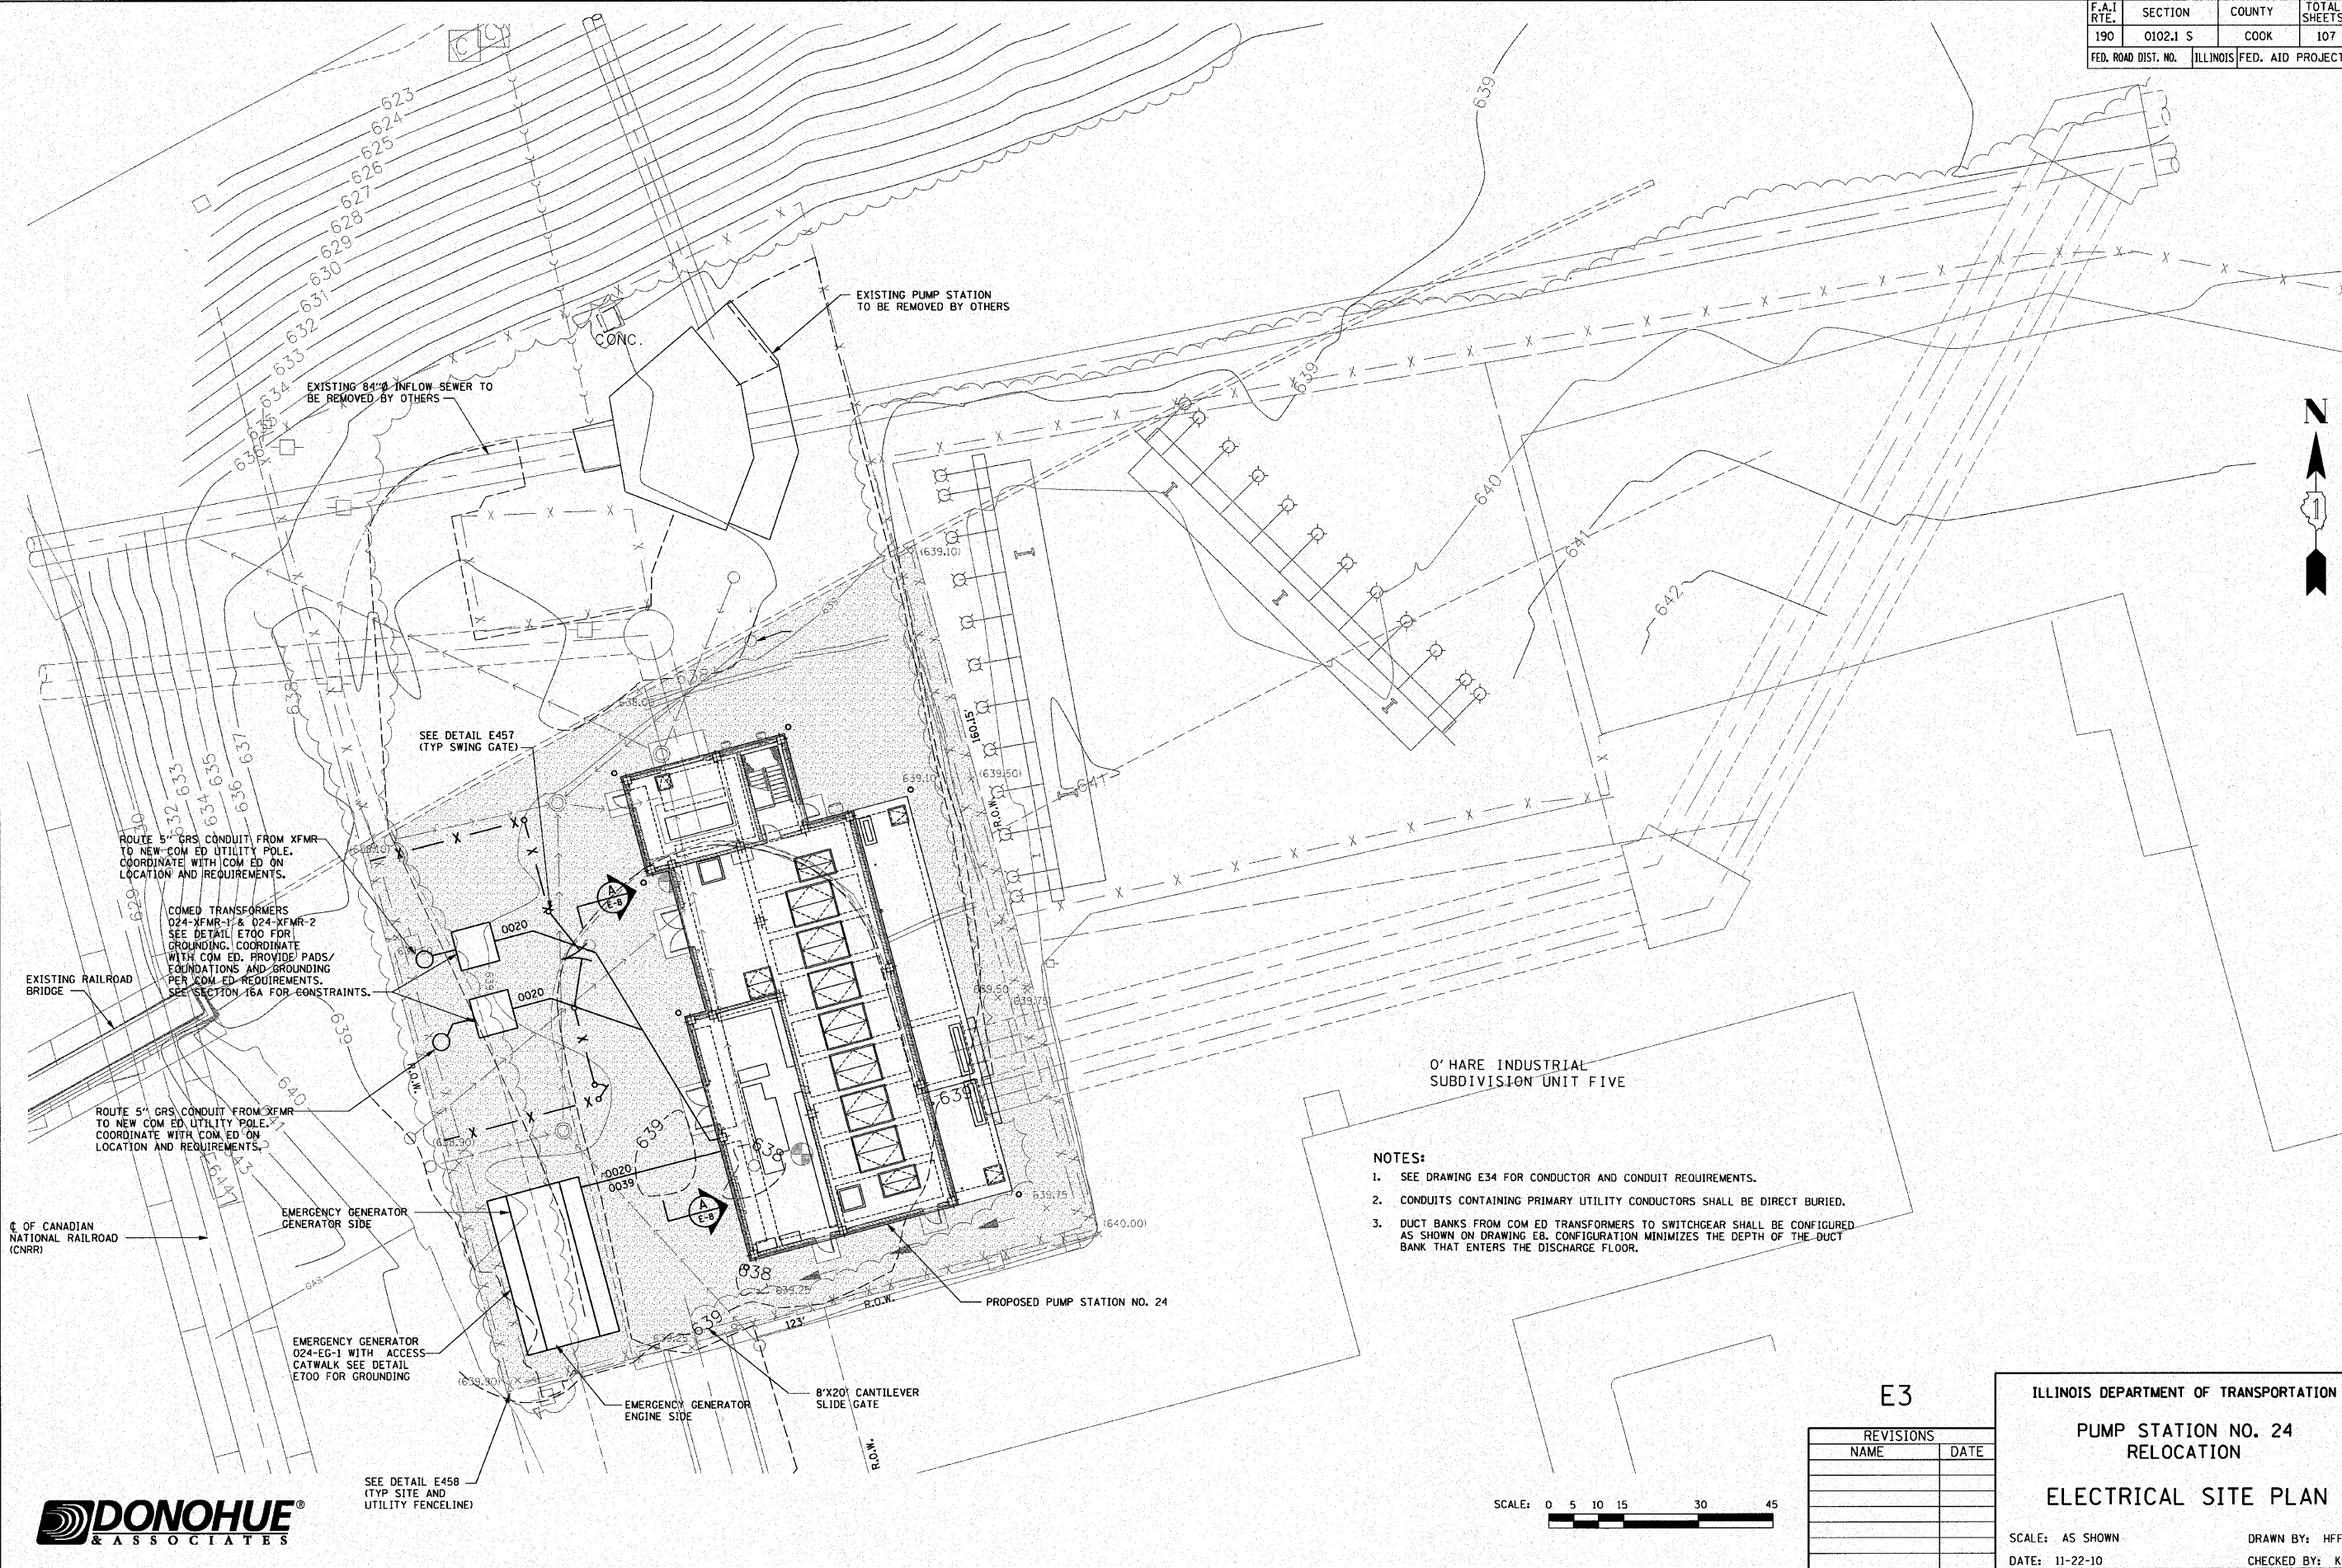

- NOTES:
1. SEE DRAWING E34 FOR CONDUCTOR AND CONDUIT REQUIREMENTS.
 2. CONDUITS CONTAINING PRIMARY UTILITY CONDUCTORS SHALL BE DIRECT BURIED.
 3. DUCT BANKS FROM COM ED TRANSFORMERS TO SWITCHGEAR SHALL BE CONFIGURED AS SHOWN ON DRAWING E8. CONFIGURATION MINIMIZES THE DEPTH OF THE DUCT BANK THAT ENTERS THE DISCHARGE FLOOR.

E3



REVISIONS	
NAME	DATE

ILLINOIS DEPARTMENT OF TRANSPORTATION

PUMP STATION NO. 24
RELOCATION

ELECTRICAL SITE PLAN

SCALE: AS SHOWN

DATE: 11-22-10

DRAWN BY: HFF

CHECKED BY: KHC