
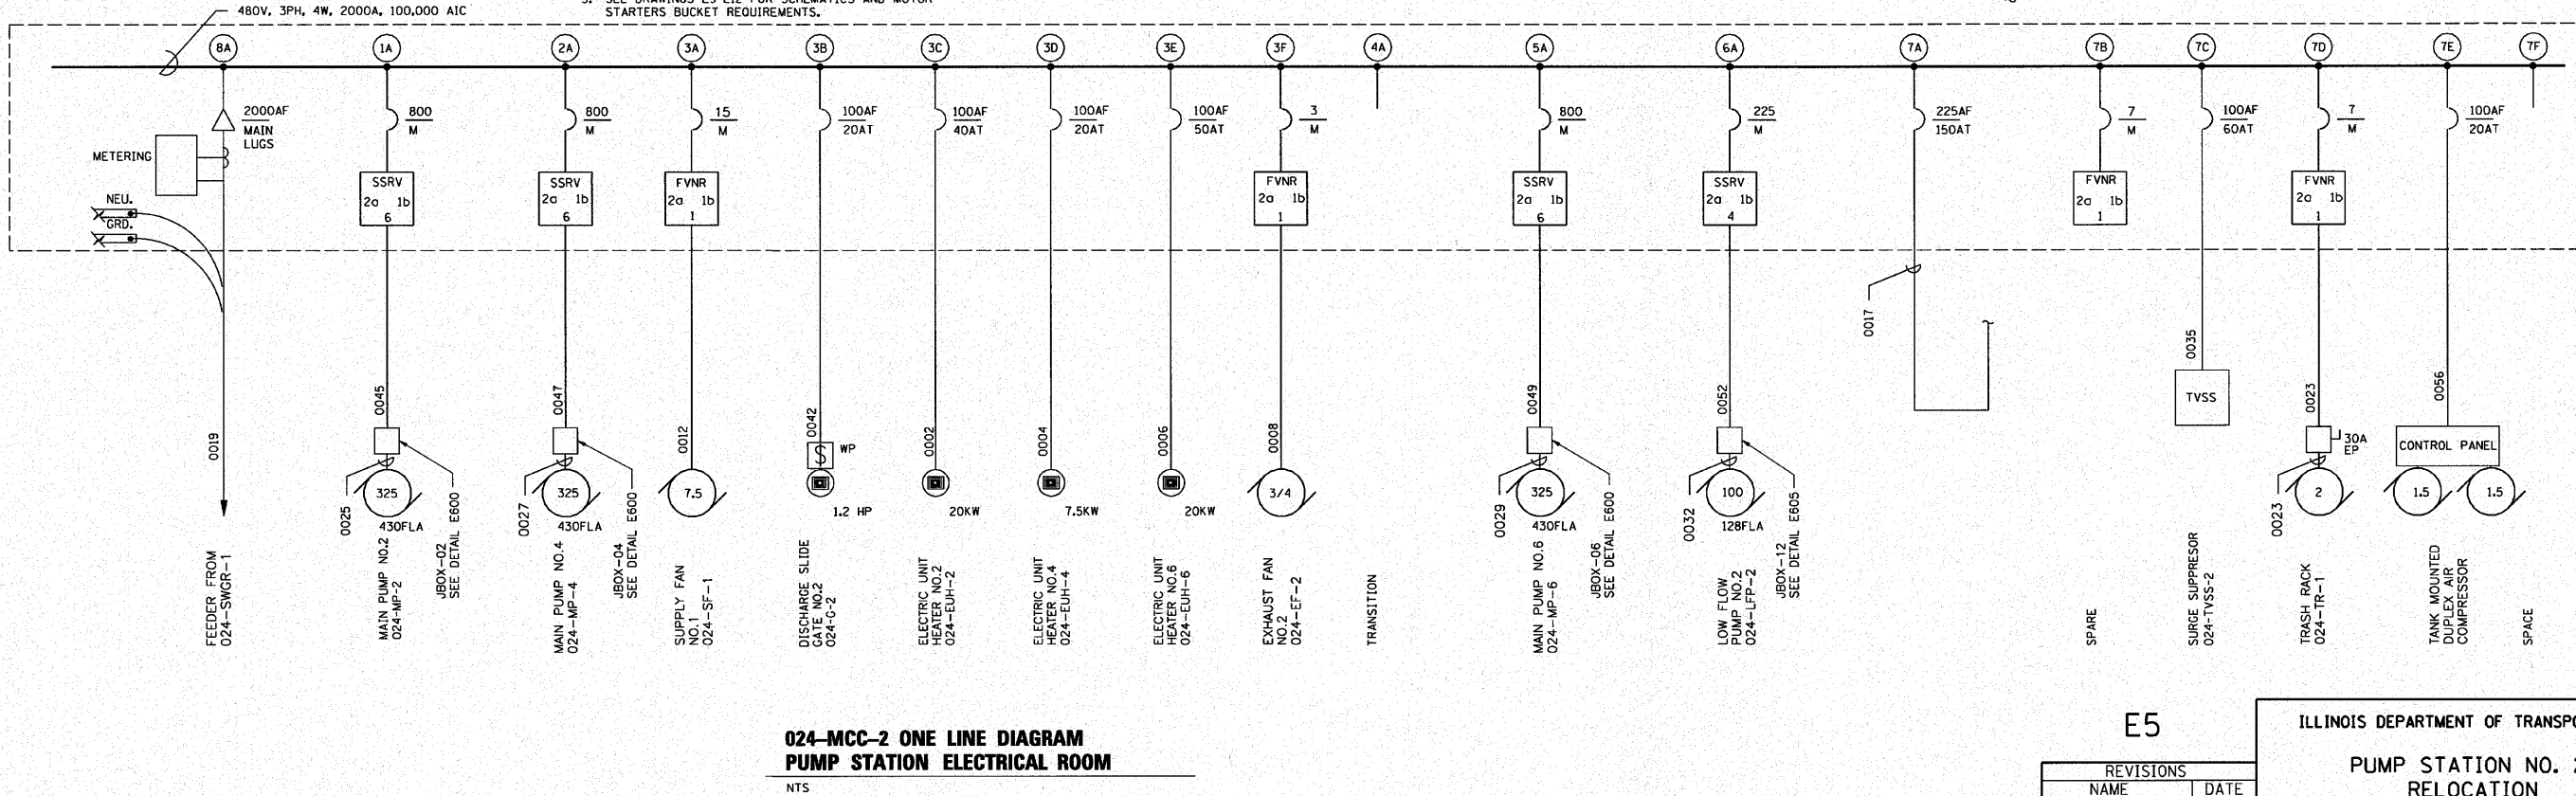


F.A.I. RTE.	SECTION	COUNTY	TOTAL SHEETS	SHEET NO.
190	0102.1 S	COOK	107	78
FED. ROAD DIST. NO.		ILLINOIS	FED. AID PROJECT	

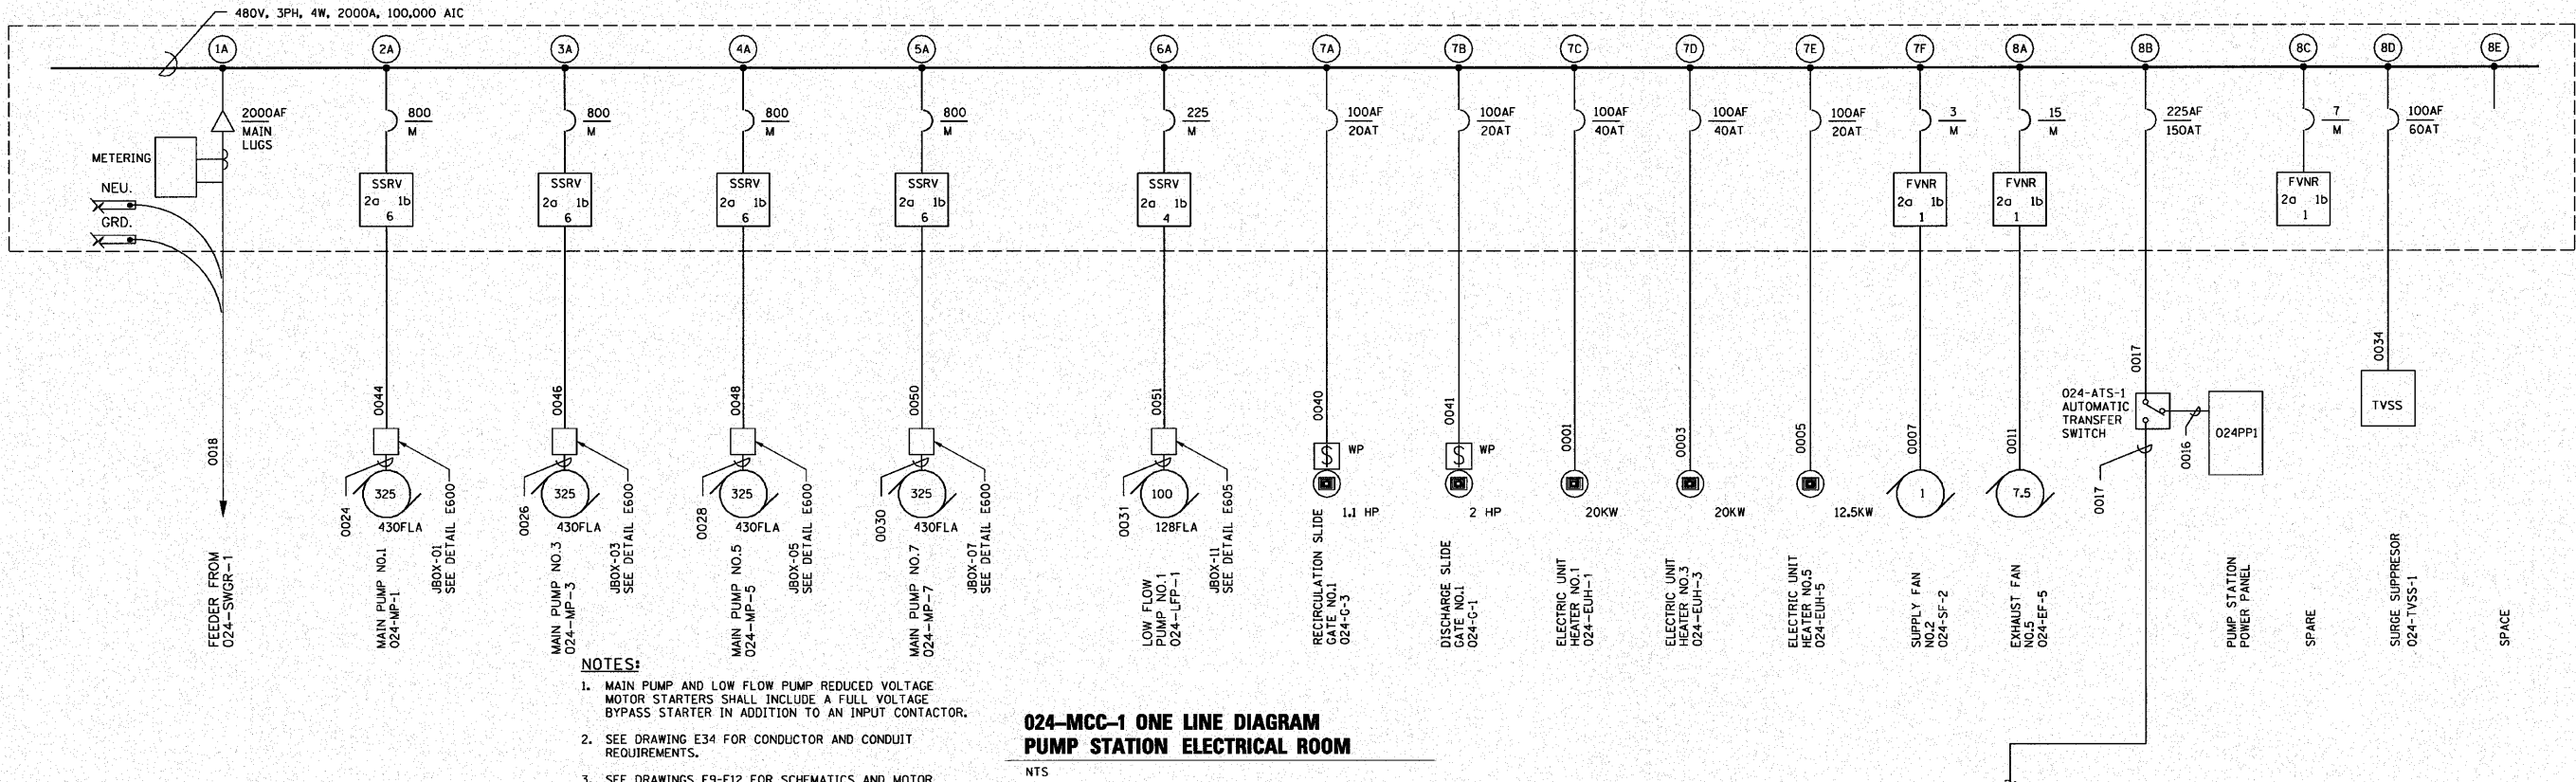

E5

ILLINOIS DEPARTMENT OF TRANSPORTATION
PUMP STATION NO. 24
RELOCATION
MCC ONE LINE DIAGRAMS
SCALE: N/A
DATE: 11-22-10
DRAWN BY: MS
CHECKED BY: MS

REVISIONS	
NAME	DATE