


F.A.I RTE.	SECTION	COUNTY	TOTAL SHEETS	SHEET NO.
190	0102.1 S	COOK	107	81
FED. ROAD DIST. NO.		ILLINOIS	FED. AID PROJECT	

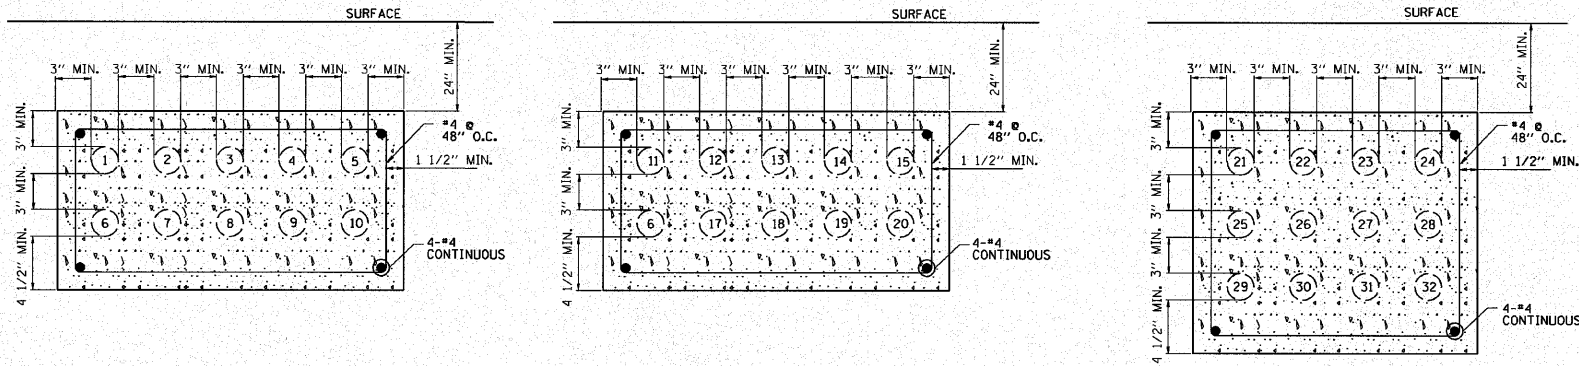

DUCT BANK SECTION A
NTS E3

DUCTBANK SCHEDULE					
NUMBER	SIZE	FROM	TO	CONTENTS	REMARKS
1	4"	UTILITY XFMR 1	024-SWGR-1	POWER	480V
2	4"	UTILITY XFMR 1	024-SWGR-1	POWER	480V
3	4"	UTILITY XFMR 1	024-SWGR-1	POWER	480V
4	4"	UTILITY XFMR 1	024-SWGR-1	POWER	480V
5	4"	UTILITY XFMR 1	024-SWGR-1	POWER	480V
6	4"	UTILITY XFMR 1	024-SWGR-1	POWER	480V
7	4"	UTILITY XFMR 1	024-SWGR-1	POWER	480V
8	4"	UTILITY XFMR 1	024-SWGR-1	POWER	480V
9	4"	UTILITY XFMR 1	024-SWGR-1	POWER	480V
10	4"	UTILITY XFMR 1	024-SWGR-1	SPARE	-
11	4"	UTILITY XFMR 2	024-SWGR-1	POWER	480V
12	4"	UTILITY XFMR 2	024-SWGR-1	POWER	480V
13	4"	UTILITY XFMR 2	024-SWGR-1	POWER	480V
14	4"	UTILITY XFMR 2	024-SWGR-1	POWER	480V
15	4"	UTILITY XFMR 2	024-SWGR-1	POWER	480V
16	4"	UTILITY XFMR 2	024-SWGR-1	POWER	480V
17	4"	UTILITY XFMR 2	024-SWGR-1	POWER	480V
18	4"	UTILITY XFMR 2	024-SWGR-1	POWER	480V
19	4"	UTILITY XFMR 2	024-SWGR-1	POWER	480V
20	4"	UTILITY XFMR 2	024-SWGR-1	SPARE	-
21	4"	024-EG-1	024-SWGR-1	POWER	480V
22	4"	024-EG-1	024-SWGR-1	POWER	480V
23	4"	024-EG-1	024-SWGR-1	POWER	480V
24	4"	024-EG-1	024-SWGR-1	POWER	480V
25	4"	024-EG-1	024-SWGR-1	POWER	480V
26	4"	024-EG-1	024-SWGR-1	POWER	480V
27	4"	024-EG-1	024-SWGR-1	POWER	480V
28	4"	024-EG-1	024-SWGR-1	SPARE	-
29	2"	024-EG-1	024-PP-1	POWER	480V - GENERATOR DEVICES
30	2"	024-EG-1	024-PLC-1	INSTRUMENTATION	IN GRS CONDUIT
31	2"	024-EG-1	024-PLC-1	CONTROLS	-
32	2"	024-EG-1	024-SWGR-1	CONTROLS	-

NOTES:

1. "-" REPRESENTS A SPACE IN THE DUCT BANK.
2. CONDUIT ELBOWS IN UNDERGROUND DUCT BANKS SHALL BE PVC COATED GRS CONDUIT.
3. EXTERIOR ABOVE GRADE CONDUIT SHALL BE PVC COATED GRS CONDUIT.



E8

REVISIONS	
NAME	DATE

ILLINOIS DEPARTMENT OF TRANSPORTATION	
PUMP STATION NO. 24 RELOCATION	
ELECTRICAL SCHEDULES	
SCALE: N/A	DRAWN BY: MS
DATE: 11-22-10	CHECKED BY: MS