

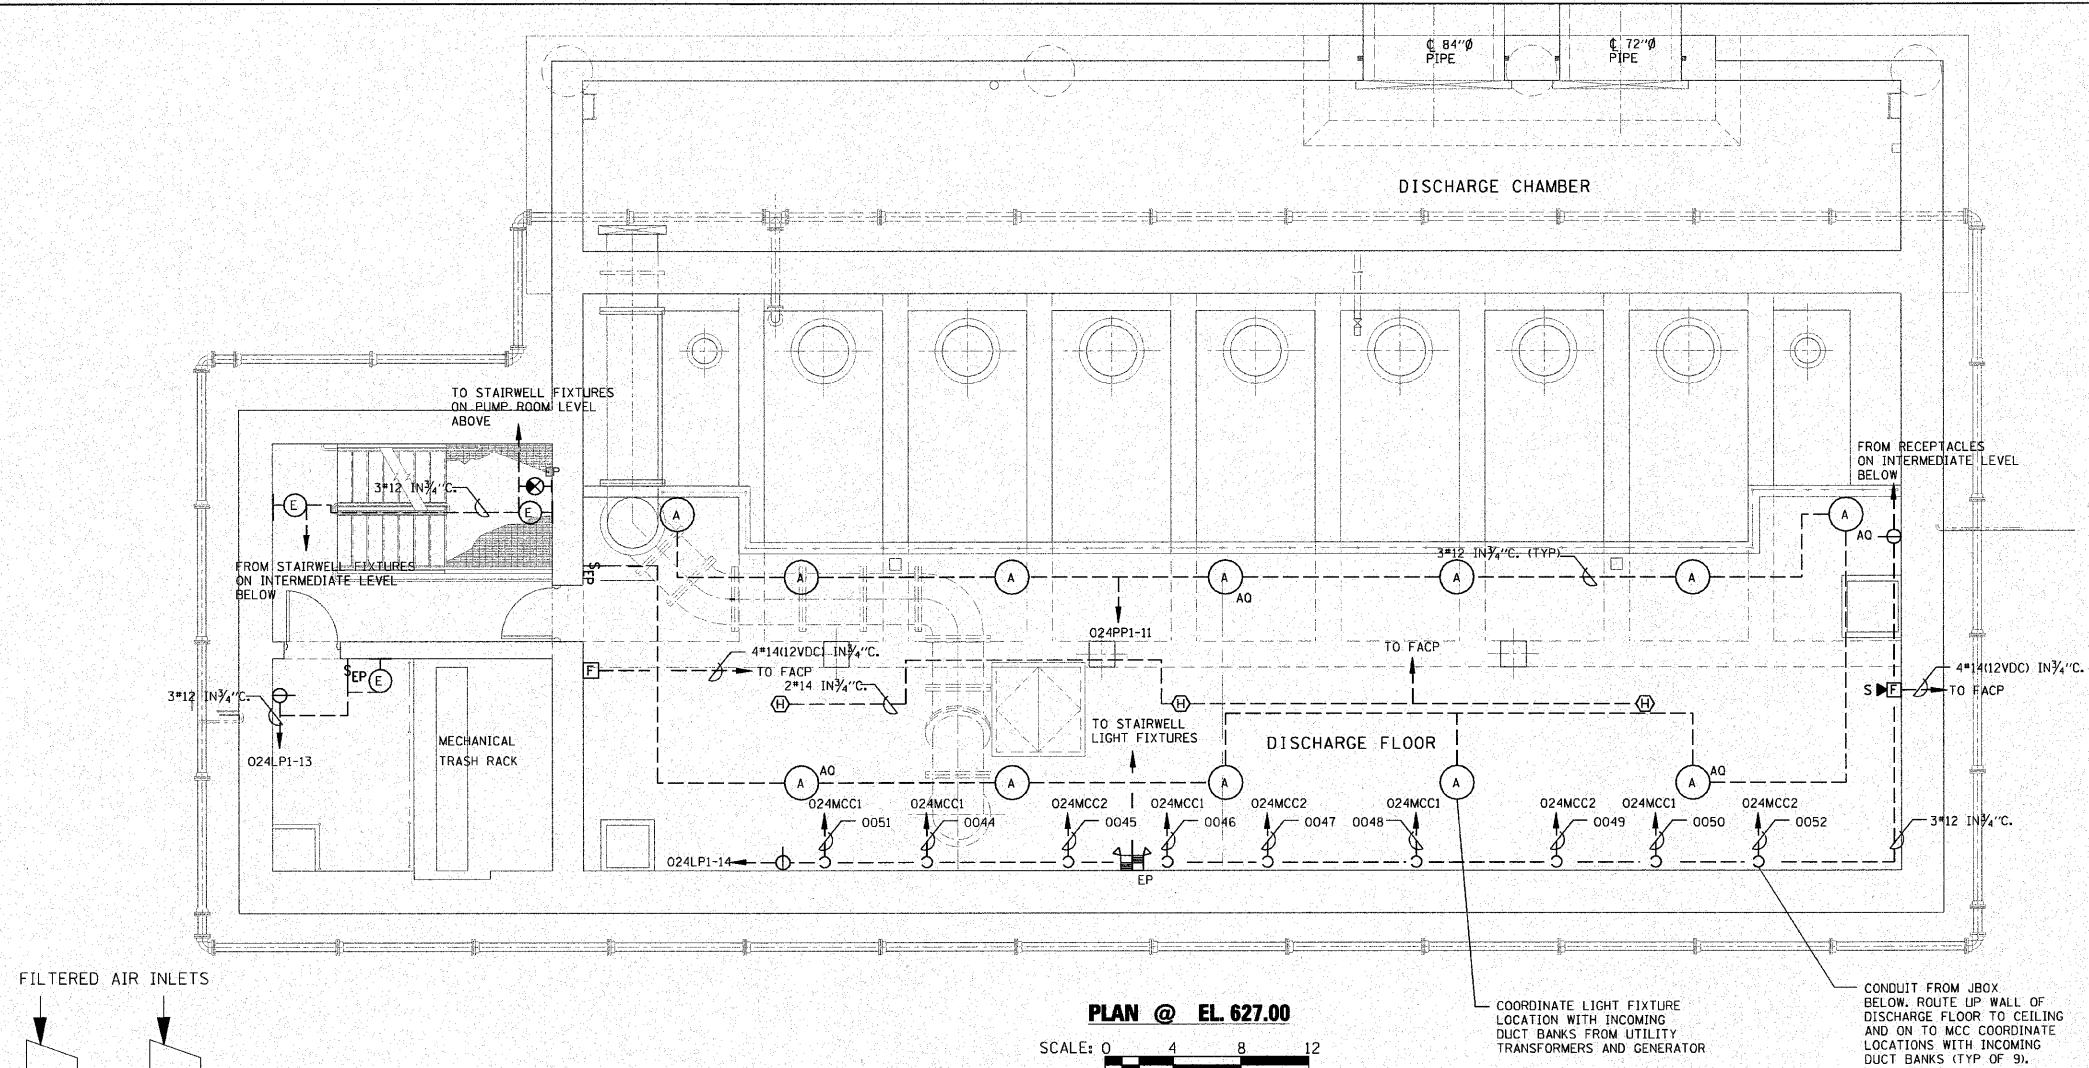


F.A.I. RTE.	SECTION	COUNTY	TOTAL SHEETS	SHEET NO.
190	0102.1 S	COOK	107	91
FED. ROAD DIST. NO.		ILLINOIS	FED. AID PROJECT	

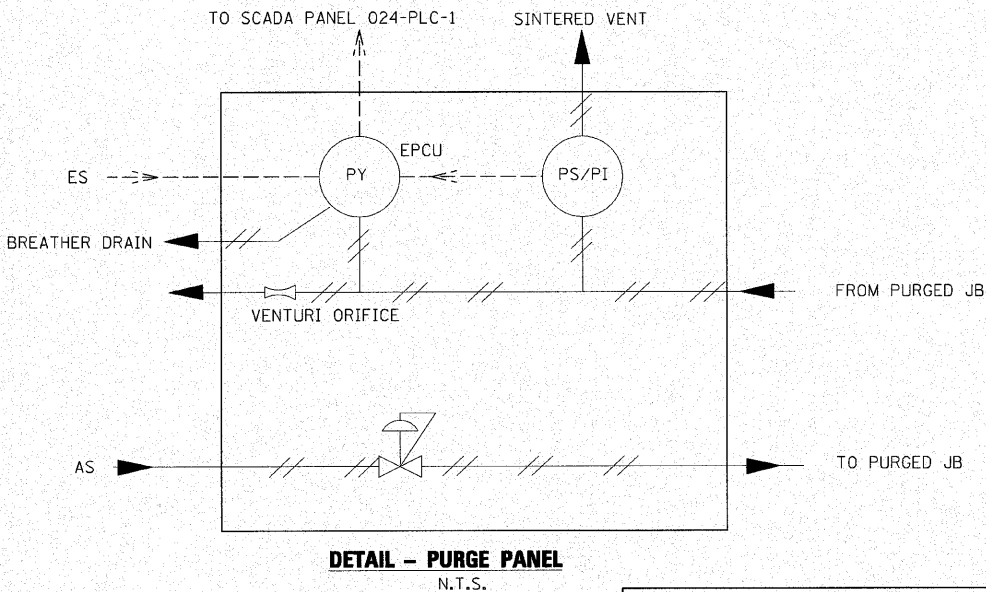

- NOTES:
- ALL ROOMS EXCEPT ELECTRICAL ROOM SHALL BE CLASS I, DIVISION I, GROUP D EXPLOSION PROOF.
 - STAIRWELL SHALL HAVE A LIGHT FIXTURES ABOVE EACH LANDING, TOTAL OF 7 FIXTURES. SEE SECTIONS.
 - MOUNT EXPLOSIONPROOF EMERGENCY LIGHT IN STAIRWELL NEXT TO EXIT LIGHT AND WIRE TO SAME CIRCUIT AS WALL MOUNTED FIXTURE "E", TYPICAL OF 3 ON THIS DRAWING.
 - ALL FIRE ALARM EQUIPMENT SHOWN SHALL BE EXPLOSION PROOF.
 - SEE DRAWING E34 FOR CONDUIT AND CONDUCTOR REQUIREMENTS.
 - COORDINATE CONDUIT ROUTING WITH HVAC DUCTS. SEE DRAWING M12.
 - COORDINATE CONDUIT ROUTING WITH MONORAILS.
 - EXIT LIGHT AND EMERGENCY LIGHTING UNITS SHALL BE WIRED TO NON-SWITCHED PORTION OF LOCAL LIGHTING CIRCUITS.
 - DISCHARGE FLOOR LIGHTS SHALL BE 277VOLT, SINGLE PHASE.

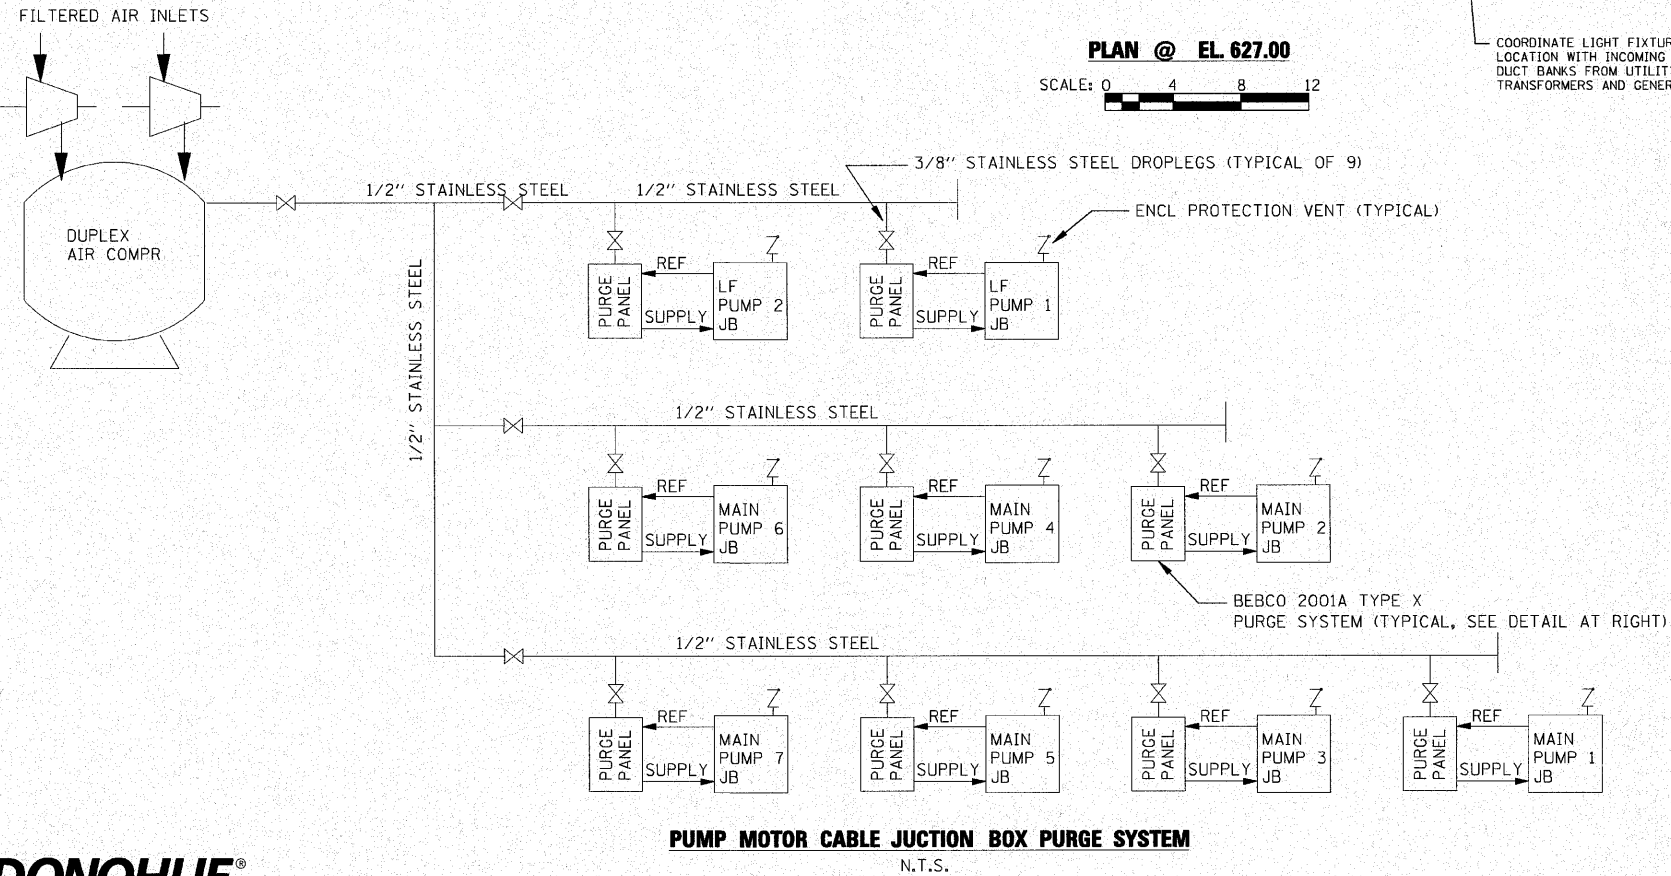

NOTE: PURGE SYSTEM PIPING TO BE FURNISHED UNDER DIVISION 16 AND INSTALLED UNDER DIVISION 15.

ILLINOIS DEPARTMENT OF TRANSPORTATION

PUMP STATION NO. 24
RELOCATION

ELECTRICAL LIGHTING PLAN
SHEET 2.

SCALE: AS SHOWN
DATE: 11-22-10

DRAWN BY: MS
CHECKED BY: MS

REVISIONS

NAME	DATE