


LEGEND

	HIGH MAST LIGHT TOWER & LUMINAIRE
	LIGHTING CONTROLLER
	ELECTRIC UTILITY POLE & TRANSFORMER
	UNIT DUCT
	RIGID GALVANIZED STEEL CONDUIT (RGC), PUSHED OR TRENCHED

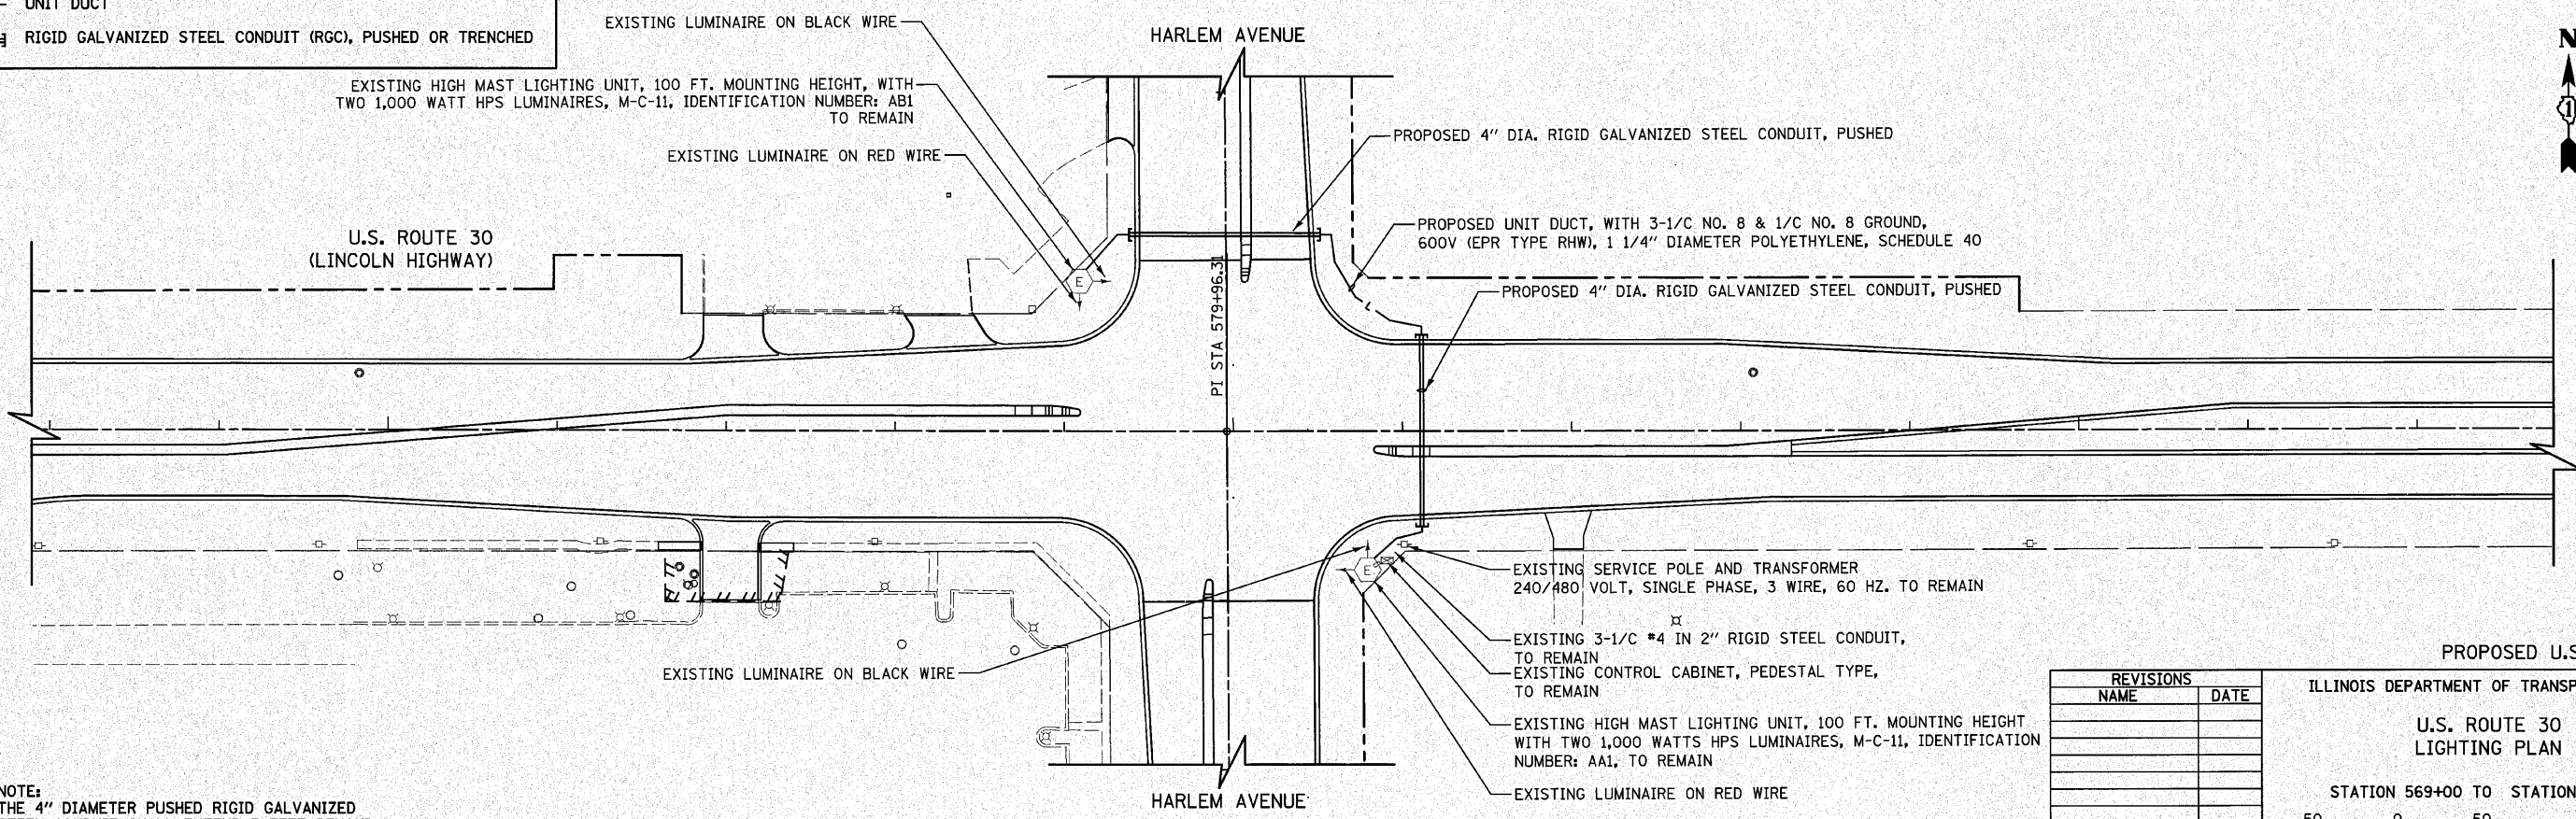

NOTE:
THE 4" DIAMETER PUSHED RIGID GALVANIZED STEEL CONDUIT SHALL EXTEND 3 FEET BEYOND BACK OF CURB OR EDGE OF PAVED SURFACE.

REVISIONS	
NAME	DATE

ILLINOIS DEPARTMENT OF TRANSPORTATION

U.S. ROUTE 30 LIGHTING PLAN

STATION 569+00 TO STATION 584+00

SCALE IN FEET

DATE 6/11/2010

DRAWN BY DJK
CHECKED BY JRV