
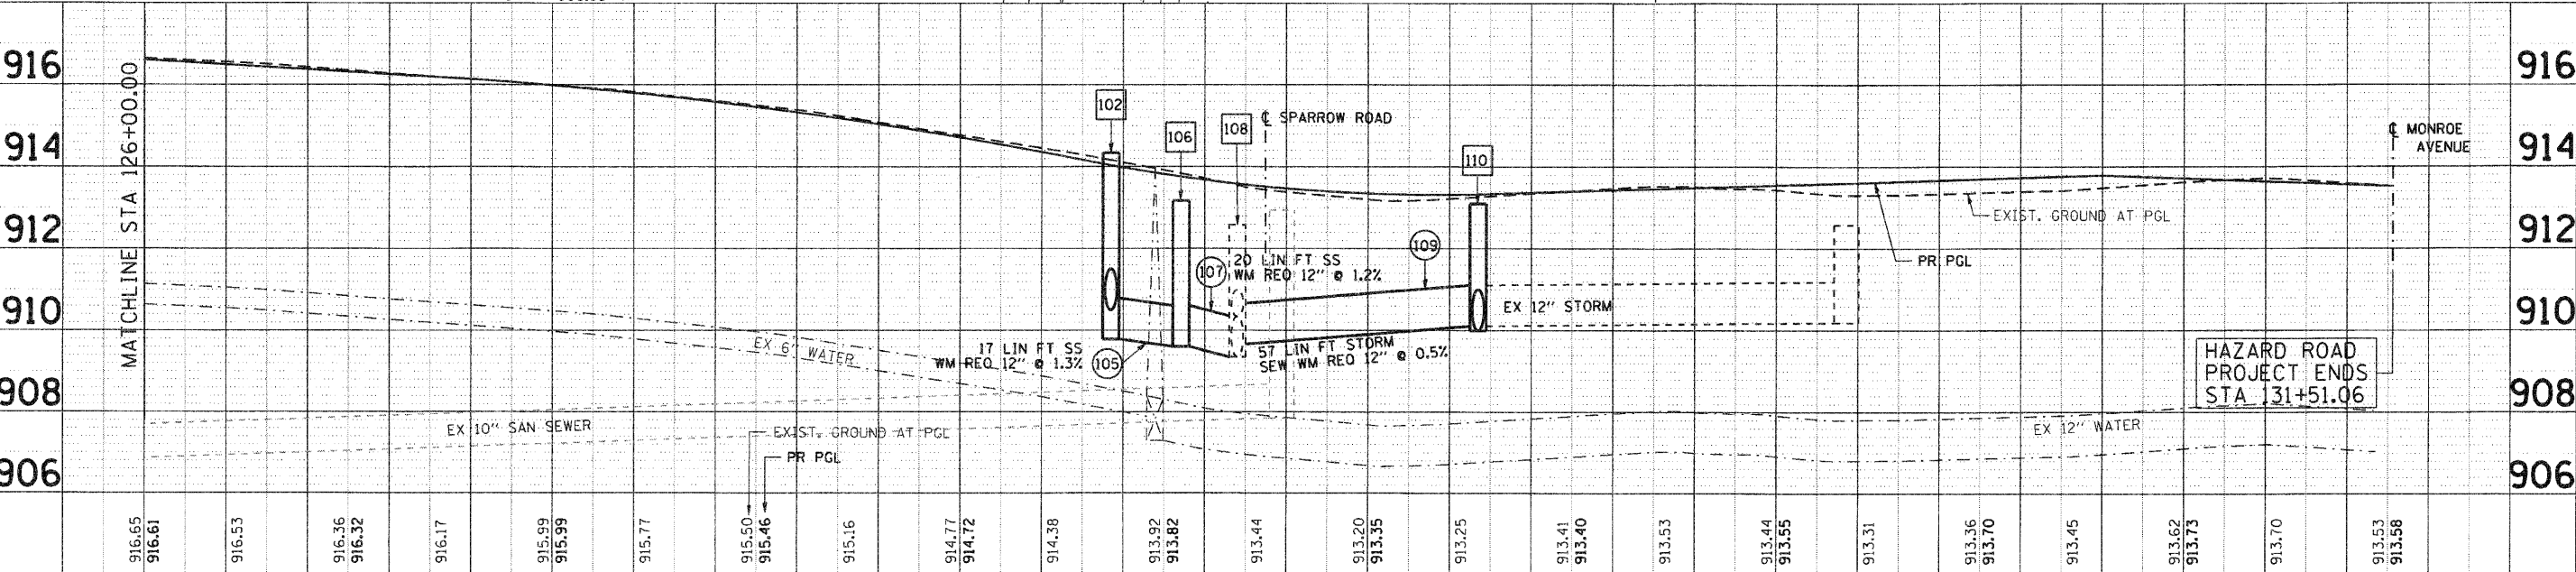


DATE	
BY	
REVISION	
NO.	
DATE	
BY	
REVISION	
NO.	
DATE	
BY	
REVISION	
NO.	

DATE	
BY	
REVISION	
NO.	
DATE	
BY	
REVISION	
NO.	
DATE	
BY	
REVISION	
NO.	

COMPANY NAME: SEC GROUP, INC.
 PROJECT CONTACT: A. JAIN
 CLIENT: VILLAGE OF CARPENTERSVILLE
 CLIENT ADDRESS: 1000 W. MONROE ST., CARPENTERSVILLE, IL 61813
 FILE NAME: 06-0074-00-FP
 PLOT DRIVER: defplot-dt-trans.tbl
 PEN TABLE: standard-dt-trans.tbl

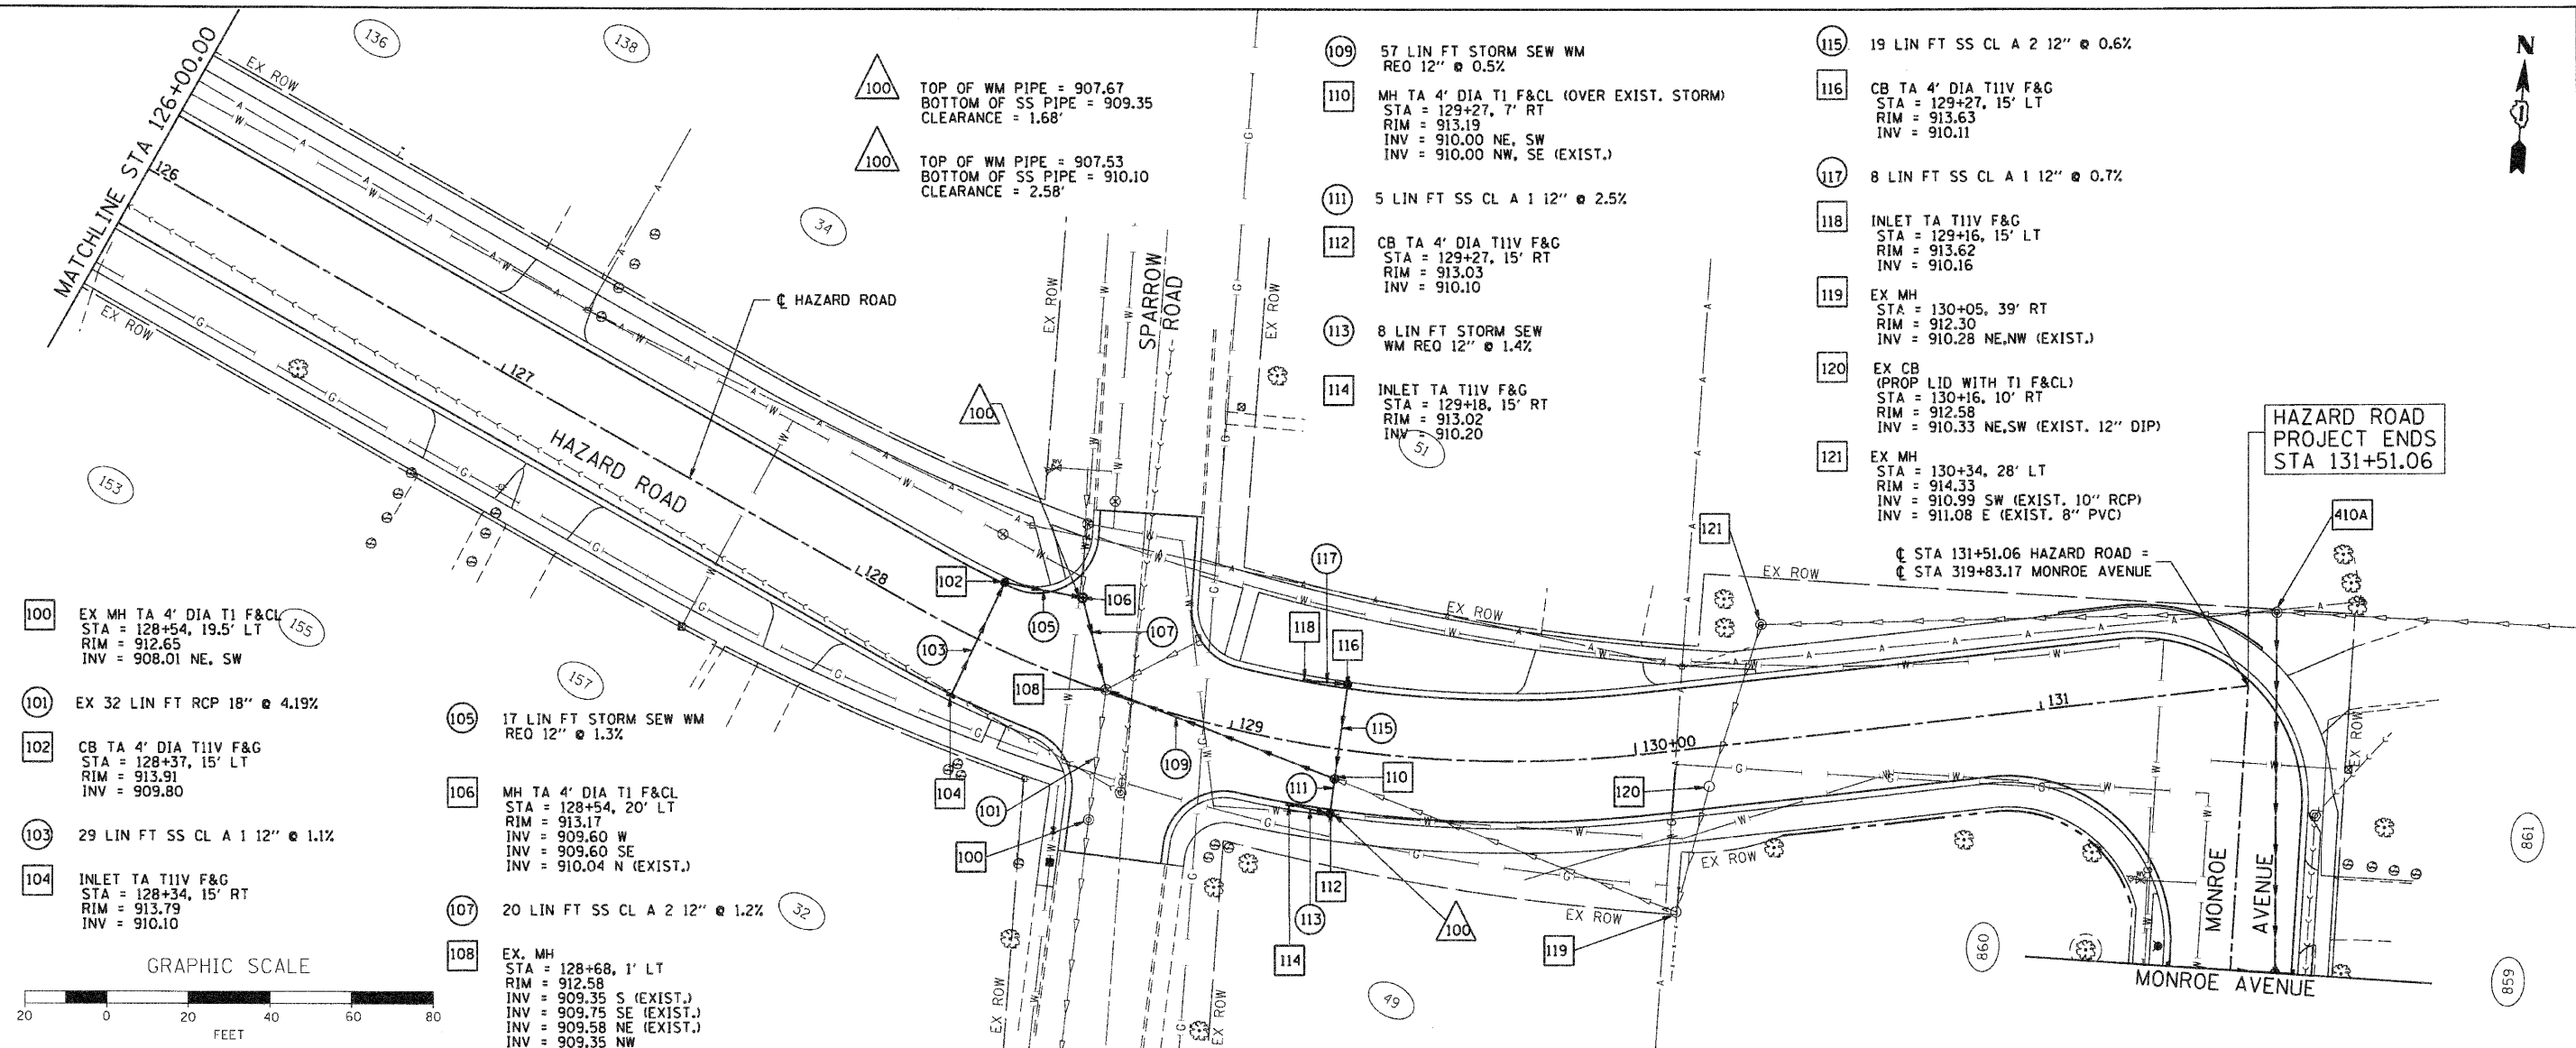

126+00	126+50	127+00	127+50	128+00	128+50	129+00	129+50	130+00	130+50	131+00	131+50																							
916.65	916.61	916.53	916.36	916.32	916.17	915.99	915.99	915.77	915.50	915.46	915.16	914.77	914.72	914.38	913.92	913.82	913.44	913.20	913.35	913.25	913.41	913.40	913.53	913.44	913.55	913.31	913.36	913.70	913.45	913.62	913.75	913.70	913.53	913.58

SEC Group, Inc.
 An HR Group Company
 401 N. First Street
 Mankato, IL 61860-2138
 P: 815.382.7778 F: 815.382.7741
 www.secgroup.com

USER NAME	= Char Uke	DESIGNED	= A. JAIN	REVISED	=
DRAWN	= S. PERNAL	CHECKED	= T. HAMILTON	REVISED	=
DATE	= 10/25/10	REVISED	=		

VILLAGE OF CARPENTERSVILLE

DRAINAGE AND UTILITY PLAN AND PROFILE
HAZARD ROAD

F.A. RTE.	SECTION	COUNTY	TOTAL SHEETS	SHEET NO.
	06-0074-00-FP	KANE	211	53
* FAU 2414, FAU 1280, FAP 343			CONTRACT NO. 63504	
FED. ROAD DIST. NO. [ILLINOIS] FED. AID PROJECT				