




DATE	
BY	
PLAN	
NO. OF SHEETS	
NO. OF SHEETS CHECKED	
NO. OF SHEETS REVISIONS	
NO. OF SHEETS CADD FILE NAME	

DATE	
BY	
PROFILE	
NO. OF SHEETS	
NO. OF SHEETS CHECKED	
NO. OF SHEETS REVISIONS	
NO. OF SHEETS CADD FILE NAME	

COMPANY NAME: SEC GROUP, INC.
 PROJECT CONTACT: A. JAIN
 PROJECT ADDRESS: VILLAGE OF CARPENTERSVILLE
 CLIENT CONTACT: J. HAMILTON
 CLIENT ADDRESS: 100 S. 5TH ST. ST. LOUIS, MO 63102
 FILE NAME: 060074-00-FP
 PLOT DRIVER: strander@franklin.com
 PEN TABLE:

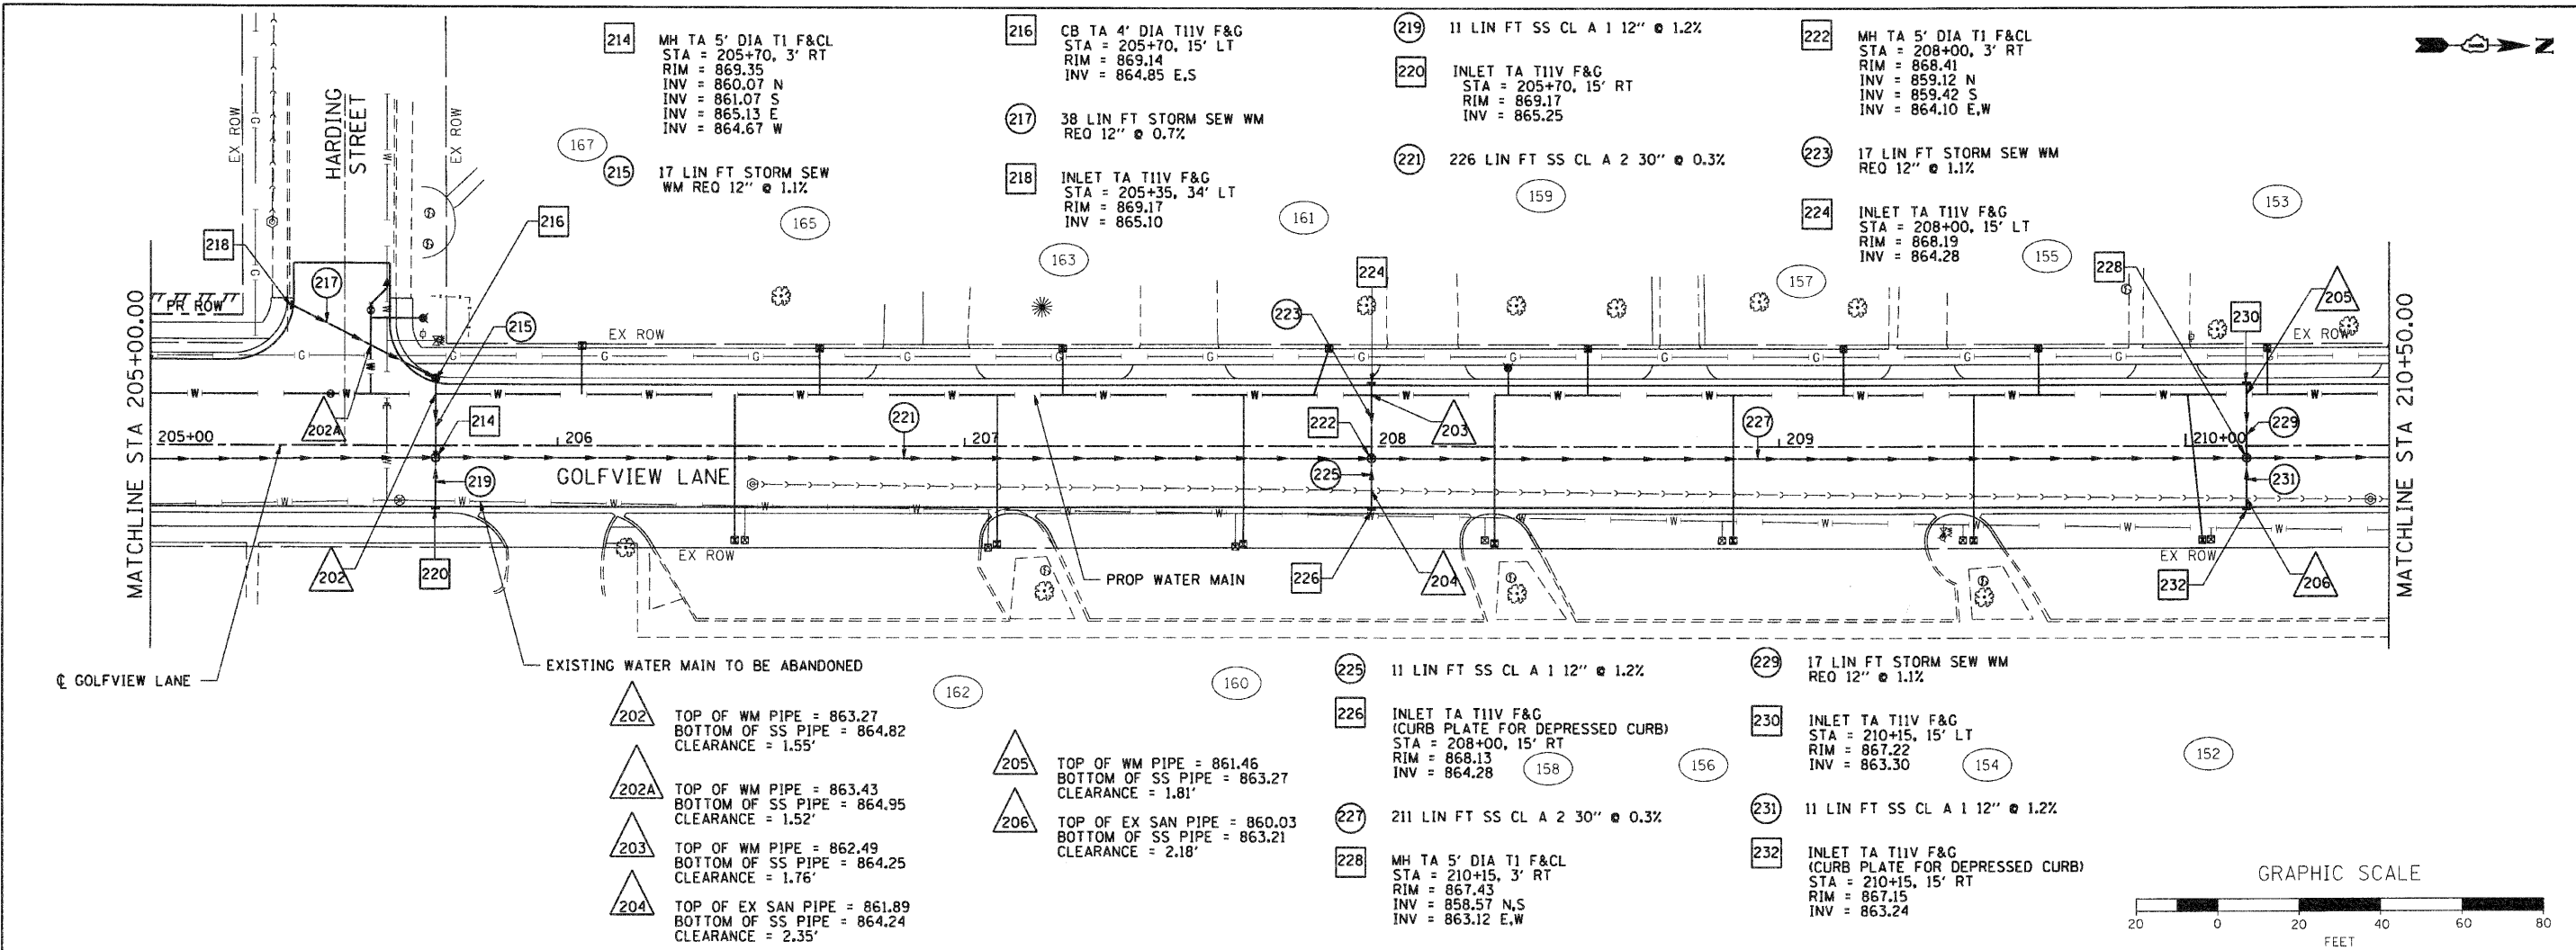

 - 202 TOP OF WM PIPE = 863.27
BOTTOM OF SS PIPE = 864.82
CLEARANCE = 1.55'
- 202A TOP OF WM PIPE = 863.43
BOTTOM OF SS PIPE = 864.95
CLEARANCE = 1.52'
- 203 TOP OF WM PIPE = 862.49
BOTTOM OF SS PIPE = 864.25
CLEARANCE = 1.76'
- 204 TOP OF EX SAN PIPE = 861.89
BOTTOM OF SS PIPE = 864.24
CLEARANCE = 2.35'
- 205 TOP OF WM PIPE = 861.46
BOTTOM OF SS PIPE = 863.27
CLEARANCE = 1.81'
- 206 TOP OF EX SAN PIPE = 860.03
BOTTOM OF SS PIPE = 863.21
CLEARANCE = 2.18'

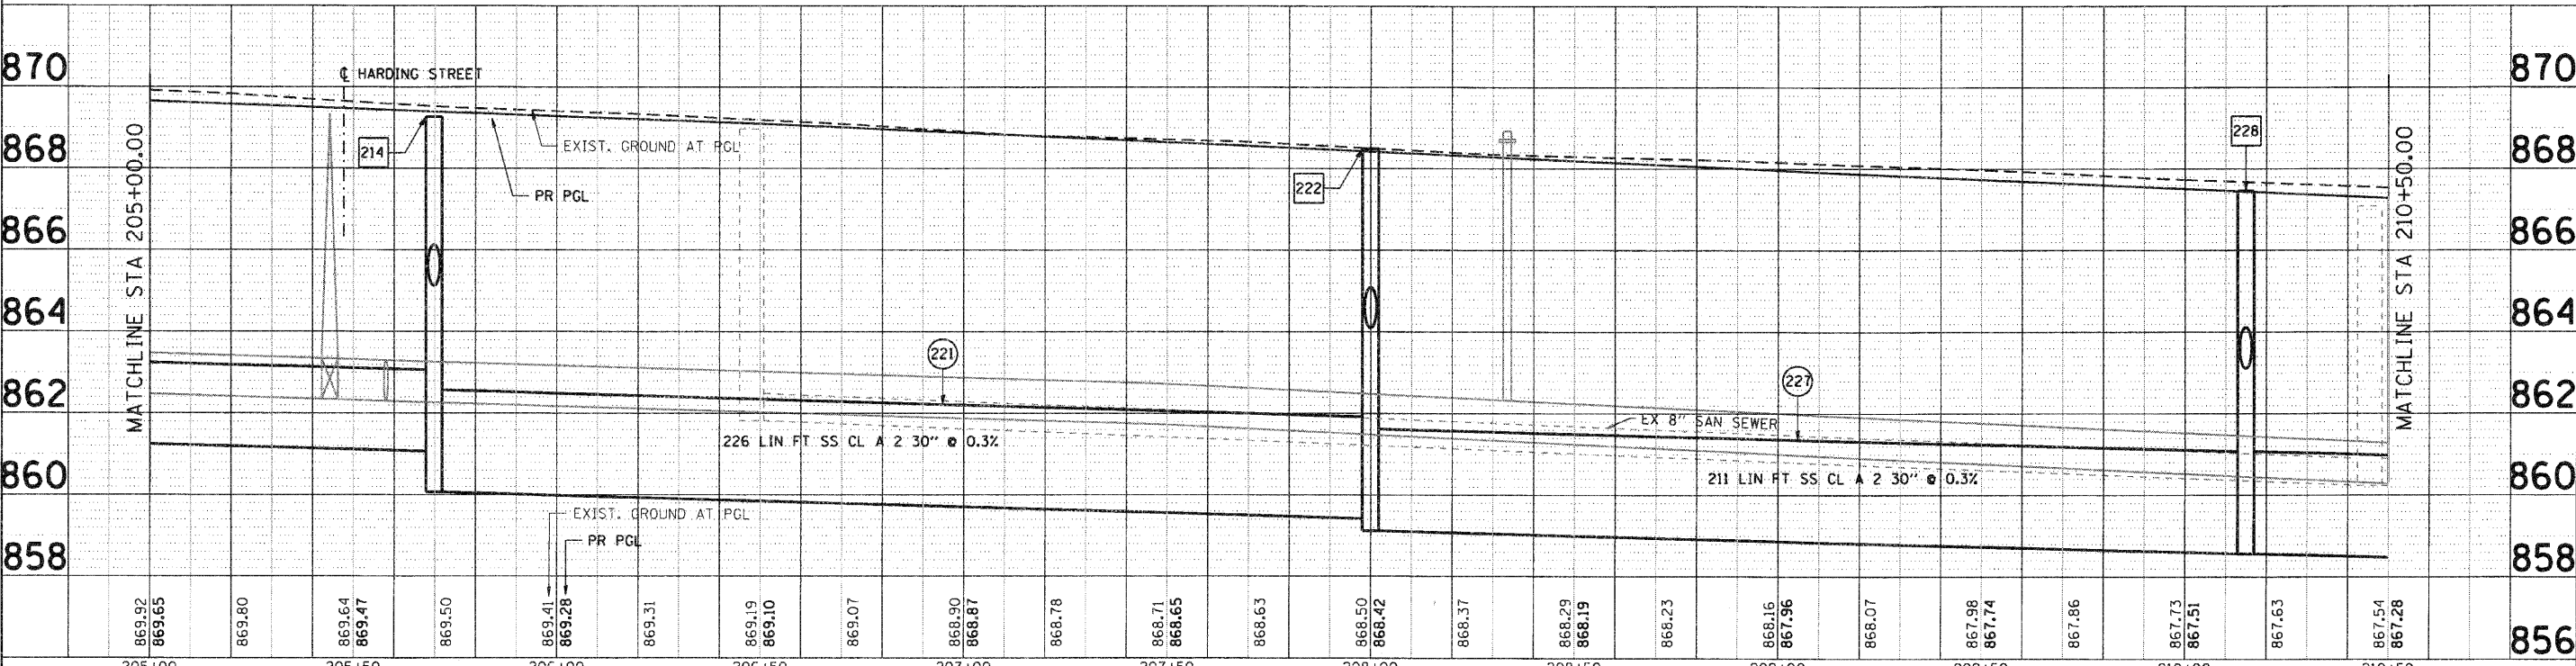

205+00	869.92	869.65	869.80	869.64	869.47	869.50	869.41	869.28	869.31	869.19	869.10	869.07	868.90	868.87	868.78	868.71	868.65	868.63	868.50	868.42	868.37	868.29	868.19	868.23	868.16	867.96	868.07	867.98	867.74	867.86	867.73	867.51	867.63	867.54	867.28	856		
205+50																																						
206+00																																						
206+50																																						
207+00																																						
207+50																																						
208+00																																						
208+50																																						
209+00																																						
209+50																																						
210+00																																						
210+50																																						

<p>SEC Group, Inc. An HR Group Company 425 N. Front Street Maitland, FL 32751 407.885.1778 • 407.885.1781 www.secgroupinc.com</p>	USER NAME = Chh-uke PLOT SCALE = 1" = 20' PLOT DATE = 11/1/2010	DESIGNED - A. JAIN DRAWN - S. PERNAL CHECKED - T. HAMILTON DATE - 10/25/10	REVISED - REVISED - REVISED - REVISED -	VILLAGE OF CARPENTERSVILLE DRAINAGE AND UTILITY PLAN AND PROFILE GOLFVIEW LANE	SCALE: 1" = 20' SHEET NO. 7 OF 21 SHEETS STA. 205+00 TO STA. 210+50	SECTION 06-00074-00-FP COUNTY KANE TOTAL SHEETS 211 SHEET NO. 55 *FAU 2414, FAU 1280, FAP 343 CONTRACT NO. 63504 FED. ROAD DIST. NO. [ILLINOIS] FED. AID PROJECT
--	---	---	--	---	---	--