
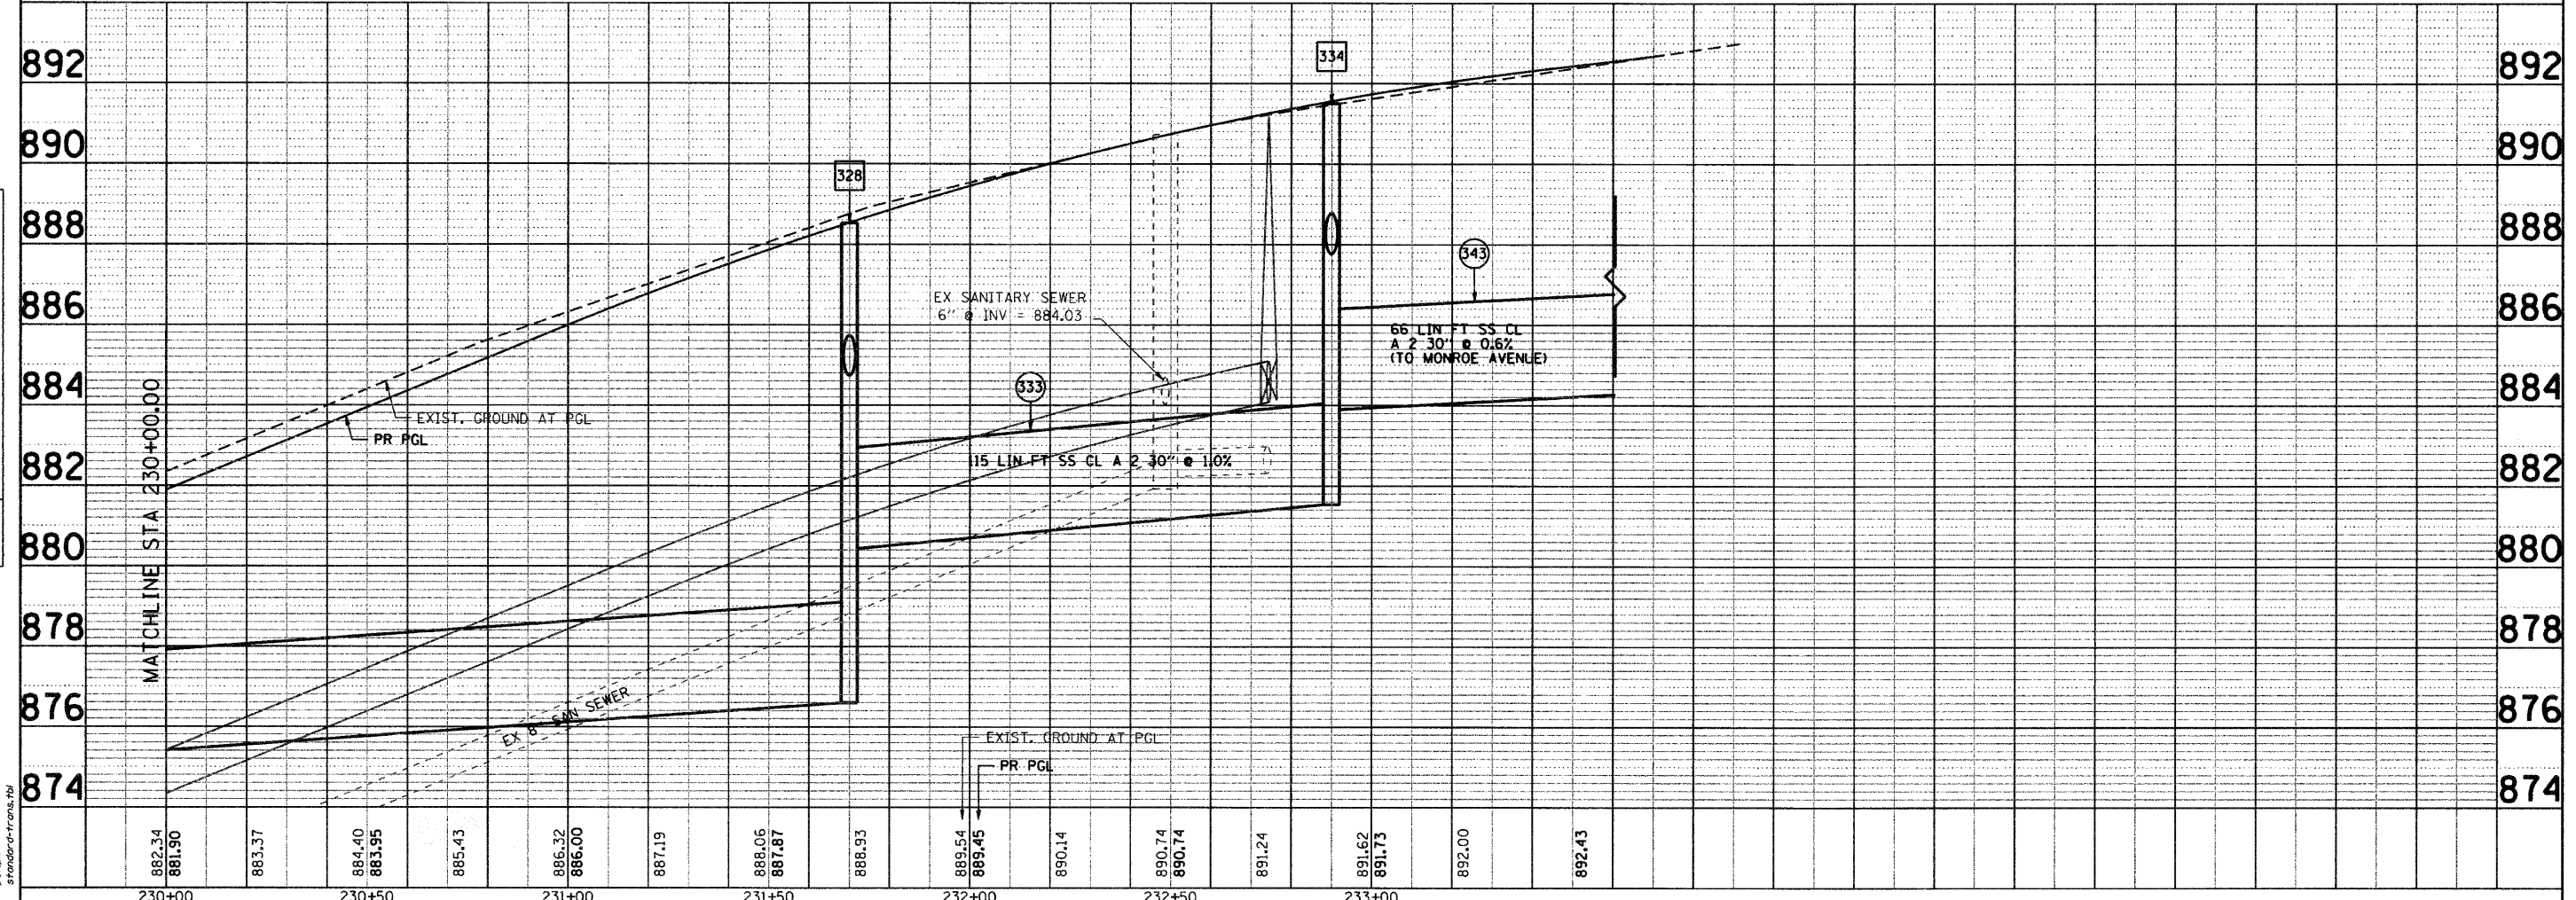


DATE	
BY	
REVIEWED	
ALIGNED	
CHECKED	
DATE	
FILE NAME	
NO.	

DATE	
BY	
REVIEWED	
ALIGNED	
CHECKED	
DATE	
FILE NAME	
NO.	

SEC GROUP, INC.
 PROJECT CONTACT: VILLAGE OF CARPENTERSVILLE
 CLIENT: VILLAGE OF CARPENTERSVILLE
 DATE PLOTTED: 11/5/2010 2:43:50 PM
 FILE NAME: 060326-00-12.dwg
 PLOT DRIVER: pdfplot
 PEN TABLE: standard-trans.tbl

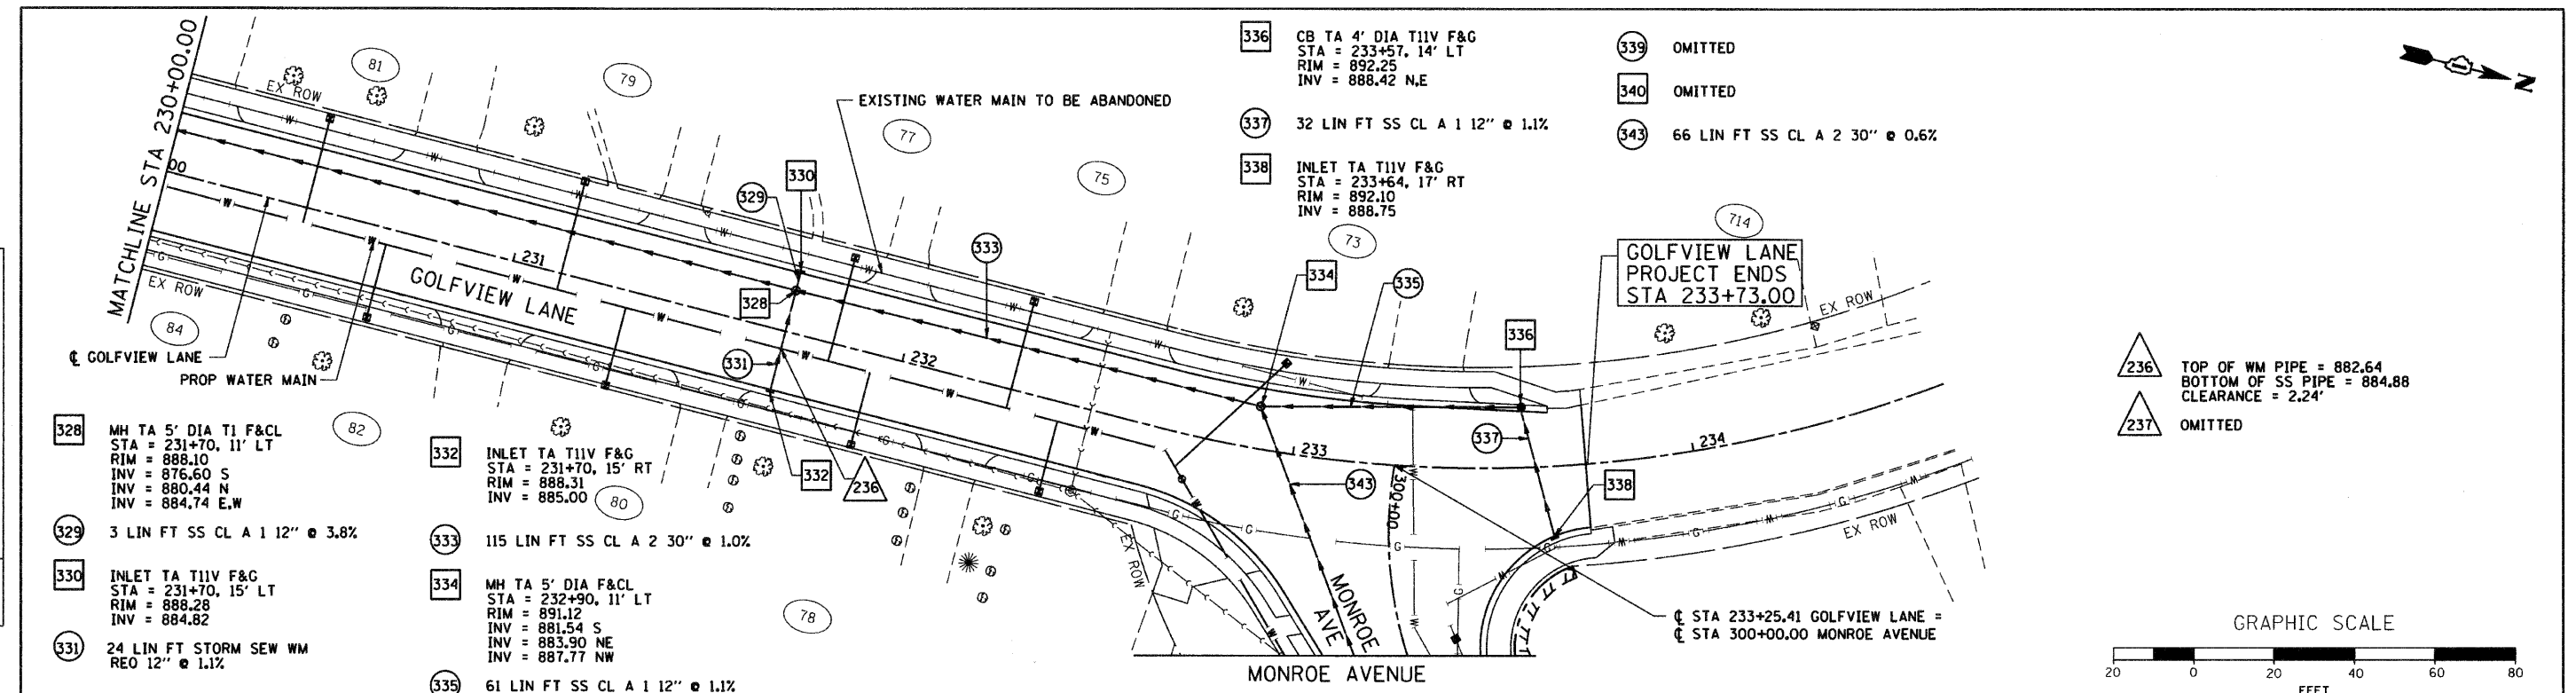

<p>SEC Group, Inc.</p> <p>USER NAME = CHor-ke</p> <p>DESIGNED - A. JAIN</p> <p>DRAWN - S. PERNAL</p> <p>CHECKED - T. HAMILTON</p> <p>DATE - 10/25/10</p>	<p>REVISD -</p> <p>REVISD -</p> <p>REVISD -</p> <p>REVISD -</p>	<p>VILLAGE OF CARPENTERSVILLE</p> <p>DRAINAGE AND UTILITY PLAN AND PROFILE</p> <p>GOLFVIEW LANE</p> <p>SCALE: 1" = 20'</p> <p>SHEET NO. 12 OF 21 SHEETS</p> <p>STA. 230+00 TO STA. END</p>	<table border="1"> <tr><td>F.A. RTE.</td><td>SECTION</td><td>COUNTY</td><td>TOTAL SHEETS</td><td>SHEET NO.</td></tr> <tr><td>*</td><td>06-00074-00-FP</td><td>KANE</td><td>211</td><td>60</td></tr> <tr><td colspan="3">* FAU 2414, FAU 1280, FAP 343</td><td colspan="2">CONTRACT NO. 63504</td></tr> <tr><td colspan="3">FED. ROAD DIST. NO.</td><td colspan="2">ILLINOIS FED. AID PROJECT</td></tr> </table>	F.A. RTE.	SECTION	COUNTY	TOTAL SHEETS	SHEET NO.	*	06-00074-00-FP	KANE	211	60	* FAU 2414, FAU 1280, FAP 343			CONTRACT NO. 63504		FED. ROAD DIST. NO.			ILLINOIS FED. AID PROJECT	
F.A. RTE.	SECTION	COUNTY	TOTAL SHEETS	SHEET NO.																			
*	06-00074-00-FP	KANE	211	60																			
* FAU 2414, FAU 1280, FAP 343			CONTRACT NO. 63504																				
FED. ROAD DIST. NO.			ILLINOIS FED. AID PROJECT																				