
 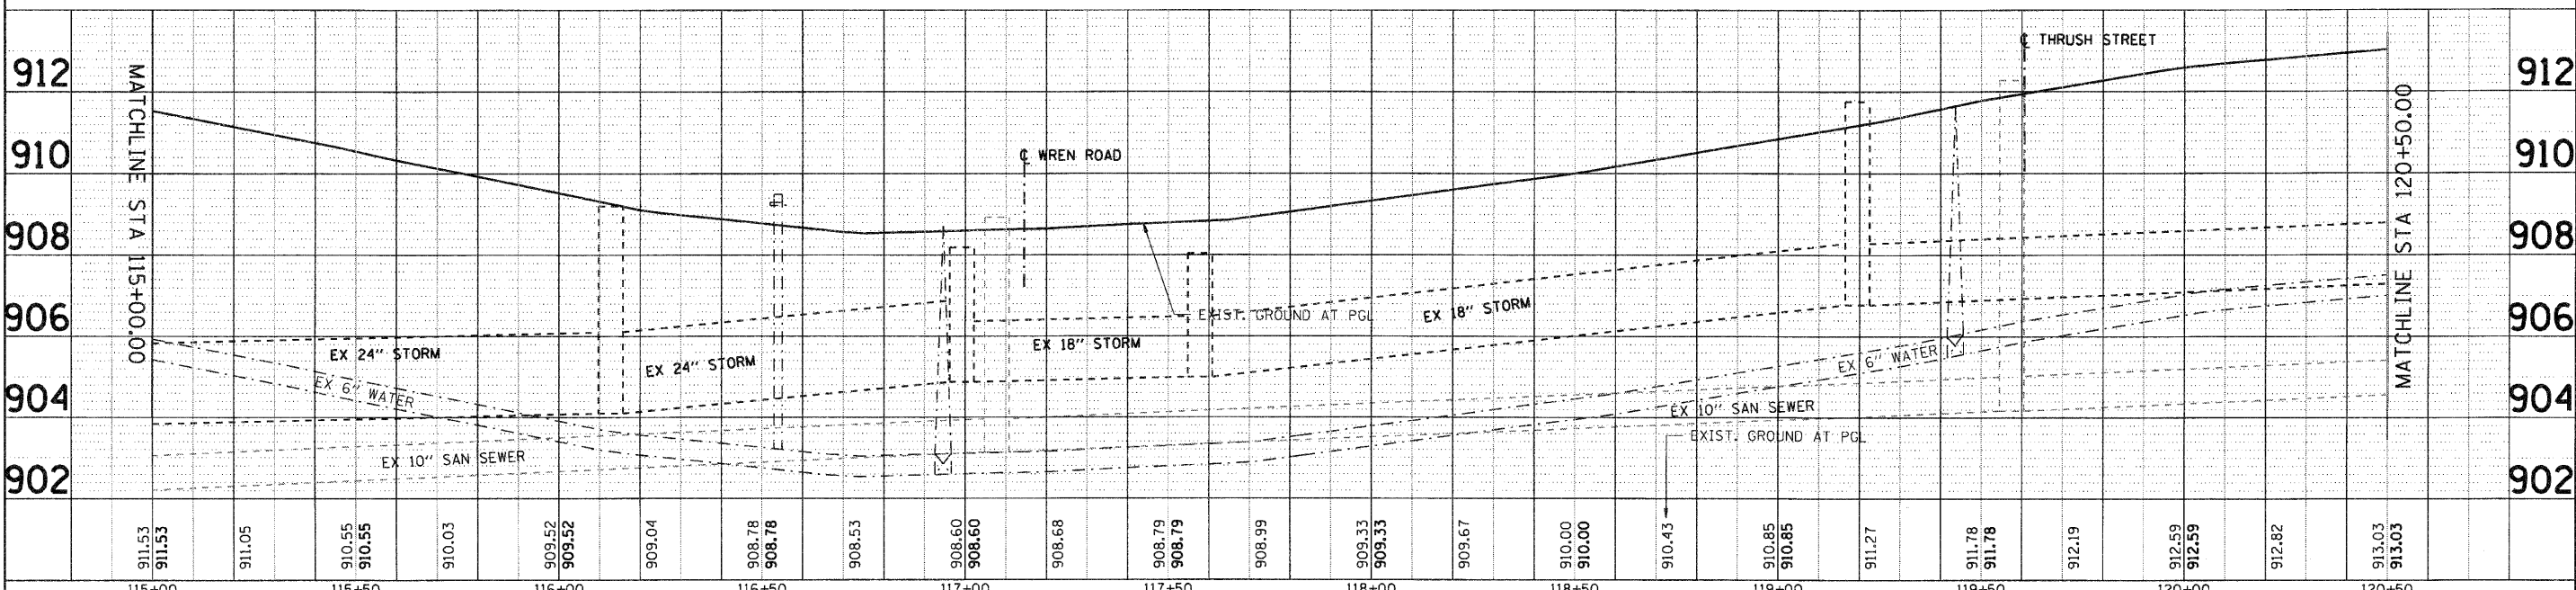



PLAN	SURVEYED	DATE
	PLOTTED	BY
	NOTED	
	REVISIONS	
	FILE NAME	
	NO.	

PROFILE	SURVEYED	DATE
	PLOTTED	BY
	NOTED	
	REVISIONS	
	FILE NAME	
	NO.	

COMPANY NAME: SEC GROUP, INC.
 PROJECT CONTACT: A. JAIN
 CLIENT: VILLAGE OF CARPENTERSVILLE
 CLIENT ADDRESS: 1000 W. FAY
 FILE NAME: 0600074-00-FP
 PLOT DRIVER: pefash
 PEN TABLE: standard-trans.tbl

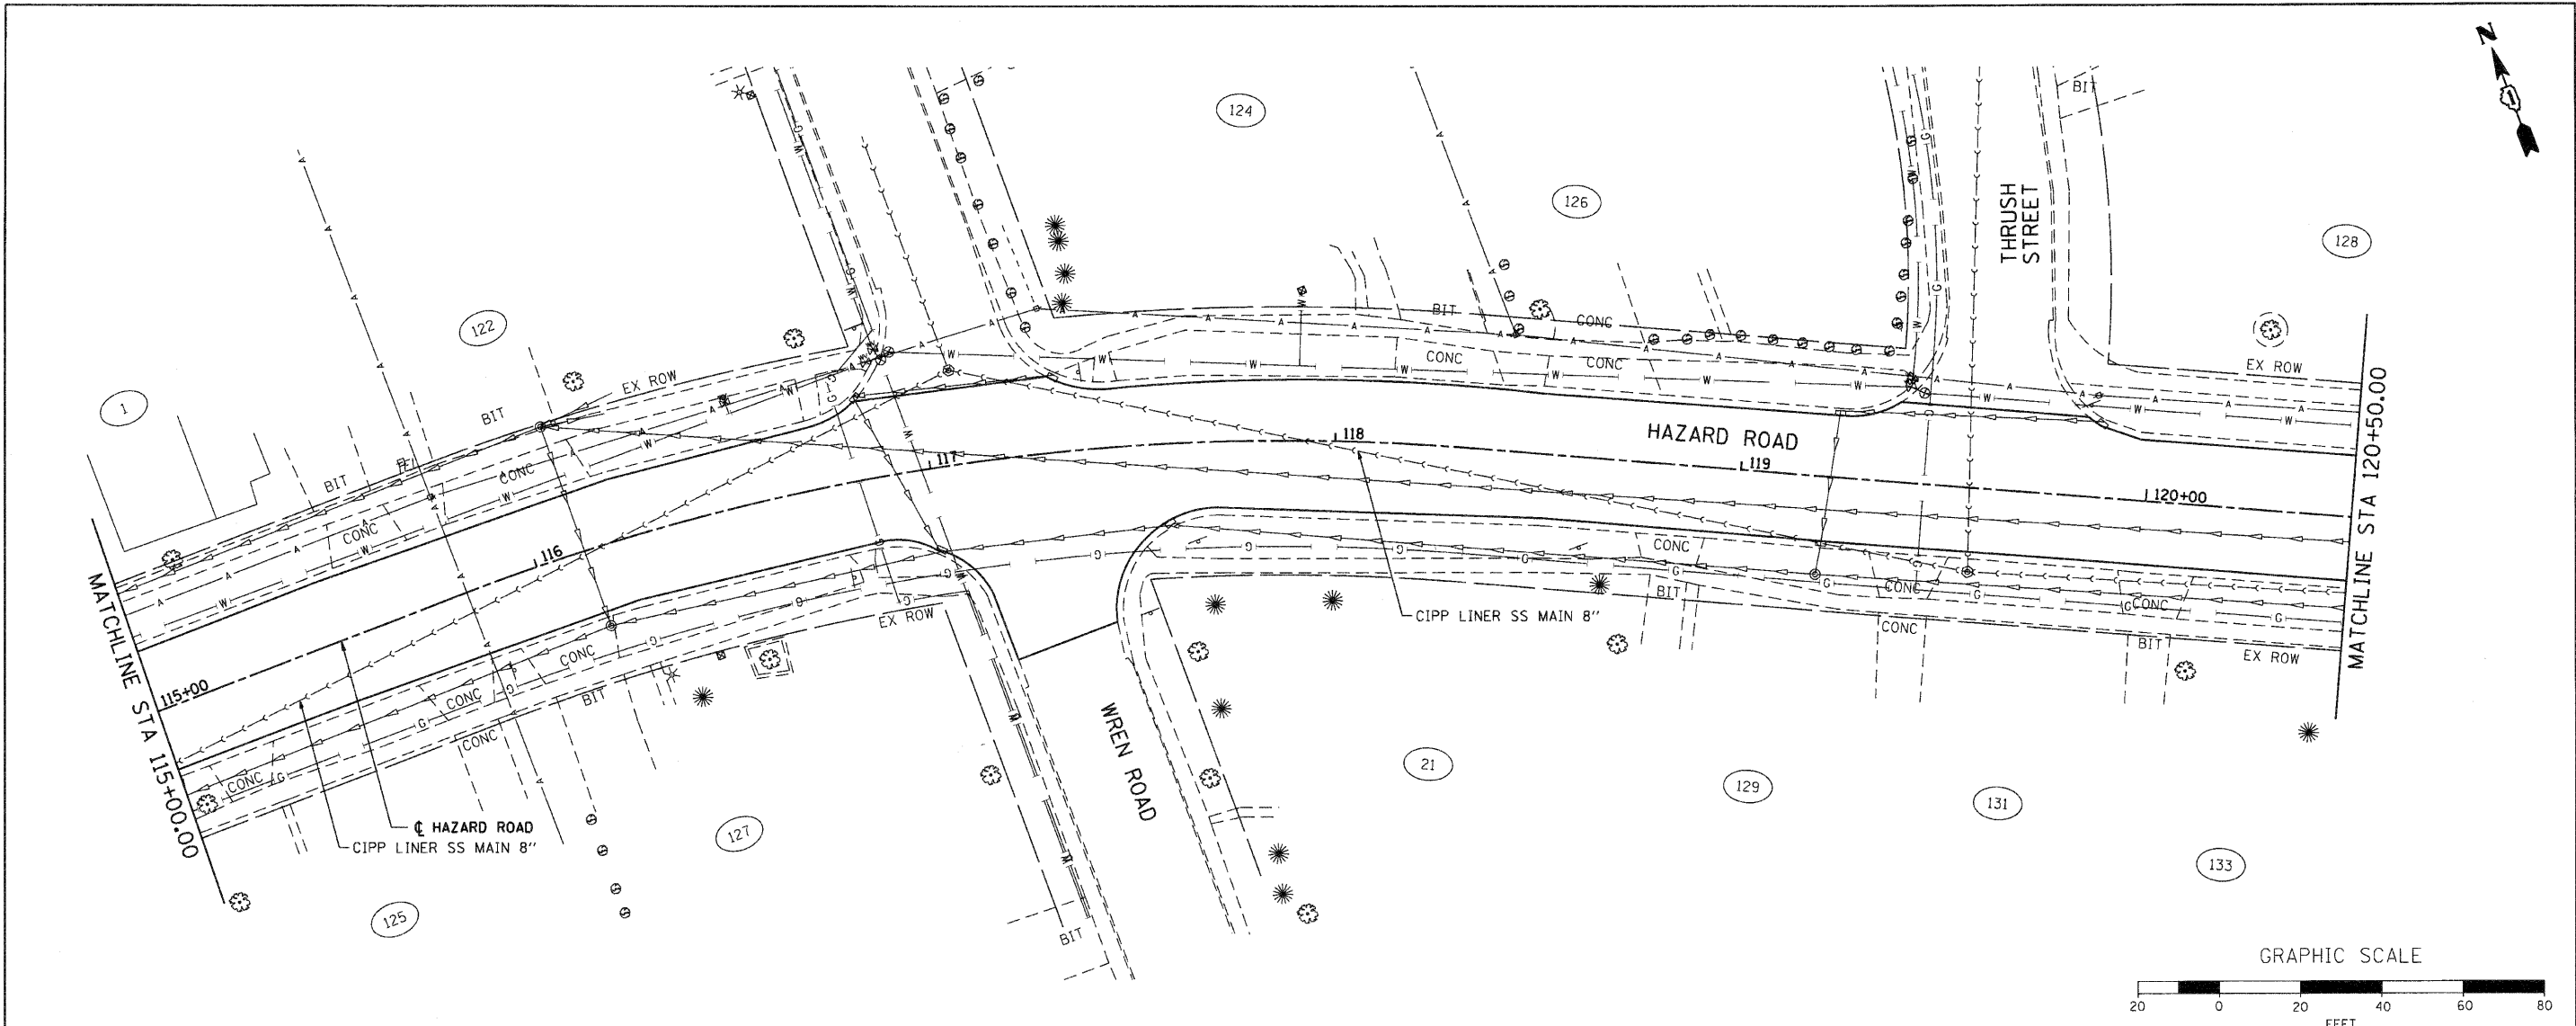

DESIGNED - C. PIEPER	REVISIONS	WATERMAIN AND SANITARY SEWER PLAN AND PROFILE HAZARD ROAD SCALE: 1" = 20' SHEET NO. 3 OF 20 SHEETS STA. 115+00 TO STA. 120+50	SECTION 06-00074-00-FP COUNTY KANE TOTAL SHEETS 211 SHEET NO. 72 CONTRACT NO. 63504
DRAWN - R. BEST	REVISIONS		
CHECKED - T. HAMILTON	REVISIONS		
DATE - 10/25/10	REVISIONS		