
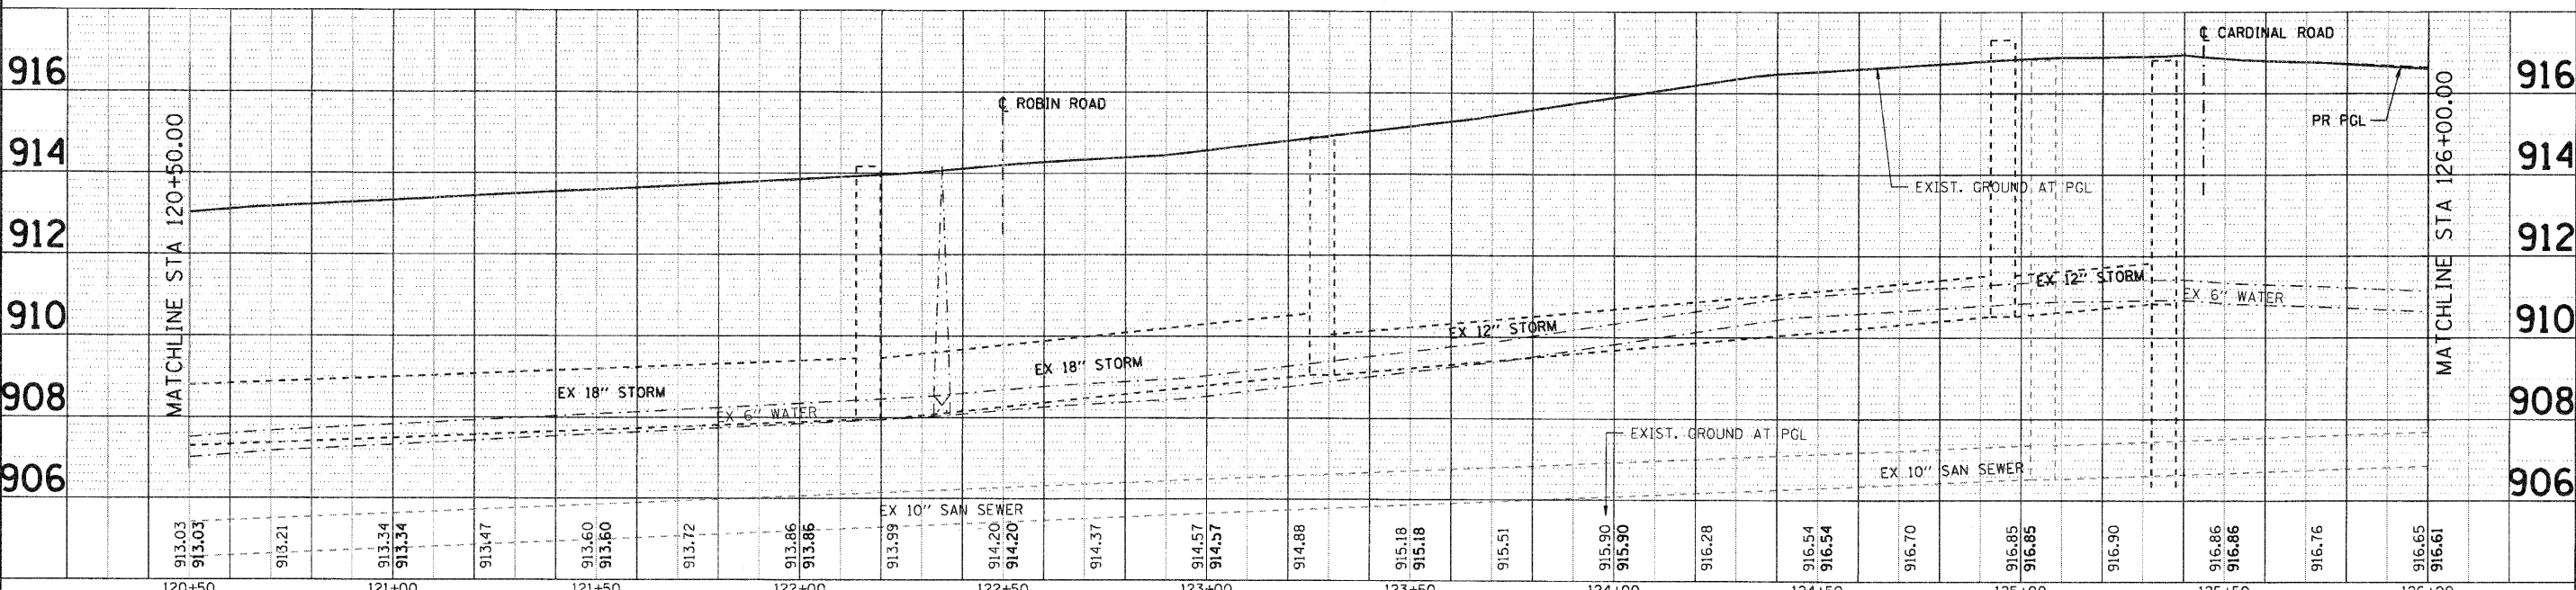
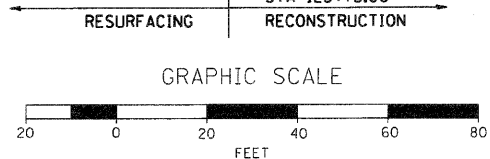


PLAN	SURVEYED	DATE
	PLOTTED	
	NOTE BOOK	
	FILE NAME	
	NO.	

PROFILE	SURVEYED	DATE
	PLOTTED	
	NOTE BOOK	
	FILE NAME	
	NO.	

COMPANY CONTACT: SEC GROUP, INC.
 PROJECT CONTACT: A. JAIN
 PROJECT: VILLAGE OF CARPENTERSVILLE
 DATE PLOTTED: 11/12/10 5:00:07 PM
 FILE NAME: 0600074-wr-04.dgn
 PLOT DRIVER: pd104t
 PEN TABLE: standard-trans.tbl

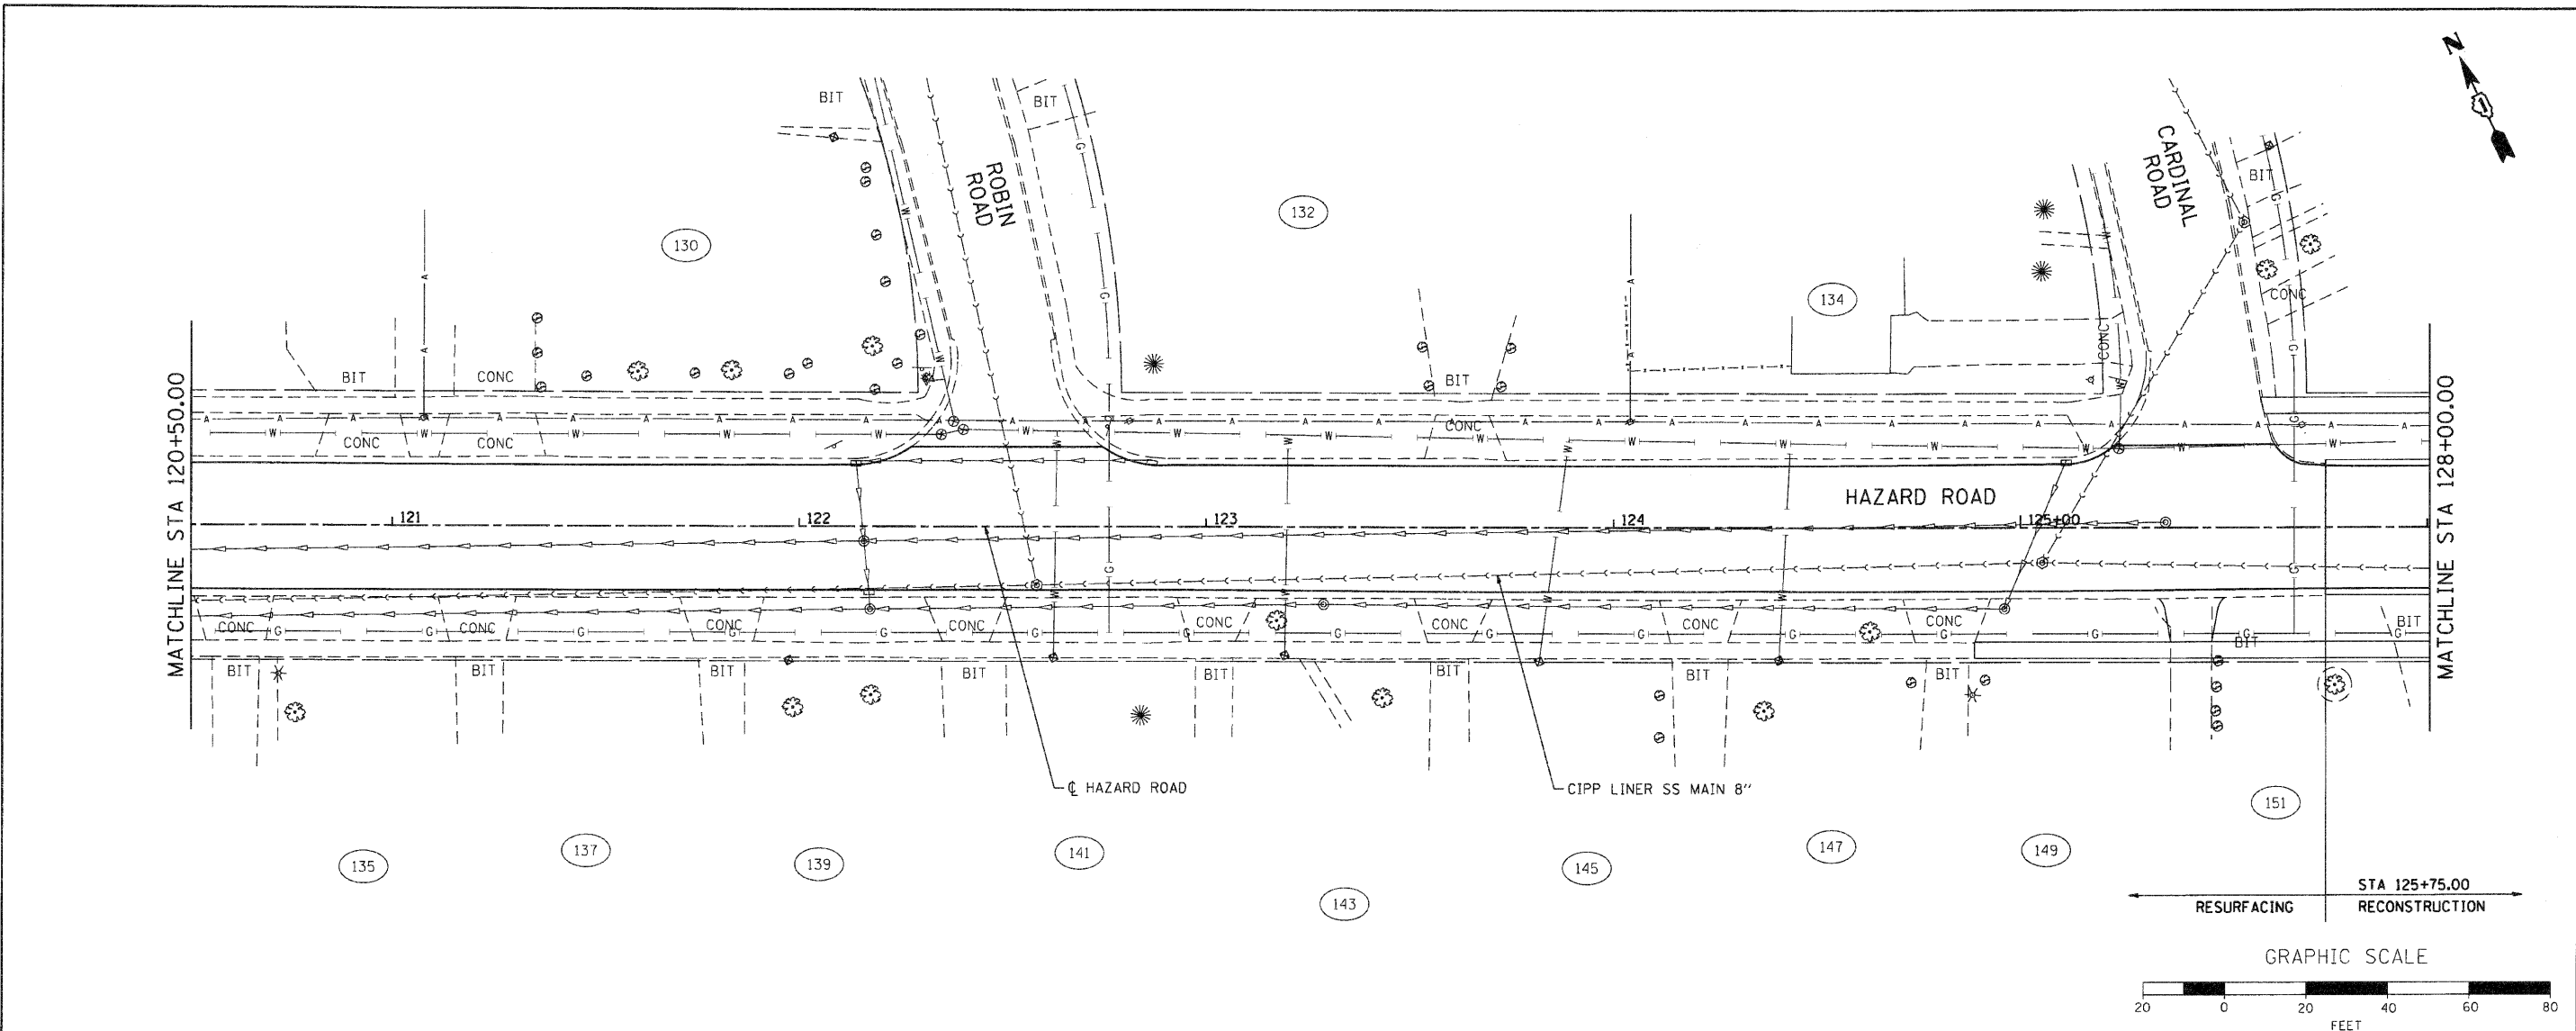

120+50	913.03 913.03	913.21	913.34 913.34	913.47	913.60 913.60	913.72	913.86 913.86	913.99 914.20 914.20	914.37	914.57 914.57	914.88	915.18 915.18	915.51	915.90 915.90	916.28	916.54 916.54	916.70	916.85 916.85	916.90	916.86 916.86	916.76	916.65 916.61	126+00
--------	------------------	--------	------------------	--------	------------------	--------	------------------	----------------------------	--------	------------------	--------	------------------	--------	------------------	--------	------------------	--------	------------------	--------	------------------	--------	------------------	--------

SEC Group, Inc.
 An HR Group Company
 620 N. First Street,
 Moline, IL 61704-1000
 1-815-325-1778 | 1-815-325-1781
 www.secgroupinc.com
 4800 S.W. 11th Street, Miami, FL 33135

USER NAME =	CHa-uka
DESIGNED -	C. PIEPER
DRAWN -	R. BEST
CHECKED -	T. HAMILTON
DATE -	10/25/10
REVISIONS	
REVISED -	
REVISED -	
REVISED -	
REVISED -	

VILLAGE OF CARPENTERSVILLE

WATERMAIN AND SANITARY SEWER PLAN AND PROFILE
HAZARD ROAD

F.A. RTE.	SECTION	COUNTY	TOTAL SHEETS	SHEET NO.
•	06-00074-00-FP	KANE	211	73
* FAU 2414, FAU 1280, FAP 343		CONTRACT NO. 63504		
FED. ROAD DIST. NO.		ILLINOIS FED. AID PROJECT		

SCALE: 1" = 20' SHEET NO. 4 OF 20 SHEETS STA. 120+50 TO STA. 128+00