


 

PLAN	SURVEYED	DATE
	PLOTTED	
	CHECKED	
	BY	
	NO.	
	FILE NAME	
	DATE	

PROFILE	SURVEYED	DATE
	PLOTTED	
	CHECKED	
	BY	
	NO.	
	FILE NAME	
	DATE	

COMPANY NAME: SEC GROUP, INC.  
 PROJECT CONTACT: A. JAIN  
 ADDRESS: 400 N. MAIN ST., CARPENTERSVILLE, IL 61814  
 PHONE: 618-241-4444  
 FAX: 618-241-4445  
 EMAIL: a.jain@secgroup.com  
 PROJECT NO.: 06-00074-00-PP  
 SHEET NO.: 211  
 DATE: 11/11/2010

**WATERMAIN TAGS**  
 107 GATE VALVE IN VALVE BOX, 4"  
 STA. 128+67.27, 36.26' RT  
 RIM = 912.60  
 108 LINE STOP, 4"

**LEGEND**  
 ■ LINE STOP  
 ● VALVE IN VAULT  
 ● VALVE IN BOX  
 ■ BUFFALO BOX  
 ▨ CASING  
 ▼ FIRE HYDRANT  
 ▼ REDUCER  
 ▲ CAP EXIST.  
 — WATER MAIN

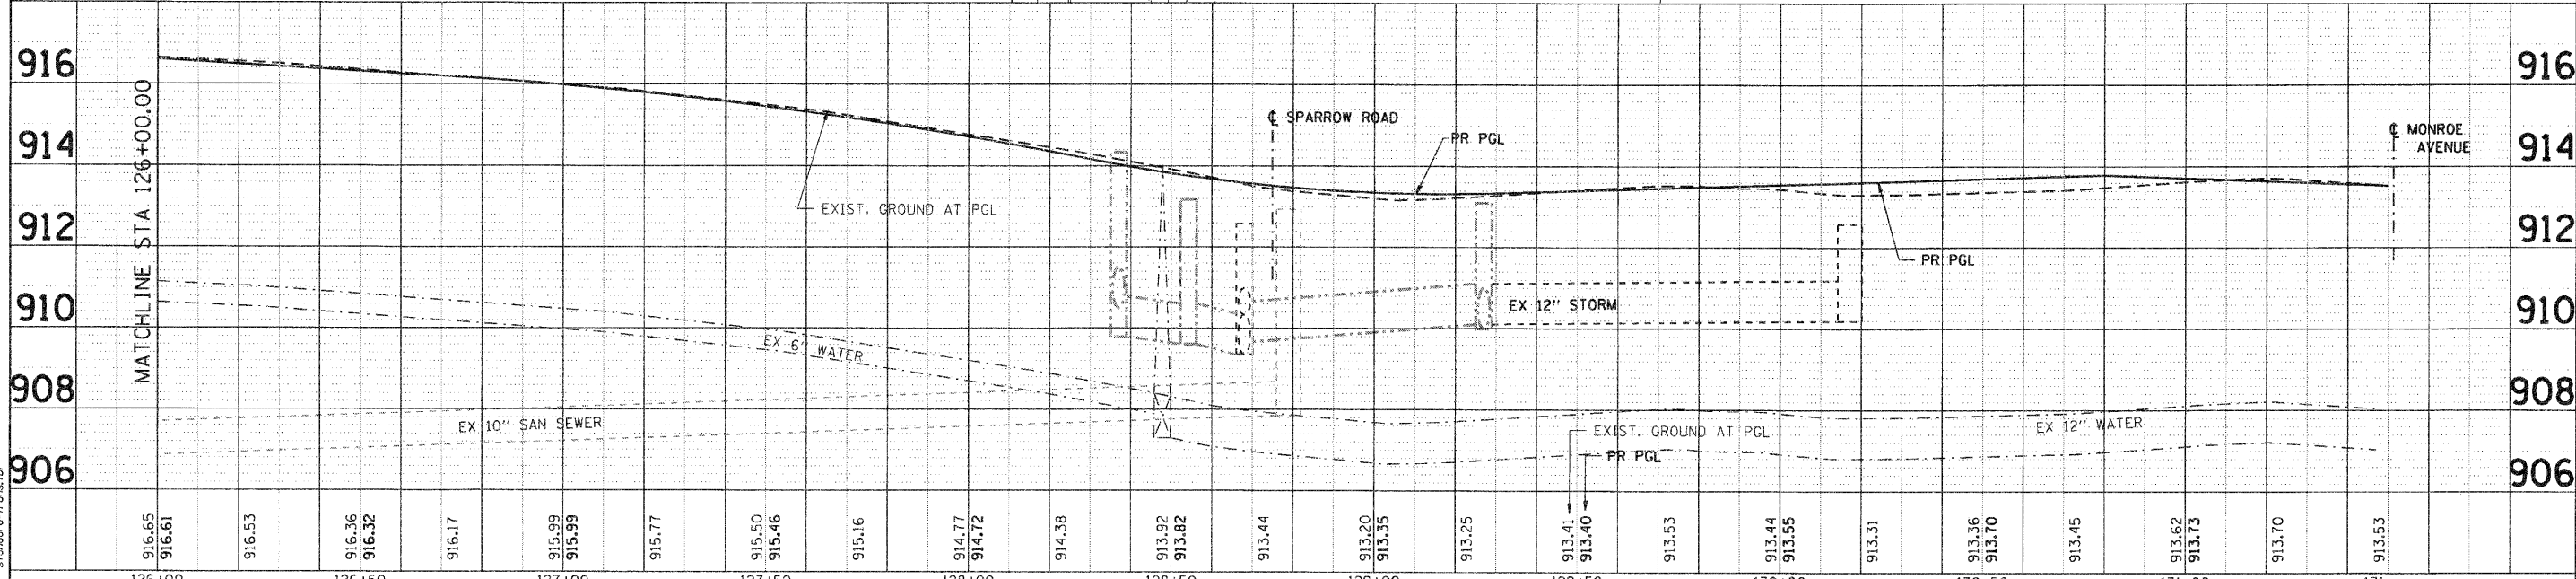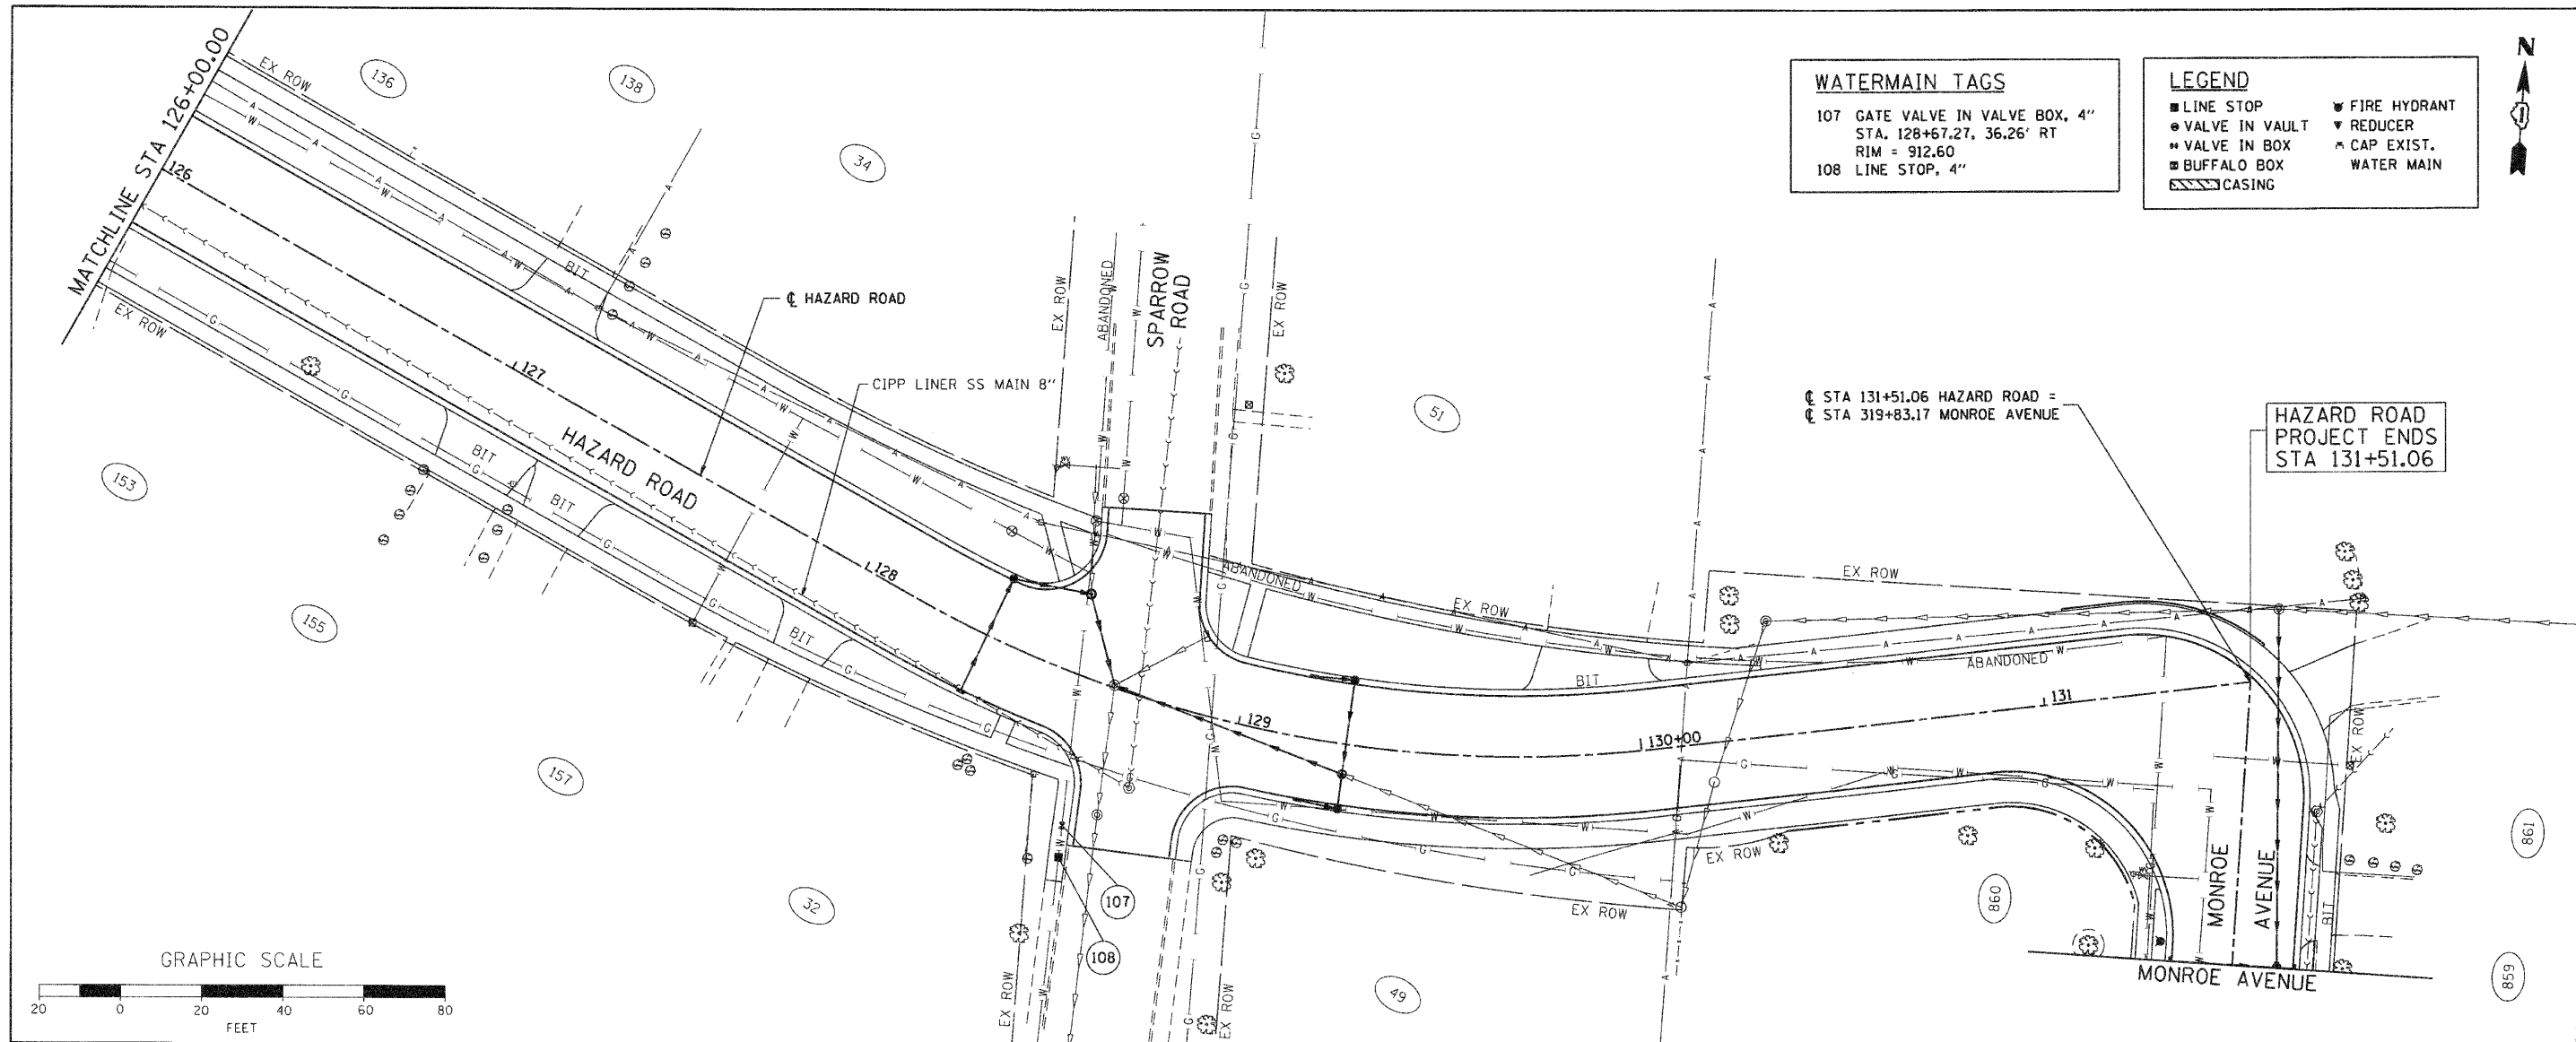

126+00	126+50	127+00	127+50	128+00	128+50	129+00	129+50	130+00	130+50	131+00	131+00
916.65	916.61	916.53	916.36	916.32	916.17	915.99	915.99	915.77	915.50	915.46	915.16
914.77	914.72	914.38	913.92	913.82	913.44	913.20	913.35	913.25	913.41	913.40	913.53
913.44	913.55	913.31	913.36	913.70	913.45	913.62	913.75	913.70	913.53		

**SEC Group, Inc.**  
 An HR Green Company  
 400 N. Main Street  
 Carpentersville, IL 61814  
 Phone: 618-241-4444  
 Fax: 618-241-4445  
 www.secgroup.com

USER NAME = Chh-tke  
 DESIGNED - C. PIEPER  
 DRAWN - R. BEST  
 CHECKED - T. HAMILTON  
 DATE - 10/25/10

**VILLAGE OF CARPENTERSVILLE**

**WATERMAIN AND SANITARY SEWER PLAN AND PROFILE**  
**HAZARD ROAD**

SECTION 06-00074-00-PP  
 COUNTY KANE  
 TOTAL SHEETS 211  
 SHEET NO. 74  
 CONTRACT NO. 63504  
 FED. ROAD DIST. NO. ILLINOIS FED. AID PROJECT

SCALE: 1" = 20' SHEET NO. 5 OF 20 SHEETS STA. 128+00 TO STA. END