


SIGN DETAIL  
1:75

EB-CL-109  
STA. 1083+10

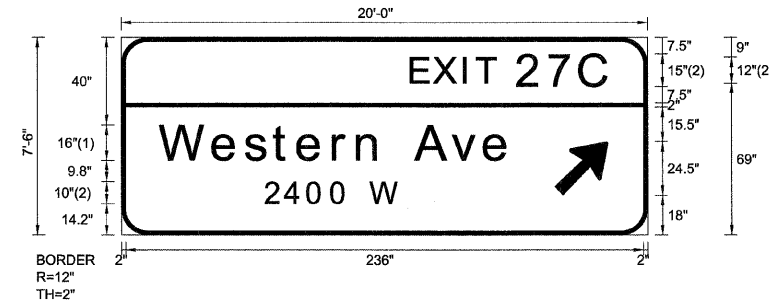

FONT:  
(1) ClearviewHwy-5-W-R  
(2) ClearviewHwy-5-W

Panel Style: sign\_default.ssi  
Dimensions are in inches.tenths

Letter locations are panel edge to lower left corner

SIGN NUMBER	name
WIDTH x HIGHT.	20'-0" x 7'-6"
BORDER WIDTH	2"
CORNER RADIUS	12"
MOUNTING	Overhead
BACKGROUND	TYPE: Reflective COLOR: Green
LEGEND/BORDER	TYPE: Reflective COLOR: White/White

SYMBOL	ROT	X	Y	WID	HT
ARMED	45	197.5	18	20	31.5

LETTER POSITIONS (X)

															LENGTH	SERIESSIZE		
E	X	I	T	2	7	C											ClearviewHwy-5-W	
132.7	143	156.7	162.6	181.2	195.4	209.8											89.3	12,15
W	e	s	t	e	r	n		A	v	e							ClearviewHwy-5-W-R	
18	42.2	56.9	69.7	80.9	97.1	108.1	119.1	134.6	151.2	165.9							159.6	1613
2	4	0	0		W												ClearviewHwy-5-W-R	
65.8	74.9	85.1	96	104.1	113.7												61.1	10

FILE NAME =	DESIGNED - SEW	REVISED -
*FILEL*	DRAWN - SEW	REVISED -
USER NAME = *USER*	CHECKED - SEW	REVISED -
PLOT DATE = *DATE*	DATE - 1/25/10	REVISED -



STATE OF ILLINOIS  
DEPARTMENT OF TRANSPORTATION

SIGNING DETAILS

SCALE: N.T.S. SHEET NO. 1 OF 46 SHEETS STA. TO STA.

F.A.I. RTE.	SECTION	COUNTY	TOTAL SHEETS	SHEET NO.
290	(2525, ETC., 2727) RS-8	COOK	201	109
FED. ROAD DIST. NO.		ILLINOIS FED. AID PROJECT		