


SIGN DETAIL  
1:75

EB-BM-116  
STA. 1118+00

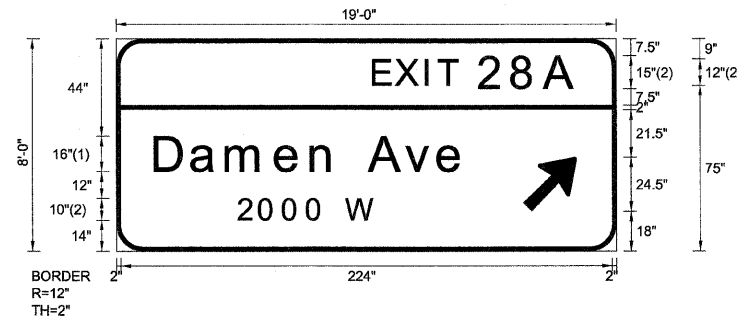

FONT:  
(1) ClearviewHwy-5-W-R  
(2) ClearviewHwy-5-W

Panel Style: sign\_default.ssi  
Dimensions are in inches.tenths

Letter locations are panel edge to lower left corner

SIGN NUMBER	name
WIDTH x HGHT.	19'-0" x 8'-0"
BORDER WIDTH	2"
CORNER RADIUS	12"
MOUNTING	Overhead
BACKGROUND	TYPE: Reflective COLOR: Green
LEGEND/BORDER	TYPE: Reflective COLOR: White/White

SYMBOL	ROT	X	Y	WID	HT
ARMED	45	185.5	18	20	31.5

LETTER POSITIONS (X)																		LENGTH	SERIESSIZE
E	X	I	T	2	8	A												ClearviewHwy-5-W	
117.7	128	141.6	147.6	166.2	181.3	196												92.3	12,15
D	a	m	e	n		A	v	e										ClearviewHwy-5-W-R	
18	34.5	50.5	73	89.2	100.3	115.7	132.3	147										140.7	1613
2	0	0	0		W													ClearviewHwy-5-W-R	
55.8	65.4	76.3	87.2	95.3	104.8													62.3	10

FILE NAME =	DESIGNED - SEW	REVISED -
*FILE#*	DRAWN - SEW	REVISED -
USER NAME = #USER#	CHECKED - SEW	REVISED -
PLOT DATE = #DATE#	DATE - 1/25/10	REVISED -



STATE OF ILLINOIS  
DEPARTMENT OF TRANSPORTATION

SIGNING DETAILS		
SCALE: N.T.S.	SHEET NO. 6 OF 46 SHEETS	STA. TO STA.

F.A.I. RTE.	SECTION	COUNTY	TOTAL SHEETS	SHEET NO.
290	(2525, ETC., 2727) RS-8	COOK	201	114
FED. ROAD DIST. NO.		ILLINOIS FED. AID PROJECT		