


SIGN DETAIL
1:75

EB-CL-119
STA. 1138+50

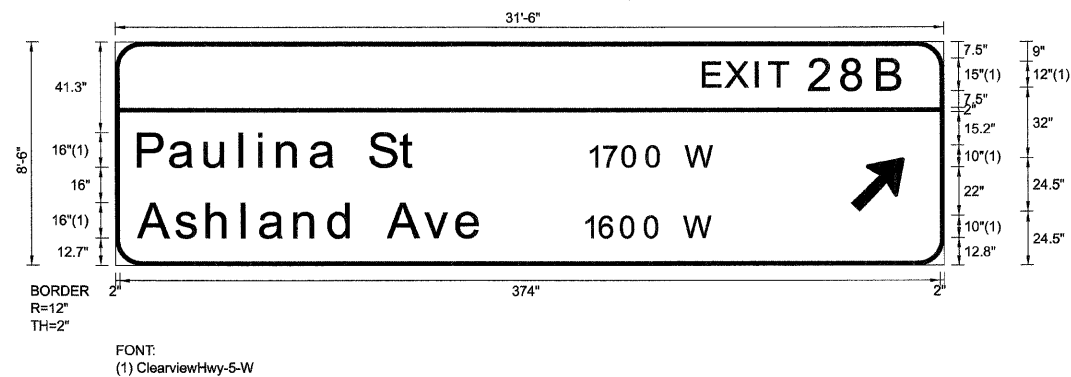

SIGN NUMBER	name		
WIDTH x HGHT.	31'-6" x 8'-6"		
BORDER WIDTH	2"		
CORNER RADIUS	12"		
MOUNTING	Overhead		
BACKGROUND	TYPE:	Reflective	
	COLOR:	Green	
LEGEND/BORDER	TYPE:	Reflective	
	COLOR:	White/White	

Panel Style: sign_default.ssi
Dimensions are in inches.tenths

Letter locations are panel edge to lower left corner

SYMBOL	ROT	X	Y	WID	HT
ARMED	45	335.5	24.5	20	31.5

LETTER POSITIONS (X)														LENGTH	SERIESIZE			
E	X	I	T	2	8	B											ClearviewHwy-5-W	
268.8	279	292.7	298.6	317.2	332.3	348.6											91.3	12,15
P	a	u	l	i	n	a	S	t										ClearviewHwy-5-W-R
10.8	25.4	41.4	57.3	65.9	74.4	89.6	101.4	116.4	130.5								127.5	1613
1	7	0	0		W													ClearviewHwy-5-W-R
215.7	222.6	231.7	242.6	250.8	260.3												57.8	10
A	s	h	l	a	n	d	A	v	e									ClearviewHwy-5-W-R
10.8	27.9	42.2	58.4	66.3	82.3	97.8	109.3	124.8	141.4	156.1							157	1613
1	6	0	0		W													ClearviewHwy-5-W-R
213.7	221.2	231	241.9	250	259.5												59.1	10

FILE NAME =	DESIGNED - SEW	REVISED -
#FILEL#	DRAWN - SEW	REVISED -
USER NAME = #USER#	CHECKED - SEW	REVISED -
PLOT DATE = #DATE#	DATE - 1/25/10	REVISED -



STATE OF ILLINOIS
DEPARTMENT OF TRANSPORTATION

SIGNING DETAILS	
SCALE: N.T.S.	SHEET NO. 8 OF 46 SHEETS
STA.	TO STA.

F.A.I. RTE.	SECTION	COUNTY	TOTAL SHEETS	SHEET NO.
290	(2525, ETC., 2727) RS-8	COOK	201	116
FED. ROAD DIST. NO.		ILLINOIS FED. AID PROJECT		
		CONTRACT NO. 60K11		