


SIGN DETAIL  
1:75

EB-BM-126  
STA. 1184+20

SIGN NUMBER	name
WIDTH x HGHT.	19'-0" x 9'-0"
BORDER WIDTH	2"
CORNER RADIUS	12"
MOUNTING	Overhead
BACKGROUND	TYPE: Reflective
	COLOR: Green
LEGEND/BORDER	TYPE: Reflective
	COLOR: White/White

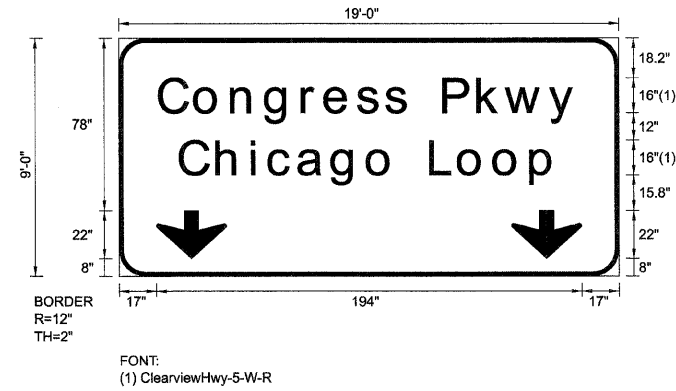

Panel Style: sign\_default.ssi  
Dimensions are in inches.tenths

Letter locations are panel edge to lower left corner

SYMBOL	ROT	X	Y	WID	HT
ARDOWN	0	17	8	32	22
ARDOWN	0	179	8	32	22

LETTER POSITIONS (X)													LENGTH	SERIESIZE		
C	o	n	g	r	e	s	s		P	k	w	y				ClearviewHwy-5-W-R
18.8	35	51.8	67.3	84.1	94.4	109.2	122.1	132.3	148.5	164.1	176.8	196.7				190.3 1613
C	h	i	c	a	g	o		L	o	o	p					ClearviewHwy-5-W-R
28.2	45.1	60.9	68.8	82.3	97.6	113.7	126	142.6	155.3	171.4	188.2					171.5 1613

FILE NAME =	DESIGNED - SEW	REVISED -
*FILE#	DRAWN - SEW	REVISED -
USER NAME = #USER#	CHECKED - SEW	REVISED -
PLOT DATE = #DATE#	DATE - 1/25/10	REVISED -



STATE OF ILLINOIS  
DEPARTMENT OF TRANSPORTATION

SIGNING DETAILS  
SCALE: N.T.S. SHEET NO. 13 OF 46 SHEETS STA. TO STA.

F.A.I. RTE.	SECTION	COUNTY	TOTAL SHEETS	SHEET NO.
290	(2525, ETC., 2727) RS-8	COOK	201	121
CONTRACT NO. 60K11			FED. ROAD DIST. NO. [ILLINOIS] FED. AID PROJECT	