


SIGN DETAIL
1:75

EB-BM-127
STA. 1184+20

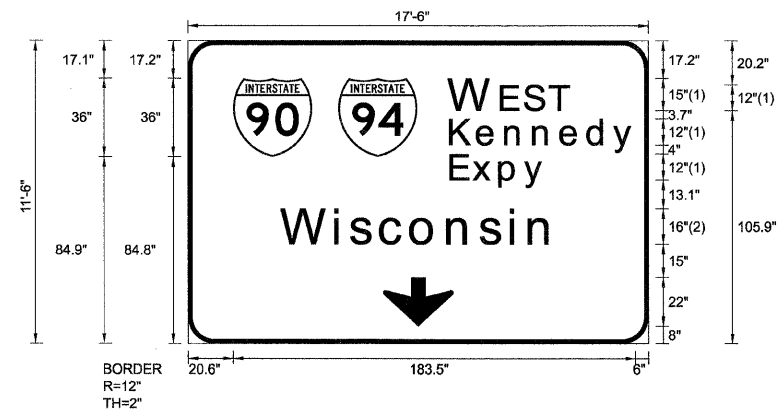

| | |
|---------------|--|
| SIGN NUMBER | name |
| WIDTH x HGHT. | 17'-6" x 11'-6" |
| BORDER WIDTH | 2" |
| CORNER RADIUS | 12" |
| MOUNTING | Overhead |
| BACKGROUND | TYPE: Reflective COLOR: Green |
| LEGEND/BORDER | TYPE: Reflective COLOR: White/White |

| SYMBOL | ROT | X | Y | WID | HT |
|--------|-----|------|------|-----|----|
| M1_1 | 0 | 20.6 | 84.8 | 36 | 36 |
| M1_1 | 0 | 68.6 | 84.9 | 36 | 36 |
| ARDOWN | 0 | 89 | 8 | 32 | 22 |

Panel Style: sign_default.ssi
Dimensions are in inches.tenths

FONT:
(1) ClearviewHwy-5-W
(2) ClearviewHwy-5-W-R

Letter locations are panel edge to lower left corner

| LETTER POSITIONS (X) | | | | | | | | | | LENGTH | SERIESSIZE |
|----------------------|-------|-------|-------|-------|-------|-------|-------|-----|--|--------|--------------------|
| W | E | S | T | | | | | | | | ClearviewHwy-5-W |
| 119.6 | 143.3 | 154 | 165.5 | | | | | | | 54.5 | 15,12 |
| K | e | n | n | e | d | y | | | | | ClearviewHwy-5-W |
| 120.3 | 132.5 | 145.3 | 158.2 | 170.5 | 182.9 | 194.7 | | | | 83.8 | 129.8 |
| E | x | p | y | | | | | | | | ClearviewHwy-5-W |
| 120.4 | 130.4 | 142.7 | 154 | | | | | | | 42.9 | 129.8 |
| W | i | s | c | o | n | s | i | n | | | ClearviewHwy-5-W-R |
| 42.9 | 67.4 | 74.5 | 88.2 | 102 | 118.8 | 133.5 | 147.5 | 156 | | 124.1 | 16/13 |

| | | |
|--------------------|----------------|-----------|
| FILE NAME = | DESIGNED - SEW | REVISED - |
| #FILE# | DRAWN - SEW | REVISED - |
| USER NAME = #USER# | CHECKED - SEW | REVISED - |
| PLOT DATE = #DATE# | DATE - 1/25/10 | REVISED - |



STATE OF ILLINOIS
DEPARTMENT OF TRANSPORTATION

SIGNING DETAILS

SCALE: N.T.S. SHEET NO. 14 OF 46 SHEETS STA. TO STA.

| | | | | |
|---|-------------------------|--------|--------------------|-----------|
| F.A.I. RTE. | SECTION | COUNTY | TOTAL SHEETS | SHEET NO. |
| 290 | (2525, ETC., 2727) RS-8 | COOK | 201 | 122 |
| FED. ROAD DIST. NO. [ILLINOIS] FED. AID PROJECT | | | CONTRACT NO. 60K11 | |