


SIGN DETAIL
1:75

EB-TR-131
STA. 1208+20

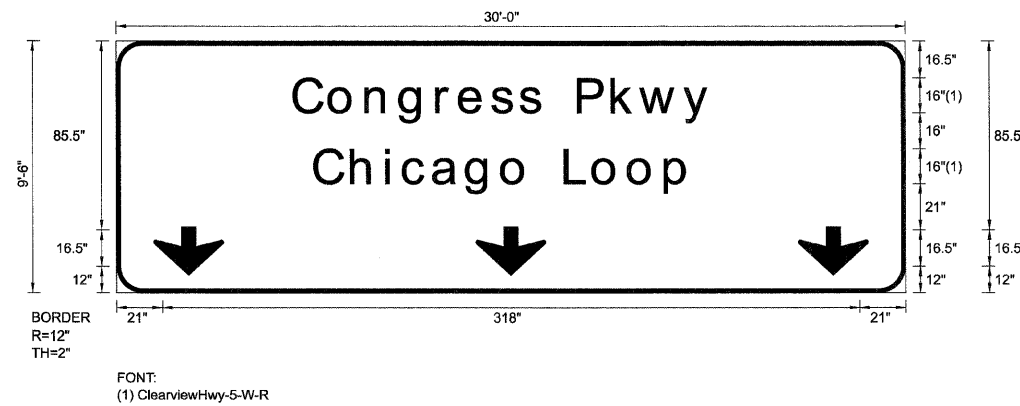

SIGN NUMBER	name
WIDTH x HGHT.	30'-0" x 9'-6"
BORDER WIDTH	2"
CORNER RADIUS	12"
MOUNTING	Overhead
BACKGROUND	TYPE: Reflective COLOR: Green
LEGEND/BORDER	TYPE: Reflective COLOR: White/White

SYMBOL	ROT	X	Y	WID	HT
ARROW	0	17	8	32	22
ARROW	0	164	8	32	22
ARROW	0	311	8	32	22

Panel Style: sign_default.ssi
Dimensions are in inches.tenths

Letter locations are panel edge to lower left corner

LETTER POSITIONS (X)													LENGTH	SERIESIZE
C	o	n	g	r	e	s	s		P	k	w	y		ClearviewHwy-5-W-R
81.5	97.6	114.4	130	146.7	157	171.8	184.7	194.9	211.2	226.7	239.4	259.3	190.3	1613
C	h	i	c	a	g	o		L	o	o	p			ClearviewHwy-5-W-R
90.9	107.7	123.5	131.4	144.9	160.2	176.3	188.6	205.2	217.9	234	250.8		171.5	1613

FILE NAME =	DESIGNED - SEW	REVISED -
#FILE#	DRAWN - SEW	REVISED -
USER NAME = #USER#	CHECKED - SEW	REVISED -
PLOT DATE = #DATE#	DATE - 1/25/10	REVISED -



STATE OF ILLINOIS
DEPARTMENT OF TRANSPORTATION

SIGNING DETAILS

SCALE: N.T.S. SHEET NO. 18 OF 46 SHEETS STA. TO STA.

F.A.I. RTE.	SECTION	COUNTY	TOTAL SHEETS	SHEET NO.
290	(2525, ETC., 2727) RS-8	COOK	201	126
FED. ROAD DIST. NO. [ILLINOIS] FED. AID PROJECT			CONTRACT NO. 60K11	