


SIGN DETAIL

1:75

EB-TR-134
STA. 1210+50

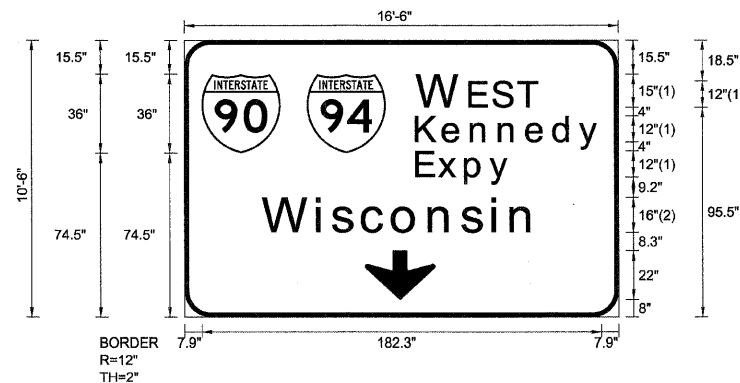

BORDER
R=12"
TH=2"

FONT:
(1) ClearviewHwy-5-W
(2) ClearviewHwy-5-W-R

Panel Style: sign_default.ssi
Dimensions are in inches.tenths

Letter locations are panel edge to lower left corner

SIGN NUMBER	name
WIDTH x HGHT.	16'-6" x 10'-6"
BORDER WIDTH	2"
CORNER RADIUS	12"
MOUNTING	Overhead
BACKGROUND	TYPE: Reflective COLOR: Green
LEGENDBORDER	TYPE: Reflective COLOR: WhiteWhite

SYMBOL	ROT	X	Y	WID	HT
M1_1	0	7.9	74.5	36	36
M1_1	0	55.9	74.5	36	36
ARDOWN	0	82.3	8	32	22

LETTER POSITIONS (X)

									LENGTH	SERIESIZE
W	E	S	T							ClearviewHwy-5-W
106.9	130.6	141.3	152.7						54.5	15,12
K	e	n	n	e	d	y				ClearviewHwy-5-W
106.3	118.5	131.4	144.2	156.6	169	180.8			83.8	129.8
E	x	p	y							ClearviewHwy-5-W
106.3	116.4	128.6	139.9						42.9	129.8
W	i	s	c	o	n	s	i	n		ClearviewHwy-5-W-R
36.2	60.7	67.7	81.4	95.3	112.1	126.8	140.8	149.3	124.1	1613

FILE NAME =	DESIGNED - SEW	REVISED -
#FILE#	DRAWN - SEW	REVISED -
USER NAME = #USER#	CHECKED - SEW	REVISED -
PLOT DATE = #DATE#	DATE - 1/25/10	REVISED -



**STATE OF ILLINOIS
DEPARTMENT OF TRANSPORTATION**

SIGNING DETAILS

SCALE: N.T.S. SHEET NO. 21 OF 46 SHEETS STA. TO STA.

F.A.I. RTE.	SECTION	COUNTY	TOTAL SHEETS	SHEET NO.
290	(2525, ETC., 2727) RS-8	COOK	201	129
FED. ROAD DIST. NO.			ILLINOIS FED. AID PROJECT	

CONTRACT NO. 60K11