


SIGN DETAIL
1:75

WB-BM-133
STA. 1132+20

SIGN NUMBER	name
WIDTH x HGHT.	19'-0" x 8'-0"
BORDER WIDTH	2"
CORNER RADIUS	12"
MOUNTING	Overhead
BACKGROUND	TYPE: Reflective COLOR: Green
LEGEND/BORDER	TYPE: Reflective COLOR: White/White

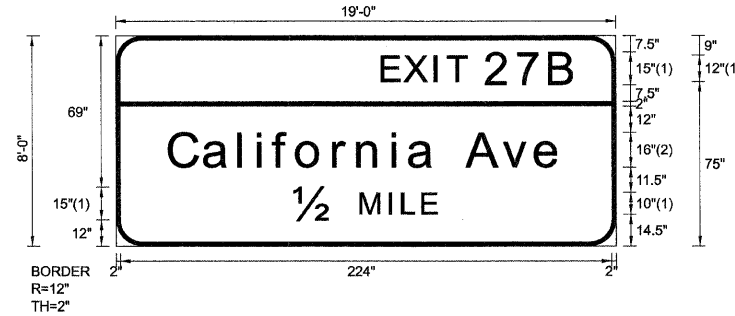

FONT:
(1) ClearviewHwy-S-W
(2) ClearviewHwy-S-W-R

Panel Style: sign_default.ssi
Dimensions are in inches.tenths

Letter locations are panel edge to lower left corner

SYMBOL	ROT	X	Y	WID	HT

LETTER POSITIONS (X)

													LENGTH	SERIESSIZE	
E	X	I	T	2	7	B								ClearviewHwy-5-W	
122	132.2	145.9	151.8	169.4	183.6	198.6							88	12,15	
C	a	I	i	f	o	r	n	i	a	A	v	e		ClearviewHwy-5-W-R	
24.6	40.5	56.5	65	72.2	82.9	99.7	110.7	126.5	134	145.9	160.4	176.9	191.6	178.8	1613
12	M	I	L	E											ClearviewHwy-5-W
81.6	111.9	125.1	131	140										64.8	15,10

FILE NAME =	DESIGNED - SEW	REVISED -
FILEL	DRAWN - SEW	REVISED -
USER NAME = *USER*	CHECKED - SEW	REVISED -
PLOT DATE = *DATE*	DATE - 1/25/10	REVISED -



STATE OF ILLINOIS
DEPARTMENT OF TRANSPORTATION

SIGNING DETAILS			
SCALE: N.T.S.	SHEET NO. 29 OF 46 SHEETS	STA.	TO STA.

F.A.I. RTE.	SECTION	COUNTY	TOTAL SHEETS	SHEET NO.
290	(2525, ETC., 2727) RS-8	COOK	201	136
FED. ROAD DIST. NO.				ILLINOIS FED. AID PROJECT
				CONTRACT NO. 60K11