


SIGN DETAIL  
1:75

WB-BM-147  
STA. 1205+60

SIGN NUMBER	name
WIDTH x HGHT.	18'-0" x 7'-6"
BORDER WIDTH	2"
CORNER RADIUS	12"
MOUNTING	Overhead
BACKGROUND	TYPE: Reflective COLOR: Green
LEGEND/BORDER	TYPE: Reflective COLOR: White/White

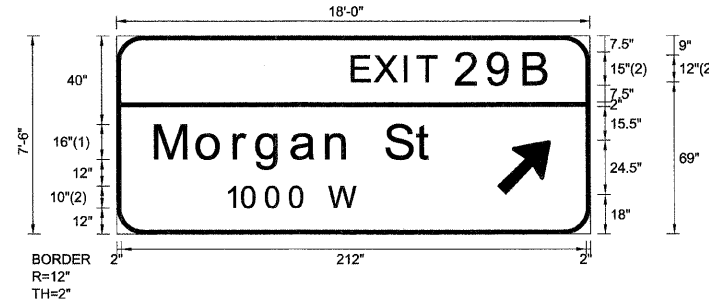

FONT:  
(1) ClearviewHwy-5-W-R  
(2) ClearviewHwy-5-W

Panel Style: sign\_default.ssi  
Dimensions are in inches.tenths

Letter locations are panel edge to lower left corner

SYMBOL	ROT	X	Y	WID	HT
ARMED	45	173.5	18	20	31.5

LETTER POSITIONS (X)

LENGTH      SERIESIZE

Letter	X	Y	Length	Seriesize
E	108	118.2	90.1	ClearviewHwy-5-W
X	131.9	137.8	12.15	ClearviewHwy-5-W-R
I	155.4	170.4	16.13	ClearviewHwy-5-W-R
T	170.4	186.6	12.15	ClearviewHwy-5-W
2	186.6	170.4	16.13	ClearviewHwy-5-W-R
9	170.4	186.6	12.15	ClearviewHwy-5-W
B	186.6	170.4	16.13	ClearviewHwy-5-W-R
M	37.3	54	127	16/13
o	64.4	80.2	127	16/13
r	80.2	96.1	127	16/13
g	96.1	107.2	127	16/13
a	107.2	123.1	127	16/13
n	123.1	137.2	127	16/13
S	137.2	107.2	127	16/13
t	153.3	107.2	127	16/13
1	49.9	57.5	60.3	10
0	68.4	79.3	60.3	10
0	87.5	79.3	60.3	10
0	106.6	79.3	60.3	10
W	125.7	79.3	60.3	10

FILE NAME =	DESIGNED - SEW	REVISED -
*FILEL*	DRAWN - SEW	REVISED -
USER NAME = #USER#	CHECKED - SEW	REVISED -
PLOT DATE = #DATE#	DATE - 1/25/10	REVISED -



STATE OF ILLINOIS  
DEPARTMENT OF TRANSPORTATION

SIGNING DETAILS

F.A.I. RTE.	SECTION	COUNTY	TOTAL SHEETS	SHEET NO.
290	(2525, ETC., 2727) RS-8	COOK	201	147
FED. ROAD DIST. NO. [ILLINOIS] FED. AID PROJECT			CONTRACT NO. 60K11	

SCALE: N.T.S. SHEET NO. 40 OF 46 SHEETS STA. TO STA.