


SIGN DETAIL
1:75

WB-GM-150
STA. 1213+10

SIGN NUMBER	name
WIDTH x HGHT.	25'-6" x 9'-0"
BORDER WIDTH	2"
CORNER RADIUS	12"
MOUNTING	Overhead
BACKGROUND	TYPE: Reflective
	COLOR: White
LEGEND/BORDER	TYPE: Reflective
	COLOR: Red/Black

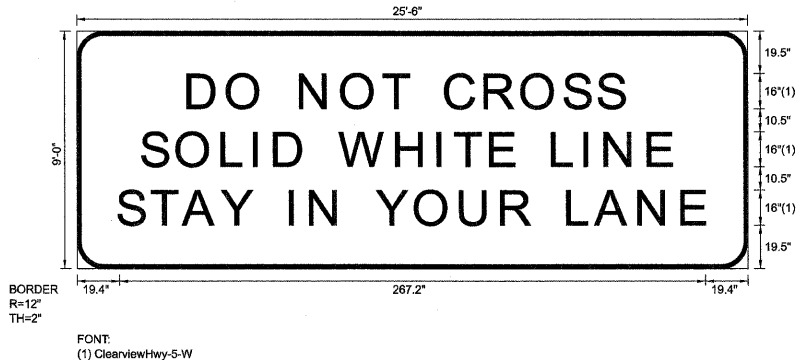

Panel Style: Regulatory_Signs.ssi
Dimensions are in inches.tenths

Letter locations are panel edge to lower left corner

SYMBOL	ROT	X	Y	WID	HT

LETTER POSITIONS (X)																				LENGTH	SERIESSIZE								
D	O		N	O	T		C	R	O	S	S											198.6	16	ClearviewHwy-5-W					
51.5	69.4	84.2	102.7	121.6	140.5	152.1	169	186.9	203.8	223	238.6																		
S	O	L	I	D		W	H	I	T	E		L	I	N	E										241.1	16	ClearviewHwy-5-W		
30.2	46.4	67	81.4	90.9	103.8	120.7	146.6	165.2	173.1	189.4	199.5	217.7	232.2	241.7	261.2														
S	T	A	Y		I	N		Y	O	U	R		L	A	N	E											267.2	16	ClearviewHwy-5-W
19.4	34.6	49.2	66.7	80.7	97.8	107.3	120.4	137.4	155.1	175.6	194.4	206.3	224.6	237.3	256.9	276.4													

FILE NAME =	DESIGNED - SEW	REVISED -
#FILE#	DRAWN - SEW	REVISED -
USER NAME = \$USER\$	CHECKED - SEW	REVISED -
PLOT DATE = \$DATE\$	DATE - 1/25/10	REVISED -

E LIN ENGINEERING, LTD.
Consulting Engineers
Chattanooga, Illinois Westmont, Illinois

STATE OF ILLINOIS
DEPARTMENT OF TRANSPORTATION

SIGNING DETAILS

SCALE: N.T.S. SHEET NO. 42 OF 46 SHEETS STA. TO STA.

F.A.I. RTE.	SECTION	COUNTY	TOTAL SHEETS	SHEET NO.
290	(2525, ETC., 2727) RS-8	COOK	201	149
FED. ROAD DIST. NO.		ILLINOIS FED. AID PROJECT		

CONTRACT NO. 60K11