
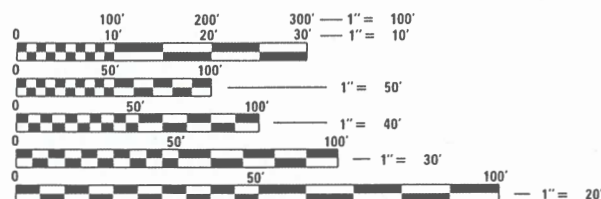
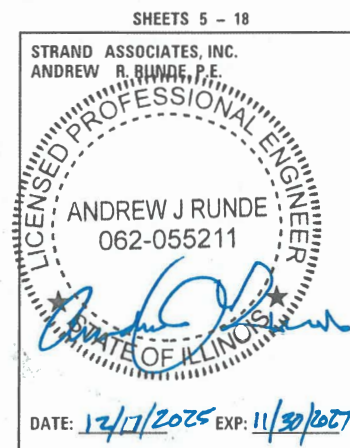


FEDERAL AID PROGRAM ENGINEER: CARMEN E. RAMOS, P.E., SCHAUMBURG, IL

02-27-2026 LETTING ITEM 076

FOR INDEX OF SHEETS, SEE SHEET NO. 2  
FOR INDEX OF HIGHWAY STANDARDS, SEE SHEET NO. 2

TRAFFIC DATA  
IL 50 (CICERO AVENUE): PRINCIPAL ARTERIAL  
POSTED SPEED = 35 MPH  
2023 ADT: 36,300 - 42,200

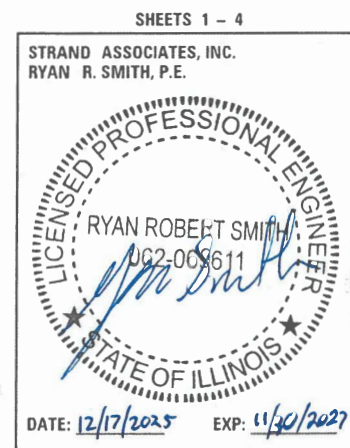

FULL SIZE PLANS HAVE BEEN PREPARED USING STANDARD  
ENGINEERING SCALES. REDUCED SIZED PLANS WILL NOT  
CONFORM TO STANDARD SCALES. IN MAKING MEASUREMENTS  
ON REDUCED PLANS, THE ABOVE SCALES MAY BE USED.

J.U.L.I.E.  
JOINT UTILITY LOCATION INFORMATION FOR EXCAVATION  
1-800-892-0123  
OR 811

CONTRACT NO. 61M20


STATE OF ILLINOIS  
DEPARTMENT OF TRANSPORTATION  
**PLANS FOR PROPOSED  
FEDERAL AID HIGHWAY**

FAP ROUTE 350  
IL ROUTE 50 (CICERO AVENUE)  
87TH STREET TO 111TH STREET  
LED REPLACEMENT PROJECT  
SECTION 24-00199-00-LT  
PROJECT NO. M5S0(316)  
VILLAGE OF OAK LAWN  
COOK COUNTY

BEGIN IMPROVEMENT  
87TH STREET

C-91-195-25  
RANGE 9 E, 3rd P.M.

TWP. 34 N

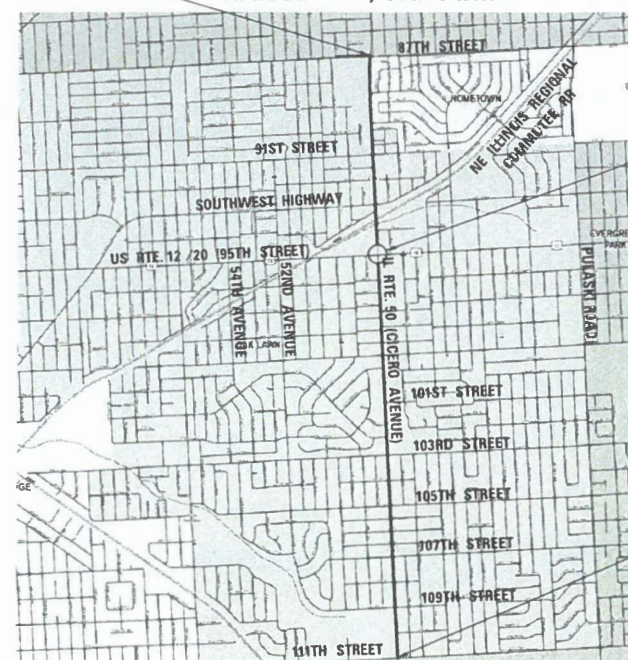

LOCATION MAP

NOT TO SCALE

GROSS LENGTH = 3.02 MILE = 15,945 FEET

NET LENGTH = 2.97 MILE = 15,670 FEET

PROJECT OMISSION AT  
THE INTERSECTION OF  
US 12 /20 (95TH STREET)

END IMPROVEMENT  
111TH STREET



STATE OF ILLINOIS  
DEPARTMENT OF TRANSPORTATION

APPROVED: *[Signature]* 12/19/2025  
VILLAGE OF OAK LAWN, DIRECTOR OF PUBLIC WORKS

PASSED: December 19, 2025  
C. F. Riddle JAF  
DISTRICT ENGINEER OF LOCAL ROADS & STREETS

RELEASING FOR  
BID BASED ON  
LIMITED REVIEW: Dec 19, 2025  
[Signature] IR  
REGIONAL ENGINEER

PRINTED BY THE AUTHORITY  
OF THE STATE OF ILLINOIS

INDEX OF SHEETS

SHEET NO. DESCRIPTION

1	COVER SHEET
2	GENERAL NOTES, INDEX OF SHEETS, STANDARDS, AND MAINTAINANCE OF TRAFFIC NOTES
3	SUMMARY OF QUANTITIES
4	EXISTING AND PROPOSED TYPICAL SECTION
5 - 16	REMOVAL AND PROPOSED LIGHTNING DRAWINGS
17 - 18	DISTRICT 1 STANDARDS

HIGHWAY STANDARDS

000001-09	STANDARD SYMBOLS, ABBREVIATIONS, AND PATTERNS
001006	DECIMAL OF AN INCH AND OF A FOOT
701101-05	OFF-ROAD OPERATIONS, MULTILANE, 15' (4.5 M) TO 24" (600 MM) FROM PAVEMENT EDGE
701427-05	LANE CLOSURE, MULTILANE, INTERMITTENT OR MOVING OPERATIONS, FOR SPEEDS ≤ 40 MPH
701602-10	URBAN LANE CLOSURE, MULTILANE, 2W WITH BIDIRECTIONAL LEFT TURN LANE
701701-10	URBAN LANE CLOSURE, MULTILANE INTERSECTION
701801-06	SIDEWALK, CORNER OR CORSSWALK CLOSURE
701901-11	TRAFFIC CONTROL DEVICES

DISTRICT ONE STANDARDS

BE-701	LUMINAIRE SAFETY CABLE ASSEMBLY
BE-702	MISCELLANEOUS ELECTRICAL DETAILS, SHEET A - (CABLE SPLICE, POLE WIRING, TRENCH DETAIL)

GENERAL NOTES

1.

ALL CONSTRUCTION SHALL BE DONE IN ACCORDANCE WITH THE DETAILS IN THE PLANS, THE SPECIAL PROVISIONS INCLUDED IN THE CONTRACT DOCUMENTS, THE STATE OF ILLINOIS "STANDARD SPECIFICATIONS FOR ROAD AND BRIDGE CONSTRUCTION" (STANDARD SPECIFICATIONS) ADOPTED JANUARY 1, 2022, THE "SUPPLEMENTAL SPECIFICATIONS AND RECURRING SPECIAL PROVISIONS" ADOPTED JAN. 1, 2026, THE DETAILS IN THESE PLANS, AND THE SPECIAL PROVISIONS INCLUDED IN THE CONTRACT DOCUMENTS.
2.

THE CONTRACTOR SHALL NOTIFY OAK LAWN PUBLIC WORKS (708-499-7756) AT LEAST 48 HOURS IN ADVANCE OF BEGINNING WORK.
3.

THE CONTRACTOR SHALL CONTACT KALPANA KANNAN-HOSADURGA, THE IDOT ARTERIAL DISTRICT ONE TRAFFIC CONTROL SUPERVISOR, AT KALPANA KANNAN-HOSADURGA@ILLINOIS.GOV A MINIMUM OF 72 HOURS IN ADVANCE OF BEGINNING WORK.

4.

LOCATIONS OF LIGHT POLES SHOWN ON THESE DRAWINGS IS APPROXIMATE BASED ON A LIMITED AMOUNT OF AS-BUILT DRAWINGS, AERIAL PHOTOGRAPHY, STREETVIEW PHOTOGRAPHY, AND GIS INFORMATION. IT SHALL BE THE RESPONSIBILITY OF THE CONTRACTOR TO ASCERTAIN THE EXISTING LIGHTING CONTROLLER LOCATIONS AND BRANCH CIRCUITRY IN ORDER TO COMPLETE THIS WORK. THE CONTRACTOR SHALL COORDINATE WITH THE VILLAGE OF OAK LAWN PUBLIC WORKS TO REQUEST AVAILABLE RECORD DRAWINGS AND FOR ADDITIONAL INFORMATION ABOUT THE LIGHTING SYSTEM.
5.

IT WILL BE THE CONTRACTOR'S RESPONSIBILITY TO NOTIFY THE ENGINEER, RESIDENTS, BUSINESS OWNERS, AND THE VILLAGE OF OAK LAWN WHEN ACCESS TO SIDEWALKS, CURB RAMPS, DRIVEWAYS, AND BUSINESSES WILL BE TEMPORARILY CLOSED DUE TO THE LED LUMINAIRE REPLACEMENT.
6.

CONTRACTOR SHALL COORDINATE WORK SUCH THAT ACCESS IS MAINTAINED FOR OPERATIONS OF PACE TRANSIT AND BUS SERVICES
7.

THE CONTRACTOR SHALL TAKE ALL NECESSARY PRECAUTIONS FOR THE PROTECTION OF EXISTING PLANT MATERIAL FOR WHICH THE CONTRACT DOES NOT PROVIDE REMOVAL. THE PROTECTION OF EXISTING PLANT MATERIAL AND THE REPAIR OR REPLACEMENT OF EXISTING PLANT MATERIAL DAMAGED BY THE CONTRACTOR SHALL BE DONE IN ACCORDANCE WITH THE REQUIREMENTS OF SECTION 201 OF THE STANDARD SPECIFICATIONS.
8.

IT SHALL BE THE CONTRACTOR'S RESPONSIBILITY TO VERIFY ALL THE DIMENSIONS AND CONDITIONS EXISTING IN THE FIELD PRIOR TO CONSTRUCTION AND ORDERING OF MATERIALS.
9.

ANY REFERENCE TO STANDARDS THROUGHOUT THE PLANS OR SPECIAL PROVISIONS SHALL BE INTERPRETED TO BE THE LATEST STANDARDS OF THE ILLINOIS DEPARTMENT OF TRANSPORTATION.
10.

UPON COMPLETION OF THIS CONTRACT, THE CONTRACTOR SHALL PROVIDE A COMPLETE SET OF RECORD DRAWINGS TO THE VILLAGE OF OAK LAWN, THE RECORD DRAWINGS SHALL BE COMPLETED IN ACCORDANCE WITH ACCORDING TO SECTION 801.16 OF THE STANDARD SPECIFICATIONS. EXISTING INVENTORY AND CIRCUITING SHALL BE NOTED ON A COPY OF THE CONTRACT DRAWINGS.
11.

ALL EXISTING HPS LUMINAIRES WHICH ARE BEING REMOVED SHALL BE SALVAGED TO THE VILLAGE OF OAK LAWN. CONTACT THE PUBLIC WORKS DEPARTMENT TO COORDINATE THE DELIVERY OF THE HPS LUMINAIRES.
12.

IDOT DISTRICT ONE MAINTANANCE STAFF SHALL BE NOTIFIED AT LEAST 48 HOURS IN ADVANCE OF REPLACEMENT OF LUMINAIRES THAT ARE ATTACHED TO AN IDOT MAINTAINED COMBINATION TRAFFIC SIGNAL MAST ARMS.
13.

ALL LUMINAIRES SHALL BE ORIENTED WITH THE OPTICS PERPENDICULAR TO THE ROADWAY UNLESS NOTED OTHERWISE OR DIRECTED BY THE ENGINEER, THE LUMINAIRES MAY REQUIRE NIGHT-TIME OPTICAL ADJUSTMENT UPON INSPECTION BY THE ENGINEER.
14.

SPLICING OF CONDUCTORS SHALL BE IN POLE BASES OR ABOVE-GRADE WEATHER TIGHT JUNCTION BOXES ONLY. SPLICES BELOW GRADE WILL NOT BE PERMITTED.
15.

IT SHALL BE THE RESPONSIBILITY OF THE CONTRACTOR TO OBTAIN ANY REQUIRED PERMITS AND COORDINATE WORK IN CLOSE PROXIMITY TO ANY EXISTING AERIAL PRIVATE UTILITY LINES.

MAINTENANCE OF TRAFFIC

GENERAL NOTES

MAINTENANCE OF TRAFFIC PLAN DESCRIBED IS A SUGGESTED GUIDE FOR DIVERSION OF TRAFFIC DURING THE EXECUTION OF THIS CONTRACT. ANY REQUESTED CHANGES TO THE PLAN SHALL BE SUBMITTED TO THE ENGINEER 48 HOURS IN ADVANCE OF ANY IMPLEMENTATION.

THE CONTRACTOR SHALL MAINTAIN ACCESS TO ALL PROPERTIES AND SIDE ROADS DURING CONSTRUCTION OPERATIONS. AT THE END OF EACH WORK DAY TRAFFIC CONTROL SHALL BE REMOVED AND TRAFFIC RETURNED TO EXISTING OPERATIONS.

THE CONTRACTOR SHALL COORDINATE WORK FOR REPLACEMENT OF LUMINAIRES THAT ARE ATTACHED TO AN IDOT COMBINATION TRAFFIC SIGNAL MAST ARMS SUCH THAT EACH EXISTING TRAFFIC SIGNAL SHALL ONLY BE IMPACTED ONCE.

THE CONTRACTOR SHALL COORDINATE TO ENSURE AT NO TIME SHALL THE ROADWAY BE LEFT UNLIT DURING NIGHT-TIME HOURS.

STAGE 1:

REPLACE EXISTING HPS LUMINAIRES ON EXISTING LIGHT POLES WITH A PROPOSED LED LUMINIAIRE AS NOTED ON THE DRAWINGS ALONG THE EAST SIDE OF IL 50 (CICERO AVENUE). CLOSE LANES USING STANDARDS 701101-05, 701427-05, 701602-10, 701701-10, AND 701801-06 SUCH THAT WORK TO REPLACE EXISTING LUMINAIRE DOES NOT OCCUR ABOVE ACTIVE LANES.

STAGE 2:

REPLACE EXISTING HPS LUMINAIRES ON EXISTING LIGHT POLES WITH A PROPOSED LED LUMINIAIRE AS NOTED ON THE DRAWINGS ALONG THE WEST SIDE OF IL 50 (CICERO AVENUE). CLOSE LANES USING STANDARDS 701101-05, 701427-05, 701602-10, 701701-10, AND 701801-06 SUCH THAT WORK TO REPLACE EXISTING LUMINAIRE DOES NOT OCCUR ABOVE ACTIVE LANES.


PHASE I COMMITMENTS

NONE.

MODEL Default  
FILE Name: 301041800-489918011002DrawingsCAD\CAD\_sheets\801-004\_dht\_Cicero-Ave-General Notes\_Index\_Standards\_MOT.dgn

<div><div><div><div><div><div><span></span></div></div></div><div><div><div><span></span></div></div><div><div><span></span></div></div></div><div><div><div><span></span></div></div><div><div><span></span></div></div></div><div><div><div><span></span></div></div><div><div><span></span></div></div></div></div></div><div>1170 SOUTH HOUBOLT ROAD JOLIET, ILLINOIS 60431 (815) 744-4200</div></div>	USER NAME = JackD	DESIGNED - JED	REVISED -	STATE OF ILLINOIS DEPARTMENT OF TRANSPORTATION	CICERO AVE. 87TH ST. TO 111TH ST. GENERAL NOTES, INDEX OF SHEETS, AND MOT NOTES	F.A.P RTE.	SECTION	COUNTY	TOTAL SHEETS	SHEET NO.
		DRAWN - JMR	REVISED -			350	24-00199-00-LT	COOK	18	2
	PLOT SCALE = 100.0000 ' / in.	CHECKED - RRS	REVISED -						CONTRACT NO. 61M20	
	PLOT DATE = 12/11/2025	DATE - 11/17/2025	REVISED -			SCALE:	SHEET 1 OF 1 SHEETS	STA. TO STA.	ILLINOIS	

MODEL: Default  
FILE NAME: S:\014600-4899\48911002\Drawings\CAD\CAD sheets\4601-004 str Cicero-Ave-500.dgn



1170 SOUTH HOBOLT ROAD  
JOLIET, ILLINOIS 60431  
(815) 744-4200

USER NAME	= JackD	DESIGNED	- JED	REVISED	-
		DRAWN	- JMR	REVISED	-
PLOT SCALE	= 100.0000 ' / in.	CHECKED	- RRS	REVISED	-
PLOT DATE	= 12/11/2025	DATE	- 11/17/2025	REVISED	-

STATE OF ILLINOIS  
DEPARTMENT OF TRANSPORTATION


CICERO AVE. 87TH ST. TO 111TH ST. SUMMARY OF QUANTITIES				
SCALE:	SHEET 1	OF 1	SHEETS	STA. TO STA.

F.A.P RTE.	SECTION	COUNTY	TOTAL SHEETS	SHEET NO.
350	24-00199-00-LT	COOK	18	3
CONTRACT NO. 61M20				
ILLINOIS				

CONSTRUCTION CODE
STREET LIGHTING 0021
80% FED. 20% STATE


CODE NO.	ITEM	UNIT	TOTAL QUANTITY	URBAN
67100100	MOBILIZATION	L SUM	1	1
70102632	TRAFFIC CONTROL AND PROTECTION, STANDARD 701602	L SUM	1	1
70102635	TRAFFIC CONTROL AND PROTECTION, STANDARD 701701	L SUM	1	1
70102640	TRAFFIC CONTROL AND PROTECTION, STANDARD 701801	L SUM	1	1
82110008	LUMINAIRE, LED, ROADWAY, OUTPUT DESIGNATION H	EACH	7	7
85000200	MAINTENANCE OF EXISTING TRAFFIC SIGNAL INSTALLATION	EACH	2	2
X1400238	LUMINAIRE, LED, SPECIAL	EACH	279	279
X1400267	REMOVAL OF LIGHTING LUMINAIRE, NO SALVAGE	EACH	7	7
X8000003	MAINTENANCE OF LIGHTING SYSTEM	CAL MO	3	3
X8420104	REMOVAL OF LUMINAIRE, SALVAGE, ROADWAY	EACH	279	279
Z0033020	LUMINAIRE SAFETY CABLE ASSEMBLY	EACH	286	286

\* DENOTES SPECIALTY ITEM

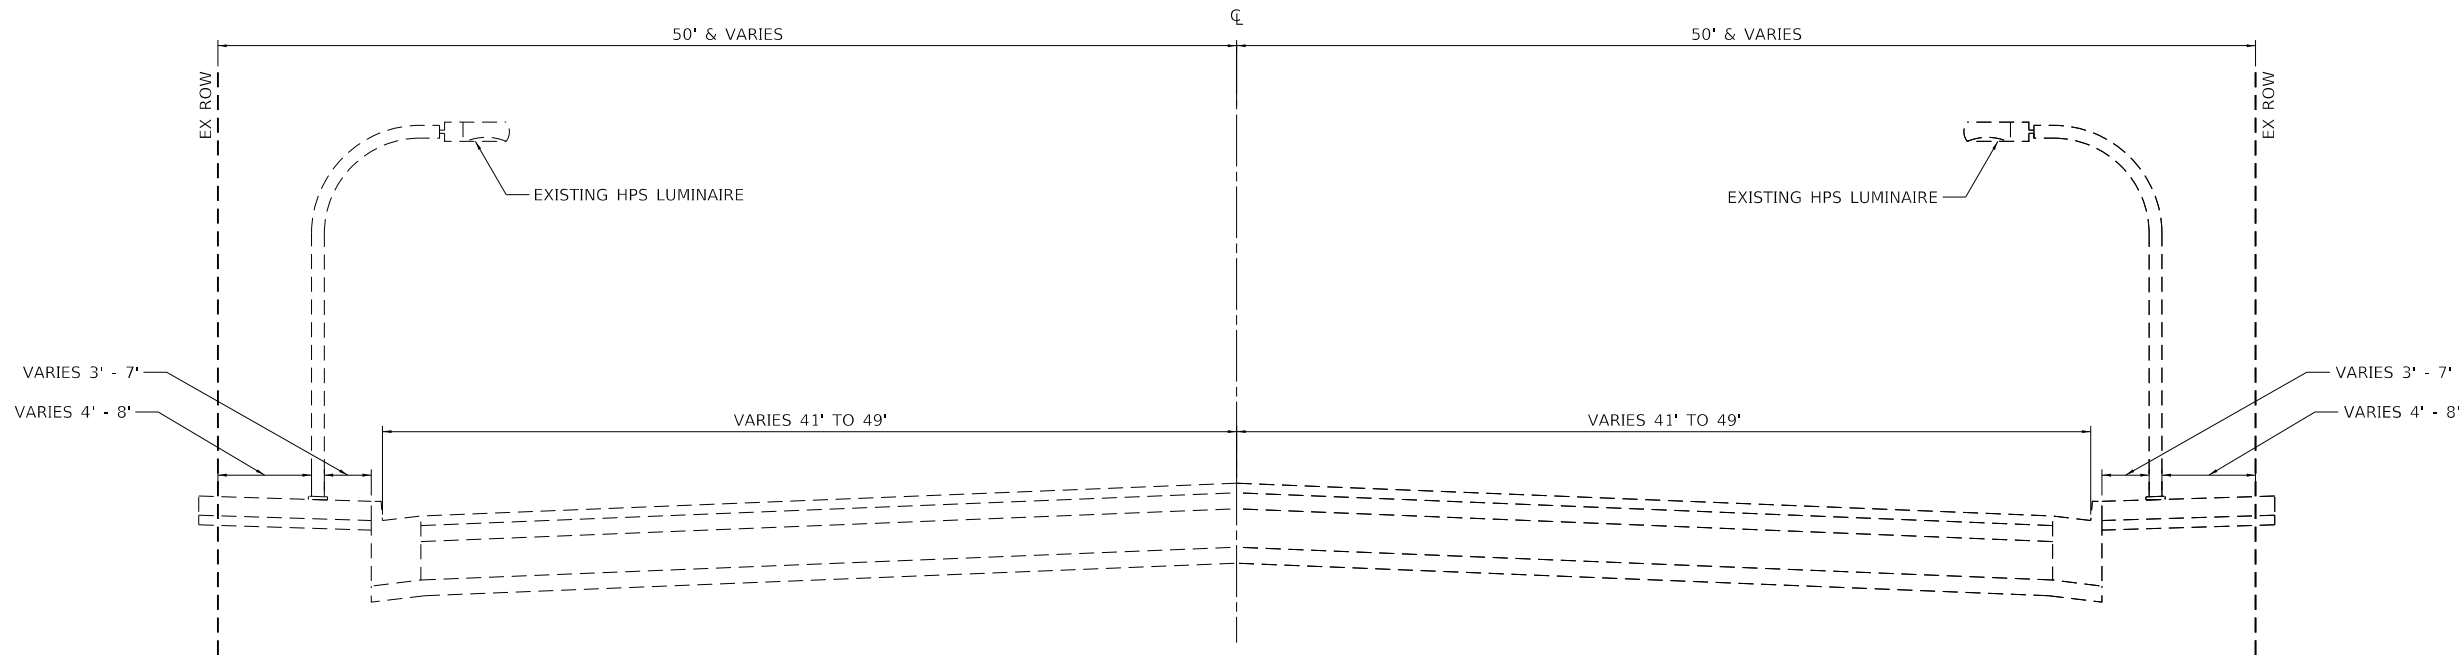

**EXISTING TYPICAL SECTION**

IL ROUTE 50 (CICERO AVENUE)  
FROM 87TH STREET TO 111TH STREET

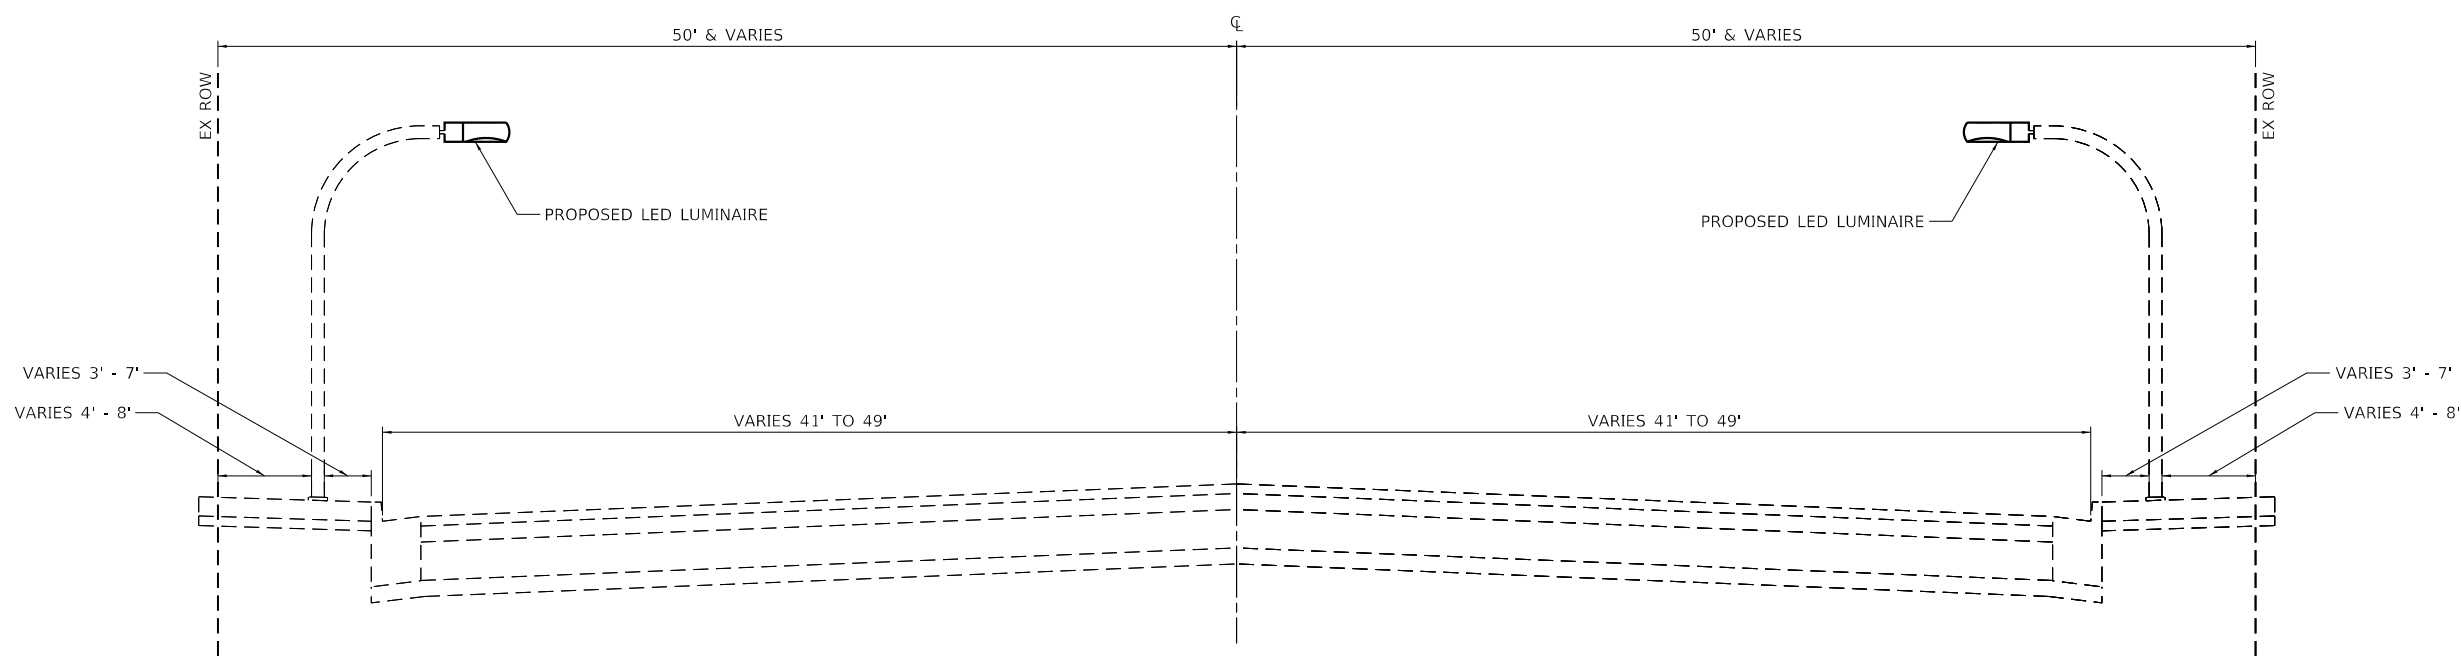

**PROPOSED TYPICAL SECTION**

IL ROUTE 50 (CICERO AVENUE)  
FROM 87TH STREET TO 111TH STREET

MODEL Default  
FILE Name: 3:\04\1800-4899\801002\Drawings\CAD\CAD\_sheets\801-002\_gh\_Cicero Avenue Typical Section.dgn



1170 SOUTH HOUBOLT ROAD  
JOLIET, ILLINOIS 60431  
(815) 744-4200

USER NAME = JackD	DESIGNED - JED	REVISED -
	DRAWN - JMR	REVISED -
PLOT SCALE = 10.0000 ' / in.	CHECKED - RRS	REVISED -
PLOT DATE = 12/11/2025	DATE - 11/17/2025	REVISED -


STATE OF ILLINOIS  
DEPARTMENT OF TRANSPORTATION

CICERO AVE. 87TH ST. TO 111TH ST.  
TYPICAL SECTIONS

SCALE: SHEET 1 OF 1 SHEETS STA. TO STA.

F.A.P RTE.	SECTION	COUNTY	TOTAL SHEETS	SHEET NO.
350	24-00199-00-LT	COOK	18	4
CONTRACT NO. 61M20				
ILLINOIS				



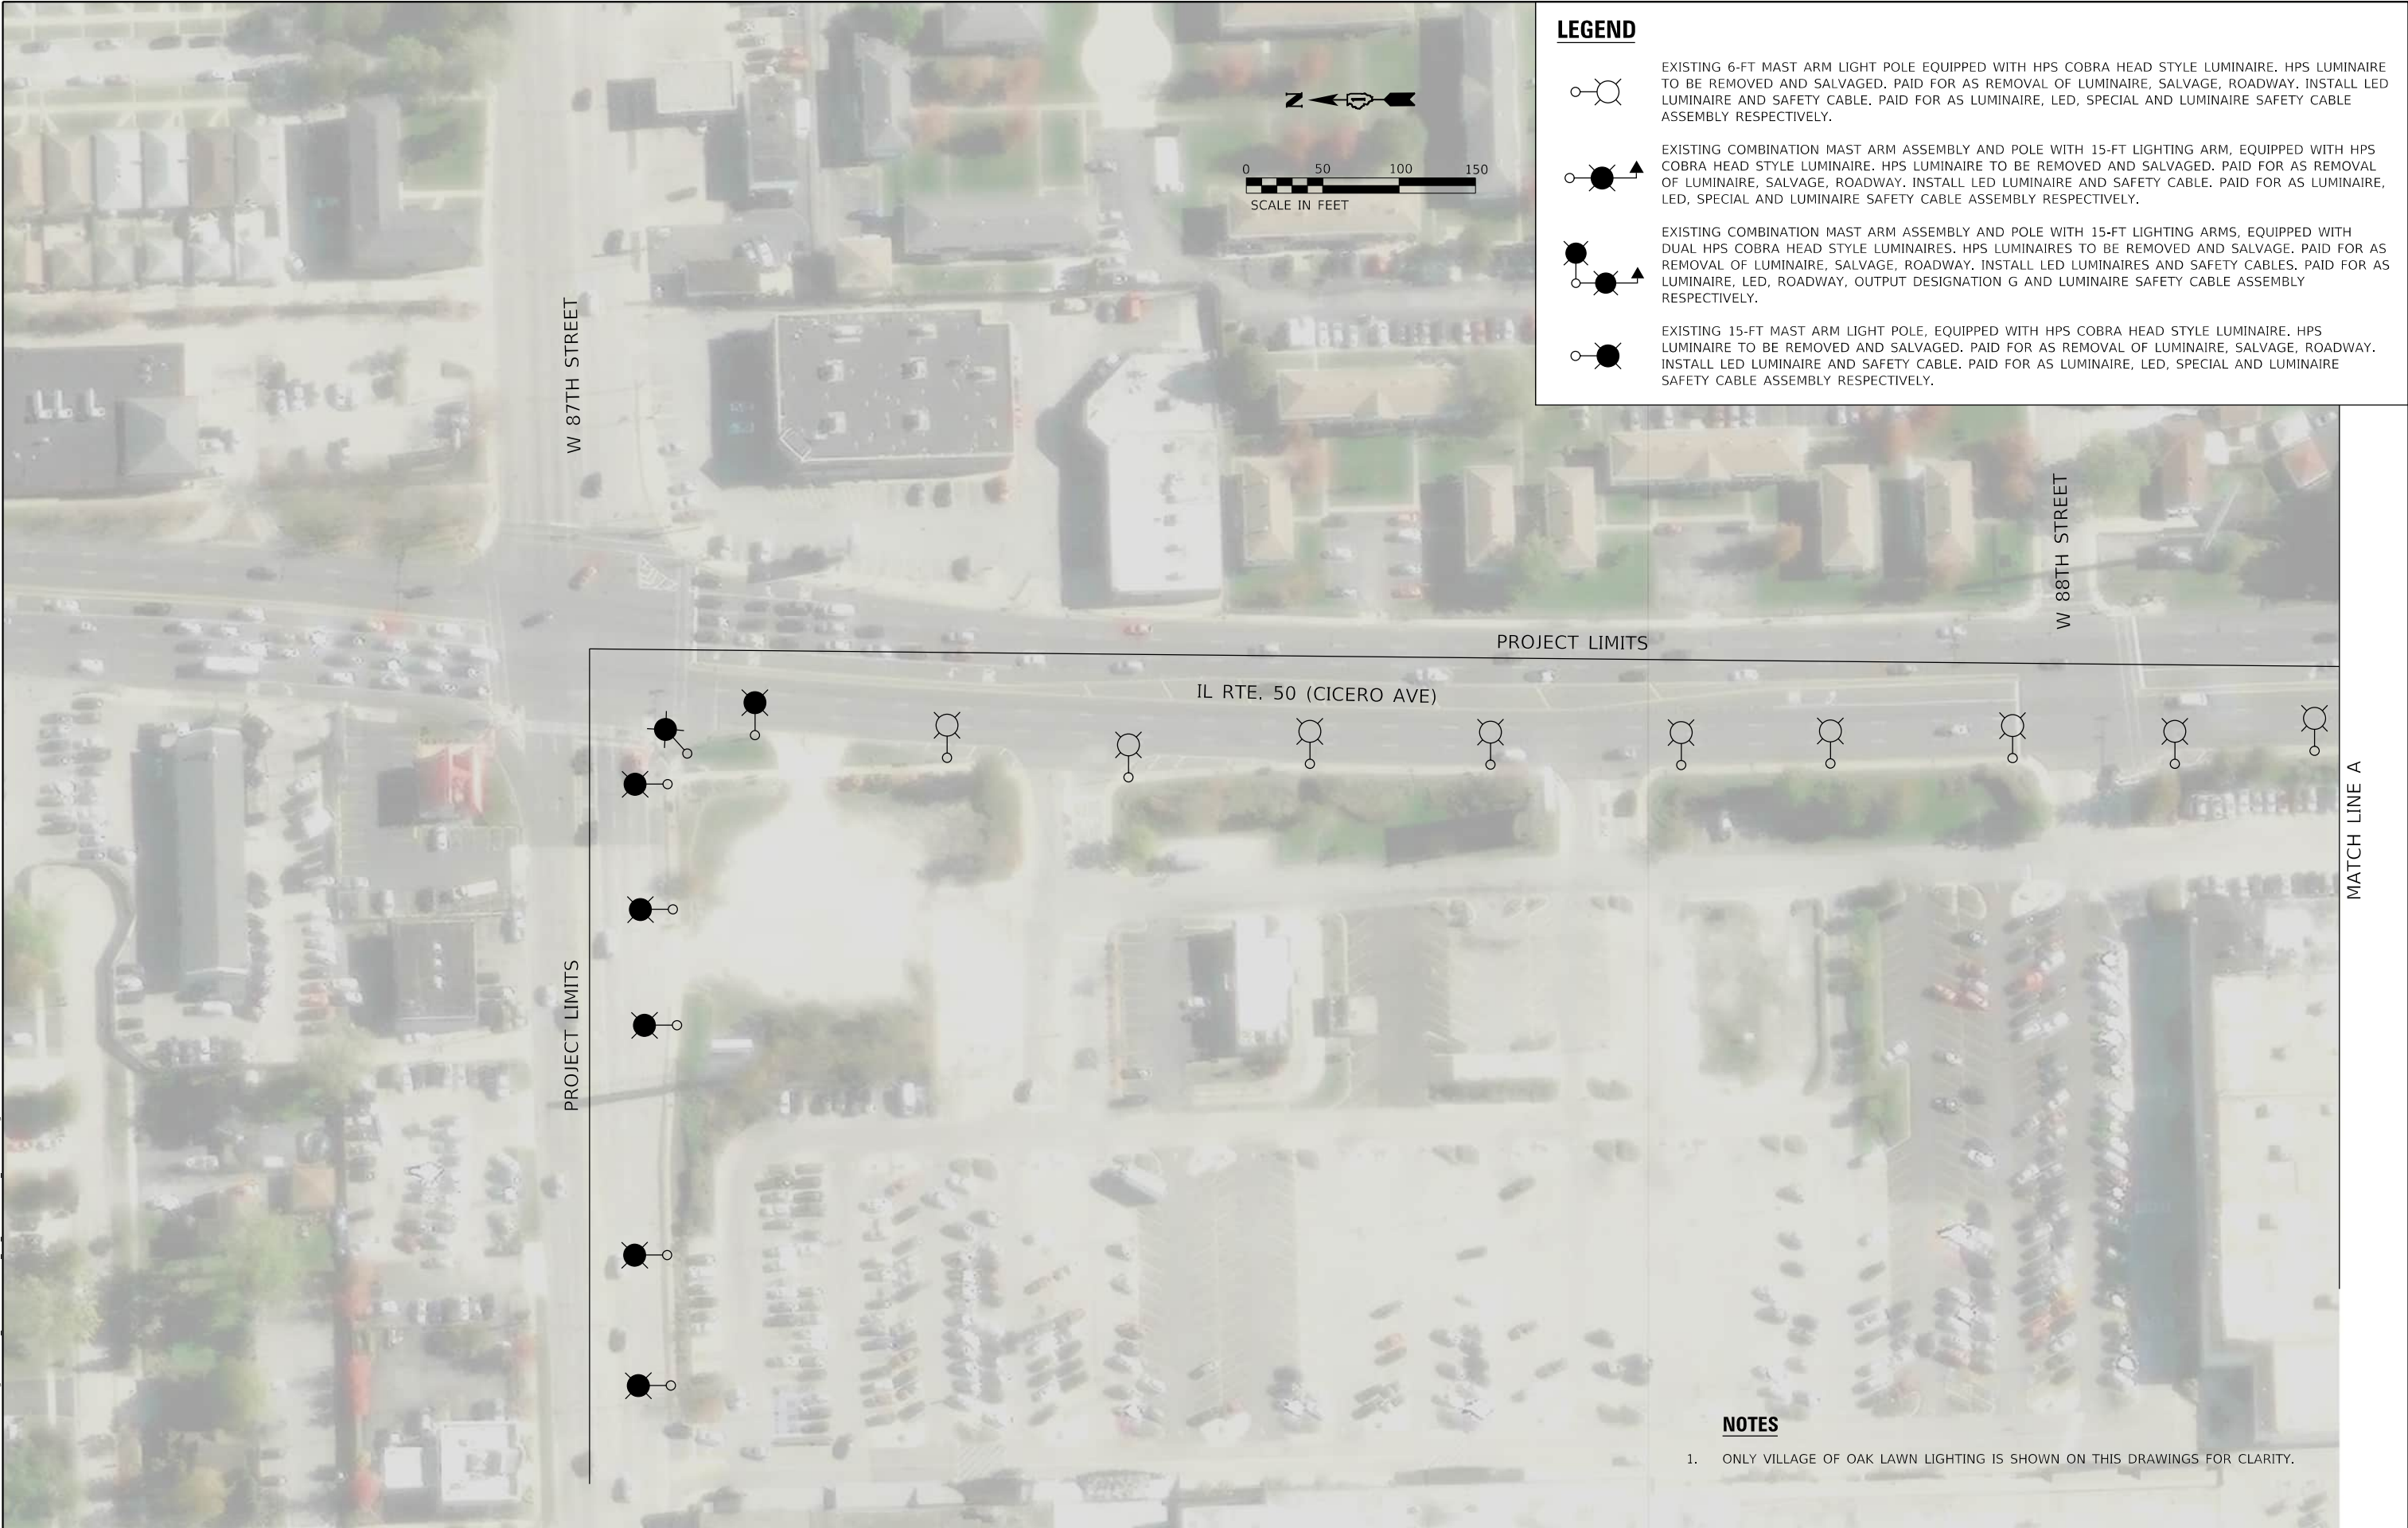

MODEL: Default  
FILE NAME: S:\JULI800-4899\8001002\Drawings\CAD\CAD\_sheets\JULI801-L002\_dht\_Cicero-Ave-01\_03042025.dgn

<div><div><div><div><div><div><span></span></div><div>SA</div></div></div><div><div><div><span></span></div><div>STRAND</div></div><div><div>ASSOCIATES®</div></div></div></div><div><div>1170 SOUTH HOUBOLT ROAD</div><div>JOLIET, ILLINOIS 60431</div><div>(815) 744-4200</div></div></div></div>	USER NAME = JackD	DESIGNED - JED	REVISED -	STATE OF ILLINOIS DEPARTMENT OF TRANSPORTATION	CICERO AVE. 87TH ST. TO 111TH ST. REMOVAL AND PROPOSED LIGHTING DRAWINGS	F.A.P RTE.	SECTION	COUNTY	TOTAL SHEETS	SHEET NO.
		DRAWN - JMR	REVISED -			350	24-00199-00-LT	COOK	18	5
	PLOT SCALE = 100.0000 ' / in.	CHECKED - AJR	REVISED -						CONTRACT NO. 61M20	
	PLOT DATE = 12/11/2025	DATE - 11/17/2025	REVISED -						ILLINOIS	
						SCALE: 1" = 50'	SHEET 1 OF 12 SHEETS	STA.	TO STA.	




### LEGEND



EXISTING 6-FT MAST ARM LIGHT POLE EQUIPPED WITH HPS COBRA HEAD STYLE LUMINAIRE. HPS LUMINAIRE TO BE REMOVED AND SALVAGED. PAID FOR AS REMOVAL OF LUMINAIRE, SALVAGE, ROADWAY. INSTALL LED LUMINAIRE AND SAFETY CABLE. PAID FOR AS LUMINAIRE, LED, SPECIAL AND LUMINAIRE SAFETY CABLE ASSEMBLY RESPECTIVELY.



 
EXISTING COMBINATION MAST ARM ASSEMBLY AND POLE WITH 15-FT LIGHTING ARM, EQUIPPED WITH HPS COBRA HEAD STYLE LUMINAIRE. HPS LUMINAIRE TO BE REMOVED AND SALVAGED. PAID FOR AS REMOVAL OF LUMINAIRE, SALVAGE, ROADWAY. INSTALL LED LUMINAIRE AND SAFETY CABLE. PAID FOR AS LUMINAIRE, LED, SPECIAL AND LUMINAIRE SAFETY CABLE ASSEMBLY RESPECTIVELY.



EXISTING COMBINATION MAST ARM ASSEMBLY AND POLE WITH 15-FT LIGHTING ARMS, EQUIPPED WITH DUAL HPS COBRA HEAD STYLE LUMINAIRES. HPS LUMINAIRES TO BE REMOVED AND SALVAGE. PAID FOR AS REMOVAL OF LUMINAIRE, SALVAGE, ROADWAY. INSTALL LED LUMINAIRES AND SAFETY CABLES. PAID FOR AS LUMINAIRE, LED, ROADWAY, OUTPUT DESIGNATION G AND LUMINAIRE SAFETY CABLE ASSEMBLY RESPECTIVELY.



 EXISTING 15-FT MAST ARM LIGHT POLE, EQUIPPED WITH HPS COBRA HEAD STYLE LUMINAIRE. HPS LUMINAIRE TO BE REMOVED AND SALVAGED. PAID FOR AS REMOVAL OF LUMINAIRE, SALVAGE, ROADWAY. INSTALL LED LUMINAIRE AND SAFETY CABLE. PAID FOR AS LUMINAIRE, LED, SPECIAL AND LUMINAIRE SAFETY CABLE ASSEMBLY RESPECTIVELY.



MATCH LINE A

### PROJECT LIMITS

W 89TH PLACE

90TH STREET

IL RTE. 50 (CICERO AVE)

91ST STREET

MATCH LINE B

## NOTES

1. ONLY VILLAGE OF OAK LAWN LIGHTING IS SHOWN ON THIS DRAWINGS FOR CLARITY.



1170 SOUTH HOUBOLT ROAD  
JOLIET, ILLINOIS 60431  
(815) 744-4200

USER NAME	= Jack
-----------	--------

PLOT SCALE = 100.0000 ' / in.

PLOT DATE	= 12/11/2025
-----------	--------------

DESIGNED - IED

DRAWN	-	JMR
-------	---	-----

CHECKED - AJR

DATE	-	11/17/2025
------	---	------------

REVISÉ -

REVISED	-
---------	---

REVISÉ -

REVISÉ

STATE OF ILLINOIS  
DEPARTMENT OF TRANSPORTATION

**CICERO AVE. 87TH ST. TO 111TH ST.  
REMOVAL AND PROPOSED LIGHTING DRAWINGS**

SCALE: 1" = 50'	SHEET 2 OF 12 SHEETS	STA. _____ TO STA. _____
-----------------	----------------------	--------------------------

F.A.P. RTE.	350
----------------	-----

SECTION

24-00199-00-L

COUNTY

 
TOTAL	
-------	--


SHEETS	
18	


CONTRACT NO. 61M20


ILLINOIS

LEGEND


- 

 EXISTING 6-FT MAST ARM LIGHT POLE EQUIPPED WITH HPS COBRA HEAD STYLE LUMINAIRE. HPS LUMINAIRE TO BE REMOVED AND SALVAGED. PAID FOR AS REMOVAL OF LUMINAIRE, SALVAGE, ROADWAY. INSTALL LED LUMINAIRE AND SAFETY CABLE. PAID FOR AS LUMINAIRE, LED, SPECIAL AND LUMINAIRE SAFETY CABLE ASSEMBLY RESPECTIVELY.
- 

 EXISTING COMBINATION MAST ARM ASSEMBLY AND POLE WITH 15-FT LIGHTING ARM, EQUIPPED WITH HPS COBRA HEAD STYLE LUMINAIRE. HPS LUMINAIRE TO BE REMOVED AND SALVAGED. PAID FOR AS REMOVAL OF LUMINAIRE, SALVAGE, ROADWAY. INSTALL LED LUMINAIRE AND SAFETY CABLE. PAID FOR AS LUMINAIRE, LED, SPECIAL AND LUMINAIRE SAFETY CABLE ASSEMBLY RESPECTIVELY.
- 

EXISTING COMBINATION MAST ARM ASSEMBLY AND POLE WITH 15-FT LIGHTING ARMS, EQUIPPED WITH DUAL HPS COBRA HEAD STYLE LUMINAIRES. HPS LUMINAIRES TO BE REMOVED AND SALVAGE. PAID FOR AS REMOVAL OF LUMINAIRE, SALVAGE, ROADWAY. INSTALL LED LUMINAIRES AND SAFETY CABLES. PAID FOR AS LUMINAIRE, LED, ROADWAY, OUTPUT DESIGNATION G AND LUMINAIRE SAFETY CABLE ASSEMBLY RESPECTIVELY.
- 

EXISTING 15-FT MAST ARM LIGHT POLE, EQUIPPED WITH HPS COBRA HEAD STYLE LUMINAIRE. HPS LUMINAIRE TO BE REMOVED AND SALVAGED. PAID FOR AS REMOVAL OF LUMINAIRE, SALVAGE, ROADWAY. INSTALL LED LUMINAIRE AND SAFETY CABLE. PAID FOR AS LUMINAIRE, LED, SPECIAL AND LUMINAIRE SAFETY CABLE ASSEMBLY RESPECTIVELY.

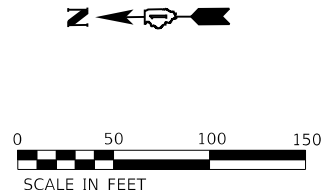

MODEL Default  
FILE NAME: S:\041800-4899\801002\Drawings\CAD\CAD\_sheets\801-002\_dht\_Cicero-Ave.dgn 03/04/2025.dgn

<div><div>1170 SOUTH HOUBOLT ROAD JOLIET, ILLINOIS 60431 (815) 744-4200</div></div>	USER NAME = JackD		DESIGNED - JED	REVISED -	STATE OF ILLINOIS DEPARTMENT OF TRANSPORTATION	CICERO AVE, 87TH ST. TO 111TH ST. REMOVAL AND PROPOSED LIGHTING DRAWINGS		F.A.P RTE.	SECTION	COUNTY	TOTAL SHEETS	SHEET NO.
	DRAWN - JMR		REVIS	REVISED -				350	24-00199-00-LT	COOK	18	7
	PLOT SCALE = 100,0000 ' / in.		CHECKED - AJR	REVISED -		SCALE: 1" = 50'		CONTRACT NO. 61M20				
	PLOT DATE = 12/11/2025		DATE - 11/17/2025	REVISED -		SHEET 3 OF 12 SHEETS		ILLINOIS				



MODEL: Default  
FILE: \\nwrp-30\c\14800-4899\4801002\Drawings\CAD\CAD\_sheets\4801-002\_gh\_CiceroAve-04\_03042025.dgn



1170 SOUTH HOUBOLT ROAD  
JOLIET, ILLINOIS 60431

(815) 744-4200

#### NOTES

- A QUANTITY OF 1 EACH FOR MAINTENANCE OF EXISTING TRAFFIC SIGNAL HAS BEEN INCLUDED FOR THE INTERSECTION OF SOUTHWEST HIGHWAY AND IL 50 (CICERO AVENUE) (TS 2620).
- A QUANTITY OF 1 EACH FOR MAINTENANCE OF EXISTING TRAFFIC SIGNAL HAS BEEN INCLUDED FOR THE INTERSECTION OF 94TH STREET AND IL 50 (CICERO AVENUE) (TS 2485).

MATCH LINE C


SOUTHWEST HWY

COLUMBUS DRIVE

NORTHEAST ILLINOIS REGIONAL COMMUTER RAILROAD

94TH STREET

IL RTE. 50 (CICERO AVE)

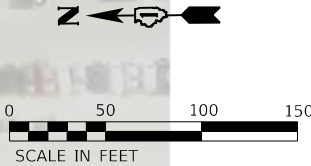

LED STREET LIGHTING REPLACEMENT BY OTHERS

#### LEGEND

- EXISTING 6-FT MAST ARM LIGHT POLE EQUIPPED WITH HPS COBRA HEAD STYLE LUMINAIRE. HPS LUMINAIRE TO BE REMOVED AND SALVAGED. PAID FOR AS REMOVAL OF LUMINAIRE, SALVAGE, ROADWAY. INSTALL LED LUMINAIRE AND SAFETY CABLE. PAID FOR AS LUMINAIRE, LED, SPECIAL AND LUMINAIRE SAFETY CABLE ASSEMBLY RESPECTIVELY.
- EXISTING COMBINATION MAST ARM ASSEMBLY AND POLE WITH 15-FT LIGHTING ARM, EQUIPPED WITH HPS COBRA HEAD STYLE LUMINAIRE. HPS LUMINAIRE TO BE REMOVED AND SALVAGED. PAID FOR AS REMOVAL OF LUMINAIRE, SALVAGE, ROADWAY. INSTALL LED LUMINAIRE AND SAFETY CABLE. PAID FOR AS LUMINAIRE, LED, SPECIAL AND LUMINAIRE SAFETY CABLE ASSEMBLY RESPECTIVELY.
- EXISTING COMBINATION MAST ARM ASSEMBLY AND POLE WITH 15-FT LIGHTING ARMS, EQUIPPED WITH DUAL HPS COBRA HEAD STYLE LUMINAIRES. HPS LUMINAIRES TO BE REMOVED AND SALVAGED. PAID FOR AS REMOVAL OF LUMINAIRE, SALVAGE, ROADWAY. INSTALL LED LUMINAIRES AND SAFETY CABLES. PAID FOR AS LUMINAIRE, LED, ROADWAY, OUTPUT DESIGNATION G AND LUMINAIRE SAFETY CABLE ASSEMBLY RESPECTIVELY.
- EXISTING 15-FT MAST ARM LIGHT POLE, EQUIPPED WITH HPS COBRA HEAD STYLE LUMINAIRE. HPS LUMINAIRE TO BE REMOVED AND SALVAGED. PAID FOR AS REMOVAL OF LUMINAIRE, SALVAGE, ROADWAY. INSTALL LED LUMINAIRE AND SAFETY CABLE. PAID FOR AS LUMINAIRE, LED, SPECIAL AND LUMINAIRE SAFETY CABLE ASSEMBLY RESPECTIVELY.

STATE OF ILLINOIS  
DEPARTMENT OF TRANSPORTATION

 
CICERO AVE. 87TH ST. TO 111TH ST.  
REMOVAL AND PROPOSED LIGHTING DRAWINGS


SCALE: 1" = 50' SHEET 4 OF 12 SHEETS STA. TO STA.


F.A.P RTE.	SECTION	COUNTY	TOTAL SHEETS	SHEET NO.
350	24-00199-00-LT	COOK	18	8
CONTRACT NO. 61M20				
ILLINOIS				




LEGEND

- 

EXISTING 6-FT MAST ARM LIGHT POLE EQUIPPED WITH HPS COBRA HEAD STYLE LUMINAIRE. HPS LUMINAIRE TO BE REMOVED AND SALVAGED. PAID FOR AS REMOVAL OF LUMINAIRE, SALVAGE, ROADWAY. INSTALL LED LUMINAIRE AND SAFETY CABLE. PAID FOR AS LUMINAIRE, LED, SPECIAL AND LUMINAIRE SAFETY CABLE ASSEMBLY RESPECTIVELY.
- 

EXISTING COMBINATION MAST ARM ASSEMBLY AND POLE WITH 15-FT LIGHTING ARM, EQUIPPED WITH HPS COBRA HEAD STYLE LUMINAIRE. HPS LUMINAIRE TO BE REMOVED AND SALVAGED. PAID FOR AS REMOVAL OF LUMINAIRE, SALVAGE, ROADWAY. INSTALL LED LUMINAIRE AND SAFETY CABLE. PAID FOR AS LUMINAIRE, LED, SPECIAL AND LUMINAIRE SAFETY CABLE ASSEMBLY RESPECTIVELY.
- 

EXISTING COMBINATION MAST ARM ASSEMBLY AND POLE WITH 15-FT LIGHTING ARMS, EQUIPPED WITH DUAL HPS COBRA HEAD STYLE LUMINAIRES. HPS LUMINAIRES TO BE REMOVED AND SALVAGE. PAID FOR AS REMOVAL OF LUMINAIRE, SALVAGE, ROADWAY. INSTALL LED LUMINAIRES AND SAFETY CABLES. PAID FOR AS LUMINAIRE, LED, ROADWAY, OUTPUT DESIGNATION G AND LUMINAIRE SAFETY CABLE ASSEMBLY RESPECTIVELY.
- 

EXISTING 15-FT MAST ARM LIGHT POLE, EQUIPPED WITH HPS COBRA HEAD STYLE LUMINAIRE. HPS LUMINAIRE TO BE REMOVED AND SALVAGED. PAID FOR AS REMOVAL OF LUMINAIRE, SALVAGE, ROADWAY. INSTALL LED LUMINAIRE AND SAFETY CABLE. PAID FOR AS LUMINAIRE, LED, SPECIAL AND LUMINAIRE SAFETY CABLE ASSEMBLY RESPECTIVELY.



LED STREET LIGHTING REPLACEMENT BY OTHERS



MATCH LINE D

MODEL: Default  
FILE NAME: S:\JULI800-4899\8001002\Drawings\CAD\CAD\_sheets\JULI801-L002\_dht\_Cicero-Ave-05\_03042025.dgn



1170 SOUTH HOUBOLT ROAD  
JOLIET, ILLINOIS 60431  
(815) 744-4200

USER NAME = JackD	DESIGNED - JED	REVISED -
	DRAWN - JMR	REVISED -
PLOT SCALE = 100,0000 ' / in.	CHECKED - AJR	REVISED -
PLOT DATE = 12/11/2025	DATE - 11/17/2025	REVISED -

STATE OF ILLINOIS  
DEPARTMENT OF TRANSPORTATION

CICERO AVE. 87TH ST. TO 111TH ST.  
REMOVAL AND PROPOSED LIGHTING DRAWINGS

SCALE: 1" = 50' SHEET 5 OF 12 SHEETS STA. TO STA.

F.A.P RTE.	SECTION	COUNTY	TOTAL SHEETS	SHEET NO.
350	24-00199-00-LT	COOK	18	9
		CONTRACT NO. 61M20		
		ILLINOIS		





LEGEND

EXISTING 6-FT MAST ARM LIGHT POLE EQUIPPED WITH HPS COBRA HEAD STYLE LUMINAIRE. HPS LUMINAIRE TO BE REMOVED AND SALVAGED. PAID FOR AS REMOVAL OF LUMINAIRE, SALVAGE, ROADWAY. INSTALL LED LUMINAIRE AND SAFETY CABLE. PAID FOR AS LUMINAIRE, LED, SPECIAL AND LUMINAIRE SAFETY CABLE ASSEMBLY RESPECTIVELY.

EXISTING 6-FT MAST ARM LIGHT POLE EQUIPPED WITH A COBRA HEAD STYLE AND DUAL GLOBE STYLE HPS LUMINAIRES. COBRA HEAD STYLE AND GLOBE STYLE HPS LUMINAIRE TO BE REMOVED AND SALVAGED. PAID FOR AS REMOVAL OF LUMINAIRE, SALVAGE, ROADWAY AND REMOVAL OF LUMINAIRE, SALVAGE RESPECTIVELY. INSTALL LED LUMINAIRE AND SAFETY CABLE. PAID FOR AS LUMINAIRE, LED, SPECIAL AND LUMINAIRE SAFETY CABLE ASSEMBLY RESPECTIVELY.

EXISTING COMBINATION MAST ARM ASSEMBLY AND POLE WITH 15-FT LIGHTING ARM, EQUIPPED WITH HPS COBRA HEAD STYLE LUMINAIRE. HPS LUMINAIRE TO BE REMOVED AND SALVAGED. PAID FOR AS REMOVAL OF LUMINAIRE, SALVAGE, ROADWAY. INSTALL LED LUMINAIRE AND SAFETY CABLE. PAID FOR AS LUMINAIRE, LED, SPECIAL AND LUMINAIRE SAFETY CABLE ASSEMBLY RESPECTIVELY.

EXISTING 15-FT MAST ARM LIGHT POLE, EQUIPPED WITH HPS COBRA HEAD STYLE LUMINAIRE. HPS LUMINAIRE TO BE REMOVED AND SALVAGED. PAID FOR AS REMOVAL OF LUMINAIRE, SALVAGE, ROADWAY. INSTALL LED LUMINAIRE AND SAFETY CABLE. PAID FOR AS LUMINAIRE, LED, SPECIAL AND LUMINAIRE SAFETY CABLE ASSEMBLY RESPECTIVELY.

MODEL Default  
FILE Name: S:\JULI800-4899\8001002\Drawings\CAD\CAD\_sheets\JULI801-002\_gh\_Cicero-Ave-06\_03042025.dgn




### LEGEND



EXISTING 6-FT MAST ARM LIGHT POLE EQUIPPED WITH HPS COBRA HEAD STYLE LUMINAIRE. HPS LUMINAIRE TO BE REMOVED AND SALVAGED. PAID FOR AS REMOVAL OF LUMINAIRE, SALVAGE, ROADWAY. INSTALL LED LUMINAIRE AND SAFETY CABLE. PAID FOR AS LUMINAIRE, LED, SPECIAL AND LUMINAIRE SAFETY CABLE ASSEMBLY RESPECTIVELY.



 EXISTING COMBINATION MAST ARM ASSEMBLY AND POLE WITH 15-FT LIGHTING ARM, EQUIPPED WITH HPS COBRA HEAD STYLE LUMINAIRE. HPS LUMINAIRE TO BE REMOVED AND SALVAGED. PAID FOR AS REMOVAL OF LUMINAIRE, SALVAGE, ROADWAY. INSTALL LED LUMINAIRE AND SAFETY CABLE. PAID FOR AS LUMINAIRE, LED, SPECIAL AND LUMINAIRE SAFETY CABLE ASSEMBLY RESPECTIVELY.



EXISTING COMBINATION MAST ARM ASSEMBLY AND POLE WITH 15-FT LIGHTING ARMS, EQUIPPED WITH DUAL HPS COBRA HEAD STYLE LUMINAIRES. HPS LUMINAIRES TO BE REMOVED AND SALVAGE. PAID FOR AS REMOVAL OF LUMINAIRE, SALVAGE, ROADWAY. INSTALL LED LUMINAIRES AND SAFETY CABLES. PAID FOR AS LUMINAIRE, LED, ROADWAY, OUTPUT DESIGNATION G AND LUMINAIRE SAFETY CABLE ASSEMBLY RESPECTIVELY.



EXISTING 15-FT MAST ARM LIGHT POLE, EQUIPPED WITH HPS COBRA HEAD STYLE LUMINAIRE. HPS LUMINAIRE TO BE REMOVED AND SALVAGED. PAID FOR AS REMOVAL OF LUMINAIRE, SALVAGE, ROADWAY. INSTALL LED LUMINAIRE AND SAFETY CABLE. PAID FOR AS LUMINAIRE, LED, SPECIAL AND LUMINAIRE SAFETY CABLE ASSEMBLY RESPECTIVELY.



MODEL: Default  
FILE NAME: S:\JUL14800-4899\4801\002\Drawings\CAD\ sheets\4801-002 sht Cicer-Ave-07 02042025.dgn



1170 SOUTH HOUBOLT ROAD  
JOLIET, ILLINOIS 60431  
(815) 744-4200

USER NAME = JackD	DESIGNED - JED	REVISED -
	DRAWN - JMR	REVISED -
PLOT SCALE = 100,0000 ' / in.	CHECKED - AJR	REVISED -
PLOT DATE = 12/11/2025	DATE - 11/17/2025	REVISED -

STATE OF ILLINOIS  
DEPARTMENT OF TRANSPORTATION

**CICERO AVE. 87TH ST. TO 111TH ST.  
REMOVAL AND PROPOSED LIGHTING DRAWINGS**

SCALE: 1" = 50'	SHEET 7 OF 12 SHEETS	STA. _____ TO STA. _____
-----------------	----------------------	--------------------------

F.A.P RTE.	SECTION	COUNTY	TOTAL SHEETS	SHEET NO.
350	24-00199-00-LT	COOK	18	11
		CONTRACT NO. 61M20		
ILLINOIS				



MODEL: Default  
FILE: \\wms01\30\JUL1800-4899\8001002\Drawings\CADD\CD sheets\801-L002\_dht\_CiceroAve-08\_03042025.dgn



1170 SOUTH HOUBOLT ROAD  
JOLIET, ILLINOIS 60431  
(815) 744-4200

USER NAME	= JackD
PLOT SCALE	= 100.0000 ' / in.
PLOT DATE	= 12/11/2025

DESIGNED -	JED
DRAWN -	JMR
CHECKED -	AJR
DATE -	11/17/2025

REVISED -	
REVISED -	
REVISED -	
REVISED -	

STATE OF ILLINOIS  
DEPARTMENT OF TRANSPORTATION

CICERO AVE, 87TH ST. TO 111TH ST.  
REMOVAL AND PROPOSED LIGHTING DRAWINGS

SCALE: 1" = 50'    SHEET 8 OF 12 SHEETS    STA.    TO STA.

F.A.P RTE.	SECTION	COUNTY	TOTAL SHEETS	SHEET NO.
350	24-00199-00-LT	COOK	18	12
		CONTRACT NO. 61M20		
		ILLINOIS		

MATCH LINE F

OAK CENTER DRIVE

103RD STREET

IL RTE. 50 (CICERO AVE)

104TH STREET

MATCH LINE G

LEGEND



EXISTING 6-FT MAST ARM LIGHT POLE EQUIPPED WITH HPS COBRA HEAD STYLE LUMINAIRE. HPS LUMINAIRE TO BE REMOVED AND SALVAGED. PAID FOR AS REMOVAL OF LUMINAIRE, SALVAGE, ROADWAY. INSTALL LED LUMINAIRE AND SAFETY CABLE. PAID FOR AS LUMINAIRE, LED, SPECIAL AND LUMINAIRE SAFETY CABLE ASSEMBLY RESPECTIVELY.



EXISTING COMBINATION MAST ARM ASSEMBLY AND POLE WITH 15-FT LIGHTING ARM, EQUIPPED WITH HPS COBRA HEAD STYLE LUMINAIRE. HPS LUMINAIRE TO BE REMOVED AND SALVAGED. PAID FOR AS REMOVAL OF LUMINAIRE, SALVAGE, ROADWAY. INSTALL LED LUMINAIRE AND SAFETY CABLE. PAID FOR AS LUMINAIRE, LED, SPECIAL AND LUMINAIRE SAFETY CABLE ASSEMBLY RESPECTIVELY.



EXISTING COMBINATION MAST ARM ASSEMBLY AND POLE WITH 15-FT LIGHTING ARMS, EQUIPPED WITH DUAL HPS COBRA HEAD STYLE LUMINAIRES. HPS LUMINAIRES TO BE REMOVED AND SALVAGED. PAID FOR AS REMOVAL OF LUMINAIRE, SALVAGE, ROADWAY. INSTALL LED LUMINAIRES AND SAFETY CABLES. PAID FOR AS LUMINAIRE, LED, ROADWAY, OUTPUT DESIGNATION G AND LUMINAIRE SAFETY CABLE ASSEMBLY RESPECTIVELY.




 
EXISTING 15-FT MAST ARM LIGHT POLE, EQUIPPED WITH HPS COBRA HEAD STYLE LUMINAIRE. HPS LUMINAIRE TO BE REMOVED AND SALVAGED. PAID FOR AS REMOVAL OF LUMINAIRE, SALVAGE, ROADWAY. INSTALL LED LUMINAIRE AND SAFETY CABLE. PAID FOR AS LUMINAIRE, LED, SPECIAL AND LUMINAIRE SAFETY CABLE ASSEMBLY RESPECTIVELY.







LEGEND

- 

EXISTING 6-FT MAST ARM LIGHT POLE EQUIPPED WITH HPS COBRA HEAD STYLE LUMINAIRE. HPS LUMINAIRE TO BE REMOVED AND SALVAGED. PAID FOR AS REMOVAL OF LUMINAIRE, SALVAGE, ROADWAY. INSTALL LED LUMINAIRE AND SAFETY CABLE. PAID FOR AS LUMINAIRE, LED, SPECIAL AND LUMINAIRE SAFETY CABLE ASSEMBLY RESPECTIVELY.
- 

EXISTING COMBINATION MAST ARM ASSEMBLY AND POLE WITH 15-FT LIGHTING ARM, EQUIPPED WITH HPS COBRA HEAD STYLE LUMINAIRE. HPS LUMINAIRE TO BE REMOVED AND SALVAGED. PAID FOR AS REMOVAL OF LUMINAIRE, SALVAGE, ROADWAY. INSTALL LED LUMINAIRE AND SAFETY CABLE. PAID FOR AS LUMINAIRE, LED, SPECIAL AND LUMINAIRE SAFETY CABLE ASSEMBLY RESPECTIVELY.
- 

EXISTING COMBINATION MAST ARM ASSEMBLY AND POLE WITH 15-FT LIGHTING ARMS, EQUIPPED WITH DUAL HPS COBRA HEAD STYLE LUMINAIRES. HPS LUMINAIRES TO BE REMOVED AND SALVAGE. PAID FOR AS REMOVAL OF LUMINAIRE, SALVAGE, ROADWAY. INSTALL LED LUMINAIRES AND SAFETY CABLES. PAID FOR AS LUMINAIRE, LED, ROADWAY, OUTPUT DESIGNATION G AND LUMINAIRE SAFETY CABLE ASSEMBLY RESPECTIVELY.
- 

EXISTING 15-FT MAST ARM LIGHT POLE, EQUIPPED WITH HPS COBRA HEAD STYLE LUMINAIRE. HPS LUMINAIRE TO BE REMOVED AND SALVAGED. PAID FOR AS REMOVAL OF LUMINAIRE, SALVAGE, ROADWAY. INSTALL LED LUMINAIRE AND SAFETY CABLE. PAID FOR AS LUMINAIRE, LED, SPECIAL AND LUMINAIRE SAFETY CABLE ASSEMBLY RESPECTIVELY.



MATCH LINE G



MATCH LINE H

MODEL Default  
FILE Name: S:\JUL1800-4859\801002\Drawings\CAD\CAD\_sheets\801-002\_dht\_Cicero-Ave-09\_03042025.dgn



1170 SOUTH HOUBOLT ROAD  
JOLIET, ILLINOIS 60431  
(815) 744-4200

USER NAME	= JackD	DESIGNED -	JED	REVISED -	
		DRAWN -	JMR	REVISED -	
PLOT SCALE	= 100.0000 ' / in.	CHECKED -	AJR	REVISED -	
PLOT DATE	= 12/11/2025	DATE -	11/17/2025	REVISED -	

STATE OF ILLINOIS  
DEPARTMENT OF TRANSPORTATION


CICERO AVE, 87TH ST. TO 111TH ST.  
REMOVAL AND PROPOSED LIGHTING DRAWINGS


SCALE: 1" = 50'    SHEET 9 OF 12 SHEETS    STA. TO STA.


F.A.P RTE.	SECTION	COUNTY	TOTAL SHEETS	SHEET NO.
350	24-00199-00-LT	COOK	18	13
		CONTRACT NO. 61M20		
		ILLINOIS		




 LEGEND


- 

EXISTING 6-FT MAST ARM LIGHT POLE EQUIPPED WITH HPS COBRA HEAD STYLE LUMINAIRE. HPS LUMINAIRE TO BE REMOVED AND SALVAGED. PAID FOR AS REMOVAL OF LUMINAIRE, SALVAGE, ROADWAY. INSTALL LED LUMINAIRE AND SAFETY CABLE. PAID FOR AS LUMINAIRE, LED, SPECIAL AND LUMINAIRE SAFETY CABLE ASSEMBLY RESPECTIVELY.
- 

 EXISTING COMBINATION MAST ARM ASSEMBLY AND POLE WITH 15-FT LIGHTING ARM, EQUIPPED WITH HPS COBRA HEAD STYLE LUMINAIRE. HPS LUMINAIRE TO BE REMOVED AND SALVAGED. PAID FOR AS REMOVAL OF LUMINAIRE, SALVAGE, ROADWAY. INSTALL LED LUMINAIRE AND SAFETY CABLE. PAID FOR AS LUMINAIRE, LED, SPECIAL AND LUMINAIRE SAFETY CABLE ASSEMBLY RESPECTIVELY.
- 

EXISTING COMBINATION MAST ARM ASSEMBLY AND POLE WITH 15-FT LIGHTING ARMS, EQUIPPED WITH DUAL HPS COBRA HEAD STYLE LUMINAIRES. HPS LUMINAIRES TO BE REMOVED AND SALVAGE. PAID FOR AS REMOVAL OF LUMINAIRE, SALVAGE, ROADWAY. INSTALL LED LUMINAIRES AND SAFETY CABLES. PAID FOR AS LUMINAIRE, LED, ROADWAY, OUTPUT DESIGNATION G AND LUMINAIRE SAFETY CABLE ASSEMBLY RESPECTIVELY.
- 

EXISTING 15-FT MAST ARM LIGHT POLE, EQUIPPED WITH HPS COBRA HEAD STYLE LUMINAIRE. HPS LUMINAIRE TO BE REMOVED AND SALVAGED. PAID FOR AS REMOVAL OF LUMINAIRE, SALVAGE, ROADWAY. INSTALL LED LUMINAIRE AND SAFETY CABLE. PAID FOR AS LUMINAIRE, LED, SPECIAL AND LUMINAIRE SAFETY CABLE ASSEMBLY RESPECTIVELY.

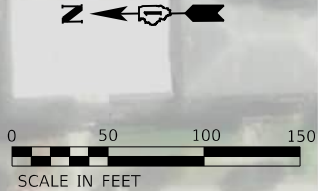

MATCH LINE H

MATCH LINE I

IL RTE. 50 (CICERO AVE)

108TH STREET

107TH STREET

MODEL Default  
FILE Name: S:\JUL1800-4899\801002\Drawings\CAD\CAD\_sheets\801-002\_dht\_Cicero-Ave-10\_03042025.dgn



1170 SOUTH HOUBOLT ROAD  
JOLIET, ILLINOIS 60431  
(815) 744-4200

USER NAME	= JackD	DESIGNED -	JED	REVISED -	
		DRAWN -	JMR	REVISED -	
PLOT SCALE	= 100,0000 ' / in.	CHECKED -	AJR	REVISED -	
PLOT DATE	= 12/11/2025	DATE	= 11/17/2025	REVISED -	

STATE OF ILLINOIS  
DEPARTMENT OF TRANSPORTATION


CICERO AVE, 87TH ST. TO 111TH ST.  
REMOVAL AND PROPOSED LIGHTING DRAWINGS


SCALE: 1" = 50' SHEET 10 OF 12 SHEETS STA. TO STA.


F.A.P. RTE.	SECTION	COUNTY	TOTAL SHEETS	SHEET NO.
350	24-00199-00-LT	COOK	18	14
		CONTRACT NO. 61M20		
		ILLINOIS		




 LEGEND


- 

EXISTING 6-FT MAST ARM LIGHT POLE EQUIPPED WITH HPS COBRA HEAD STYLE LUMINAIRE. HPS LUMINAIRE TO BE REMOVED AND SALVAGED. PAID FOR AS REMOVAL OF LUMINAIRE, SALVAGE, ROADWAY. INSTALL LED LUMINAIRE AND SAFETY CABLE. PAID FOR AS LUMINAIRE, LED, SPECIAL AND LUMINAIRE SAFETY CABLE ASSEMBLY RESPECTIVELY.
- 

 EXISTING COMBINATION MAST ARM ASSEMBLY AND POLE WITH 15-FT LIGHTING ARM, EQUIPPED WITH HPS COBRA HEAD STYLE LUMINAIRE. HPS LUMINAIRE TO BE REMOVED AND SALVAGED. PAID FOR AS REMOVAL OF LUMINAIRE, SALVAGE, ROADWAY. INSTALL LED LUMINAIRE AND SAFETY CABLE. PAID FOR AS LUMINAIRE, LED, SPECIAL AND LUMINAIRE SAFETY CABLE ASSEMBLY RESPECTIVELY.
- 

EXISTING COMBINATION MAST ARM ASSEMBLY AND POLE WITH 15-FT LIGHTING ARMS, EQUIPPED WITH DUAL HPS COBRA HEAD STYLE LUMINAIRES. HPS LUMINAIRES TO BE REMOVED AND SALVAGE. PAID FOR AS REMOVAL OF LUMINAIRE, SALVAGE, ROADWAY. INSTALL LED LUMINAIRES AND SAFETY CABLES. PAID FOR AS LUMINAIRE, LED, ROADWAY, OUTPUT DESIGNATION G AND LUMINAIRE SAFETY CABLE ASSEMBLY RESPECTIVELY.
- 

EXISTING 15-FT MAST ARM LIGHT POLE, EQUIPPED WITH HPS COBRA HEAD STYLE LUMINAIRE. HPS LUMINAIRE TO BE REMOVED AND SALVAGED. PAID FOR AS REMOVAL OF LUMINAIRE, SALVAGE, ROADWAY. INSTALL LED LUMINAIRE AND SAFETY CABLE. PAID FOR AS LUMINAIRE, LED, SPECIAL AND LUMINAIRE SAFETY CABLE ASSEMBLY RESPECTIVELY.

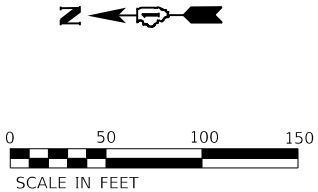

MATCH LINE I

109TH STREET

W 110TH STREET

IL RTE. 50 (CICERO AVE)

MATCH LINE J

MODEL: Default  
FILE: \\wms01\301\041800-4899\4801002\Drawings\CAD\CAD\_sheets\4801-002\_dht\_Cicero-Ave-11\_03042025.dgn



1170 SOUTH HOUBOLT ROAD  
JOLIET, ILLINOIS 60431

USER NAME	= JackD
PLOT SCALE	= 100,0000 ' / in.
PLOT DATE	= 12/11/2025

DESIGNED -	JED
DRAWN -	JMR
CHECKED -	AJR
DATE -	11/17/2025

REVISED -	
REVISED -	
REVISED -	
REVISED -	


STATE OF ILLINOIS  
DEPARTMENT OF TRANSPORTATION


CICERO AVE, 87TH ST. TO 111TH ST.  
REMOVAL AND PROPOSED LIGHTING DRAWINGS


SCALE: 1" = 50' SHEET 11 OF 12 SHEETS STA. TO STA.


F.A.P RTE.	SECTION	COUNTY	TOTAL SHEETS	SHEET NO.
350	24-00199-00-LT	COOK	18	15
CONTRACT NO. 61M20				
ILLINOIS				

 LEGEND

- 

 EXISTING 6-FT MAST ARM LIGHT POLE EQUIPPED WITH HPS COBRA HEAD STYLE LUMINAIRE. HPS LUMINAIRE TO BE REMOVED AND SALVAGED. PAID FOR AS REMOVAL OF LUMINAIRE, SALVAGE, ROADWAY. INSTALL LED LUMINAIRE AND SAFETY CABLE. PAID FOR AS LUMINAIRE, LED, SPECIAL AND LUMINAIRE SAFETY CABLE ASSEMBLY RESPECTIVELY.
- 

 EXISTING COMBINATION MAST ARM ASSEMBLY AND POLE WITH 15-FT LIGHTING ARM, EQUIPPED WITH HPS COBRA HEAD STYLE LUMINAIRE. HPS LUMINAIRE TO BE REMOVED AND SALVAGED. PAID FOR AS REMOVAL OF LUMINAIRE, SALVAGE, ROADWAY. INSTALL LED LUMINAIRE AND SAFETY CABLE. PAID FOR AS LUMINAIRE, LED, SPECIAL AND LUMINAIRE SAFETY CABLE ASSEMBLY RESPECTIVELY.
- 

EXISTING COMBINATION MAST ARM ASSEMBLY AND POLE WITH 15-FT LIGHTING ARMS, EQUIPPED WITH DUAL HPS COBRA HEAD STYLE LUMINAIRES. HPS LUMINAIRES TO BE REMOVED AND SALVAGE. PAID FOR AS REMOVAL OF LUMINAIRE, SALVAGE, ROADWAY. INSTALL LED LUMINAIRES AND SAFETY CABLES. PAID FOR AS LUMINAIRE, LED, ROADWAY, OUTPUT DESIGNATION G AND LUMINAIRE SAFETY CABLE ASSEMBLY RESPECTIVELY.
- 

EXISTING 15-FT MAST ARM LIGHT POLE, EQUIPPED WITH HPS COBRA HEAD STYLE LUMINAIRE. HPS LUMINAIRE TO BE REMOVED AND SALVAGED. PAID FOR AS REMOVAL OF LUMINAIRE, SALVAGE, ROADWAY. INSTALL LED LUMINAIRE AND SAFETY CABLE. PAID FOR AS LUMINAIRE, LED, SPECIAL AND LUMINAIRE SAFETY CABLE ASSEMBLY RESPECTIVELY.



MATCH LINE J



MODEL Default  
FILE Name: S:\JUL1800-4899\801002\Drawings\CAD\CAD\_sheets\801-002\_dht\_Cicero-Ave-12\_03042025.dgn



1170 SOUTH HOUBOLT ROAD  
JOLIET, ILLINOIS 60431  
(815) 744-4200

USER NAME	= JackD
DESIGNED	- JED
DRAWN	- JMR
PLOT SCALE	= 100,0000 ' / in.
PLOT DATE	= 12/11/2025

CHECKED	- AJR
DATE	- 11/17/2025

REVISED	-
REVISED	-
REVISED	-
REVISED	-

STATE OF ILLINOIS  
DEPARTMENT OF TRANSPORTATION


CICERO AVE, 87TH ST. TO 111TH ST.  
REMOVAL AND PROPOSED LIGHTING DRAWINGS

SCALE: 1" = 50'    SHEET 12 OF 12 SHEETS    STA.    TO STA.


F.A.P RTE.	SECTION	COUNTY	TOTAL SHEETS	SHEET NO.
350	24-00199-00-LT	COOK	18	16
CONTRACT NO. 61M20				
ILLINOIS				





MODEL Default: H:\1. Model - provided\anorm\des\illinois\anorm\1002\Drawings\CAD\CAD\_sheets\0801-004-sh\_Cicero Avenue D1 Details.dgn

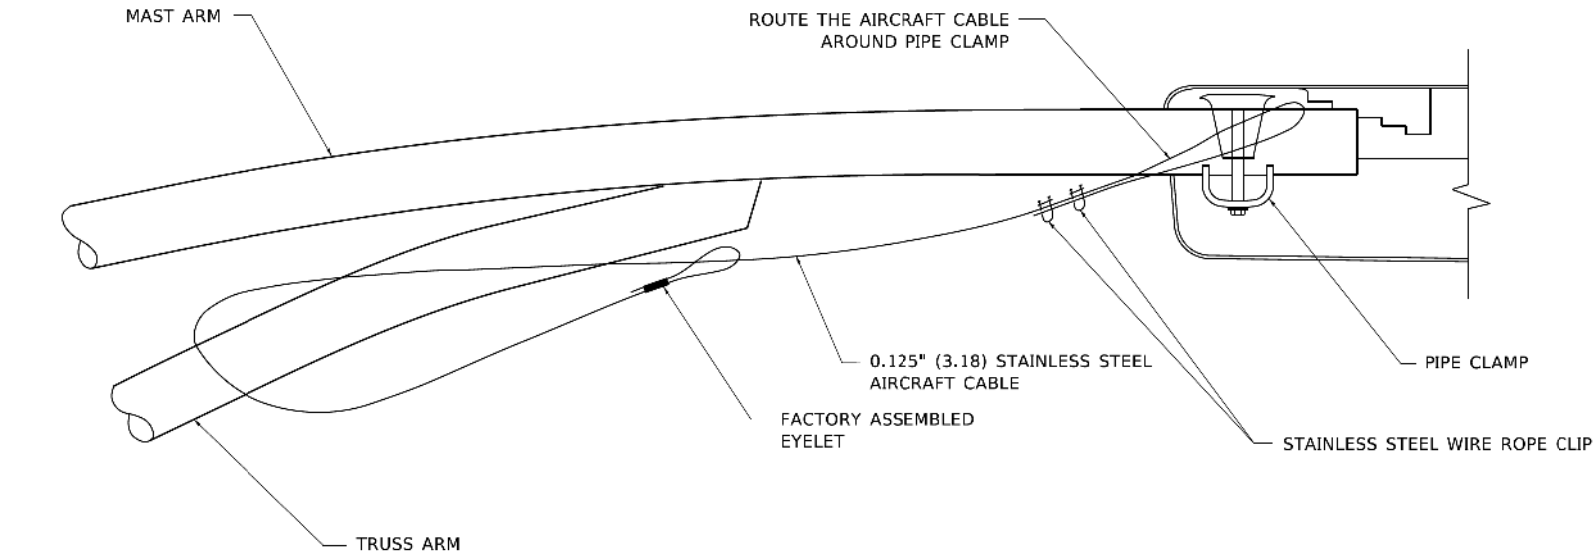

**SIDE VIEW (TRUSS ARM)**  
**N.T.S.**

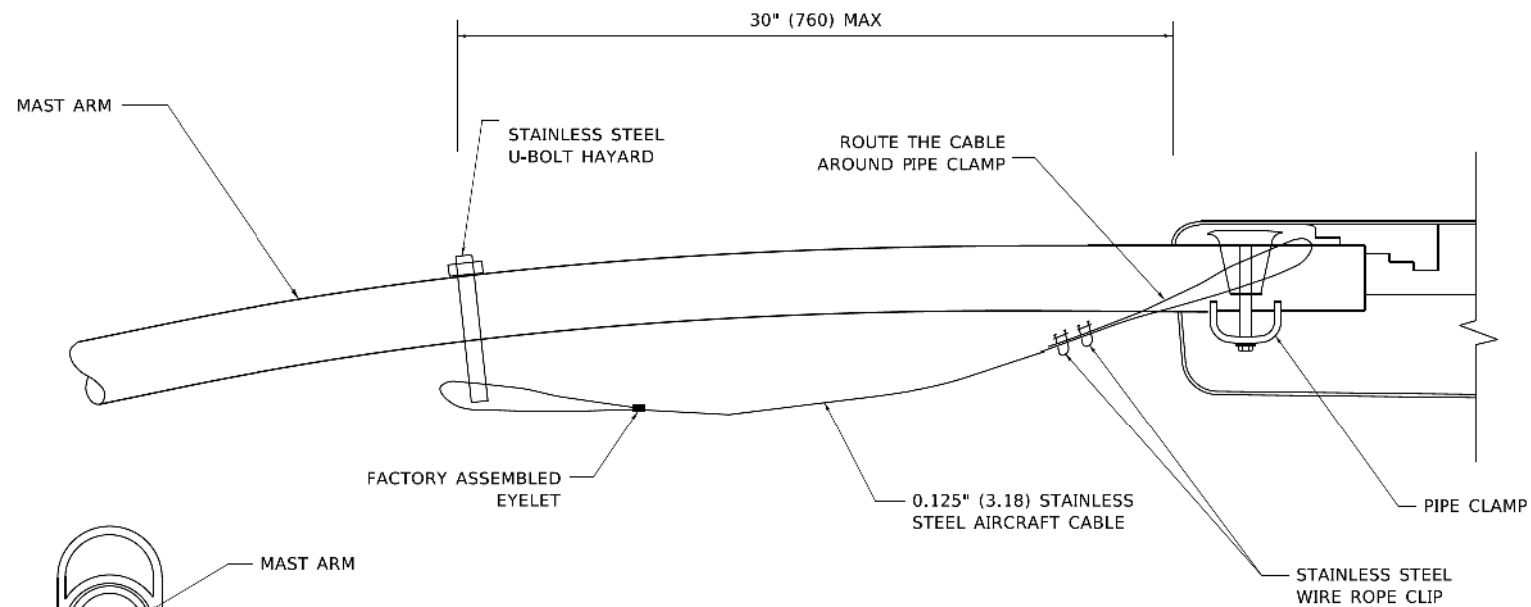

**SIDE VIEW (SINGLE MEMBER OR DAVIT ARM)**  
**N.T.S.**

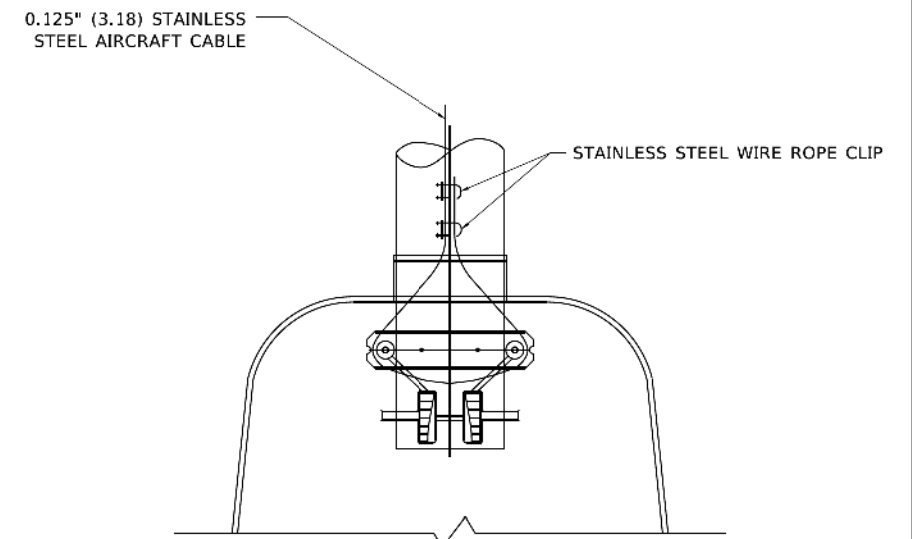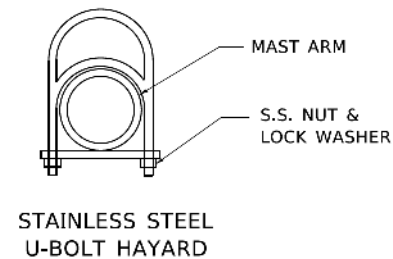


**BOTTOM VIEW**  
**N.T.S.**

**NOTES:**


1. ALL DIMENSIONS ARE IN MILLIMETERS (INCHES) UNLESS OTHERWISE SHOWN.
2. CONTRACTOR SHALL ADJUST THE WIRE CLIP TO ELIMINATE ANY SLACK FROM THE WIRE ROPE.
3. THE 0.125" (3.18) STAINLESS STEEL AIRCRAFT CABLE SHALL REMAIN VISIBLE FROM THE GROUND LEVEL.
4. THE BREAKING STRENGTH OF THE CABLE SHALL BE 1700 LBS. MIN.

FILE NAME: Default.dwg	USER NAME = [username]			DESIGNED - [username]		REVISED - 08-08-03		STATE OF ILLINOIS DEPARTMENT OF TRANSPORTATION	LUMINAIRE SAFETY CABLE ASSEMBLY						F.A. RTE.		SECTION		COUNTY		TOTAL SHEETS		SHEET NO.	
	PLOT SCALE = 50.0000 ' / in.			DRAWN - [username]		REVISED - [username]																		
	PLOT DATE = 4/19/2019			CHECKED - [username]		REVISED - [username]									BE-701									
				DATE - [date]		REVISED - [date]			SCALE: NONE						SHEET 1		OF 1		SHEETS		STA.		TO STA.	
																	ILLINOIS		FCD. AID PROJECT					


TH HOUBOLT ROAD ILINOIS 60431 4200	USER NAME = JackD			DESIGNED - JED		REVISED - [username]		STATE OF ILLINOIS DEPARTMENT OF TRANSPORTATION	CICERO AVE. 87TH ST. TO 111TH ST. DISTRICT ONE DETAILS						F.A.P RTE.		SECTION		COUNTY		TOTAL SHEETS		SHEET NO.	
	PLOT SCALE = 100.0000 ' / in.			DRAWN - JMR		REVISED - [username]									350		24-00199-00-LT		COOK		18		17	
	PLOT DATE = 12/11/2025			CHECKED - AJR		REVISED - [username]																		
				DATE - 11/17/2025		REVISED - [date]			SCALE:						SHEET 1		OF 2		SHEETS		STA.		TO STA.	
																	ILLINOIS						CONTRACT NO. 61M20	

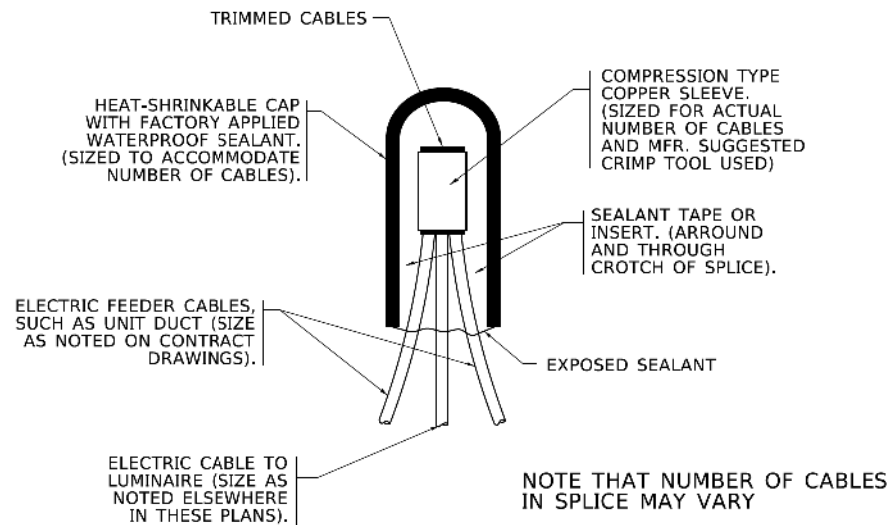

**TYPICAL SPLICE DETAIL**  
**N.T.S.**

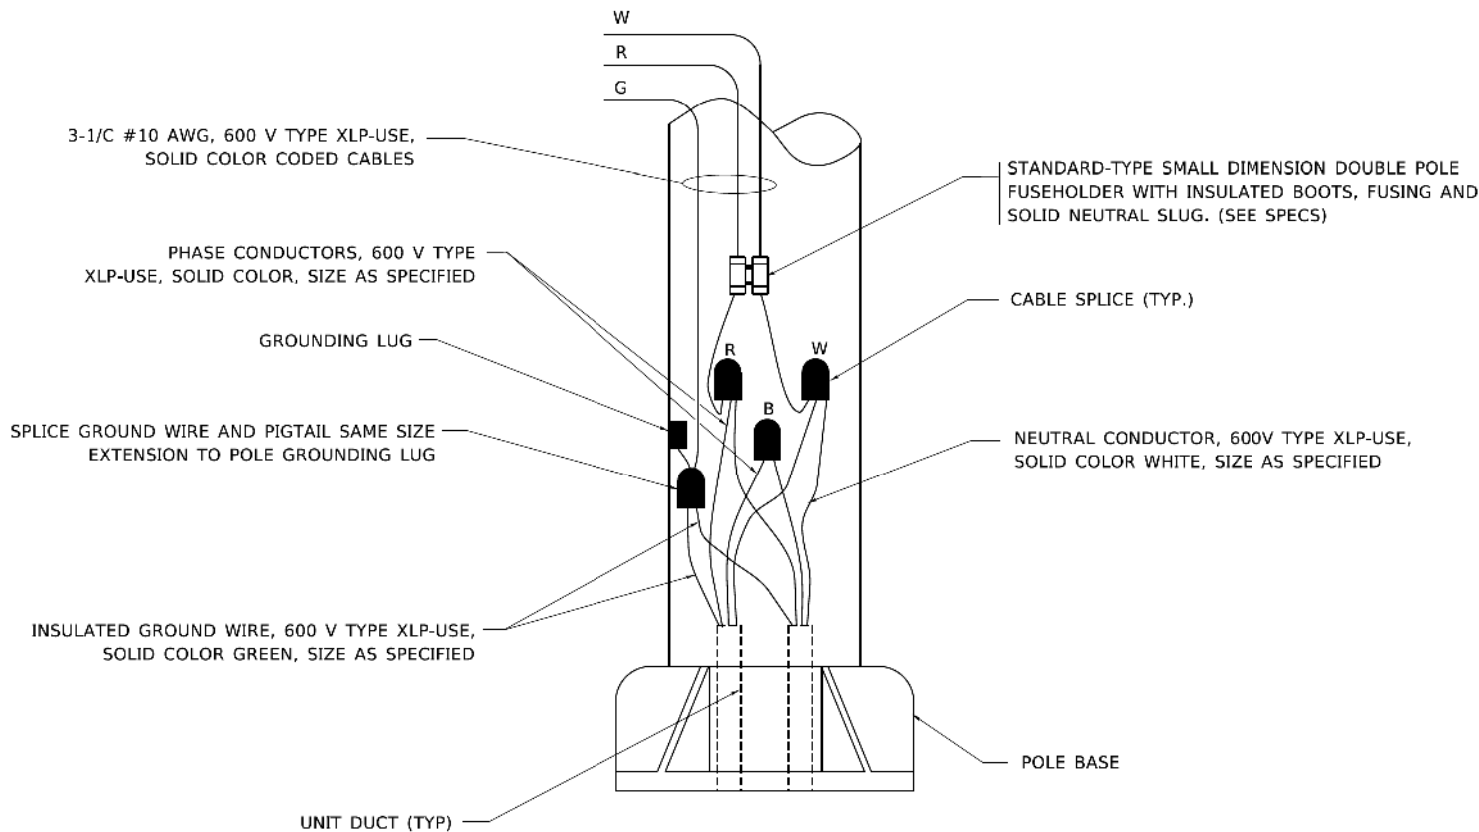

**POLE WIRING DETAIL**  
**N.T.S.**

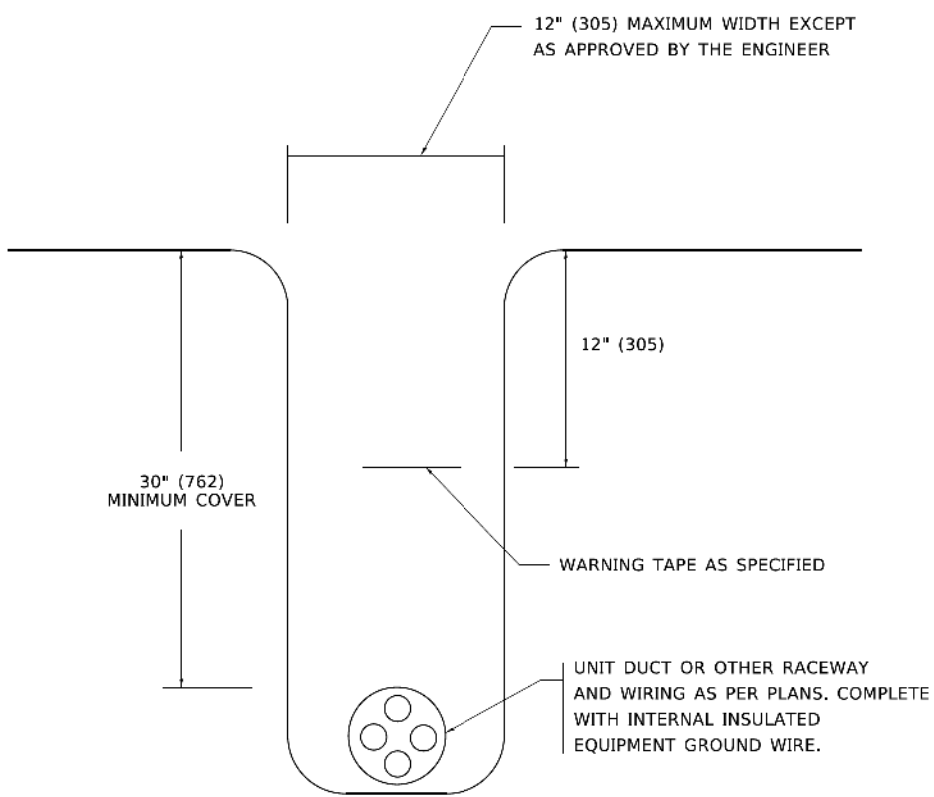

**TYPICAL WIRING IN TRENCH DETAIL**  
**N.T.S.**

MODEL Default: H:\1170 South Houbolt Road\1170\Drawings\CAD\CAD\_sheets\60431-004-sh\_Cicero Avenue D1 Details.dgn

USER NAME = lrysz	DESIGNED -	REVISED - 02/04/2020
	DRAWN -	REVISED -
PLOT SCALE = 50.0000 " / in.	CHECKED -	REVISED -
PLOT DATE = 12/2/2020	DATE - 08/08/2003	REVISED -

STATE OF ILLINOIS  
DEPARTMENT OF TRANSPORTATION

MISC. ELECTRICAL DETAILS  
SHEET A

SCALE: NONE | SHEET 1 OF 1 SHEETS | STA. TO STA.

F.A.P. RTE.	SECTION	COUNTY	TOTAL SHEETS	SHEET NO.
	BE-702			
CONTRACT NO.				
ILLINOIS   FED. AID PROJECT				

MODEL Default: H:\1170 South Houbolt Road\1170\Drawings\CAD\CAD\_sheets\60431-004-sh\_Cicero Avenue D1 Details.dgn



1170 SOUTH HOUBOLT ROAD  
JOLIET, ILLINOIS 60431  
(815) 744-4200

USER NAME = JackD	DESIGNED - JED	REVISED -
	DRAWN - JMR	REVISED -
PLOT SCALE = 100.0000 " / in.	CHECKED - AJR	REVISED -
PLOT DATE = 12/11/2025	DATE - 11/17/2025	REVISED -

STATE OF ILLINOIS  
DEPARTMENT OF TRANSPORTATION

CICERO AVE. 87TH ST. TO 111TH ST.  
DISTRICT ONE DETAILS

SCALE: | SHEET 2 OF 2 SHEETS | STA. TO STA.

F.A.P. RTE.	SECTION	COUNTY	TOTAL SHEETS	SHEET NO.
350	24-00199-00-LT	COOK	18	18
CONTRACT NO. 61M20				
ILLINOIS				