



IDOT ETP BUILDING (35TH & NORMAL) DAN RYAN EXPY / W. 33TH ST.

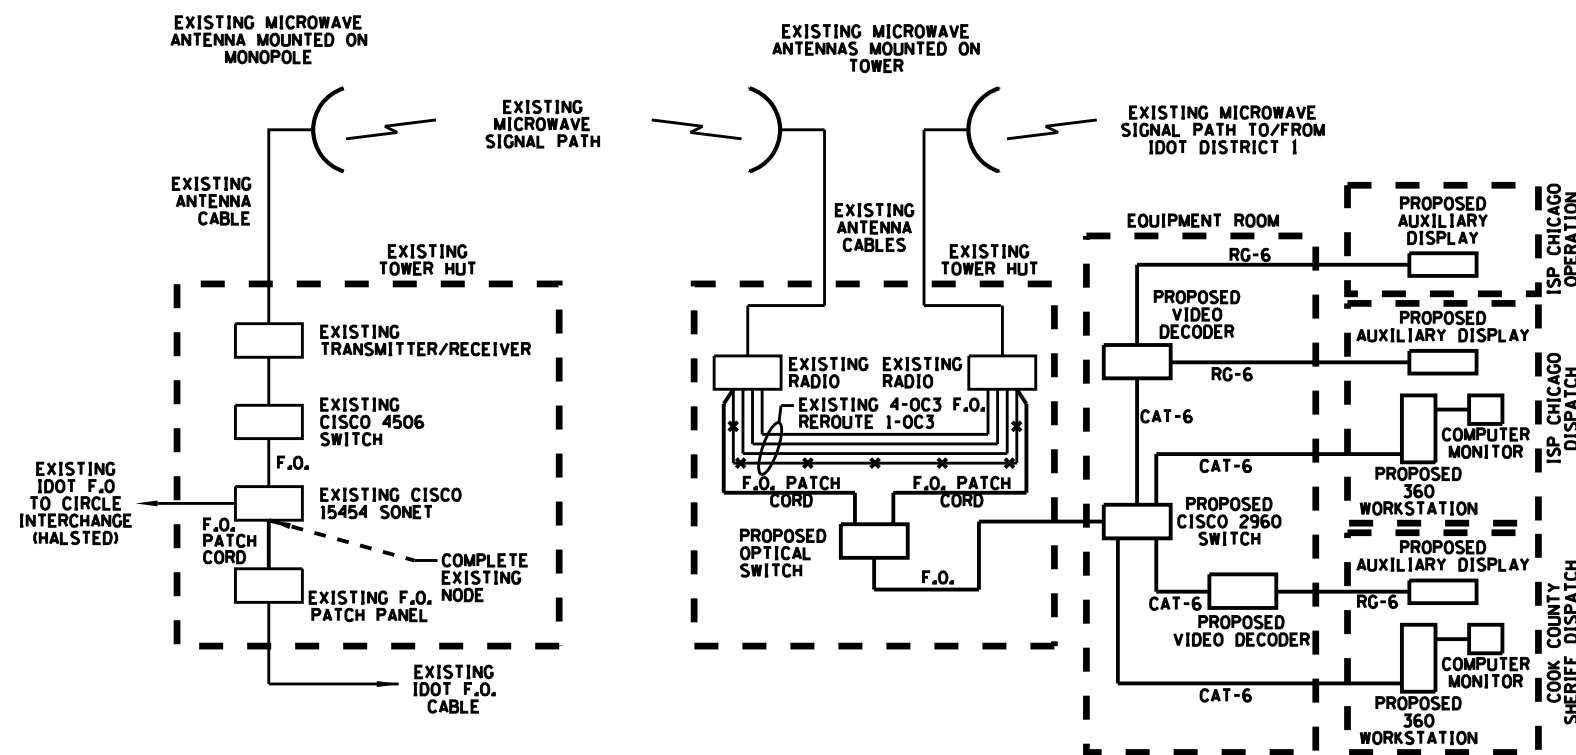

BUILDING E (KENNEDY / EDENS EXPY) ISP CHICAGO / COOK COUNTY SHERIFF

EXISTING CONDITIONS SHOWN IN HALF TONE
PROPOSED CONDITIONS SHOWN IN BOLD

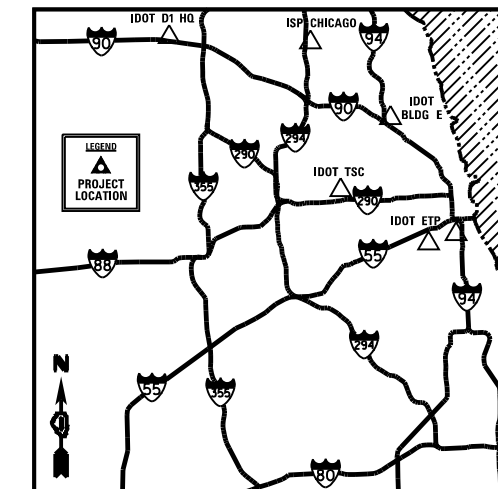

FILE NAME : SF1E15	USER NAME : RUSERS	DESIGNED : R.T.	REVISED : -
		DRAWN : G.M.	REVISED : -
		CHECKED : R.T.	REVISED : -
		DATE : 12/11/2013	REVISED : -

STATE OF ILLINOIS
DEPARTMENT OF TRANSPORTATION

ITS CENTER-TO-CENTER INTEGRATION PROJECT	
ONE LINE DIAGRAMS	
SCALE: N.T.S.	SHEET NO. OF SHEETS STA. TO STA.

F.A. RTE.	SECTION 2009-0871	COUNTY COOK	TOTAL SHEETS 25	SHEET NO. 8
			CONTRACT NO. 60134	
ILLINOIS FED. AID PROJECT				