
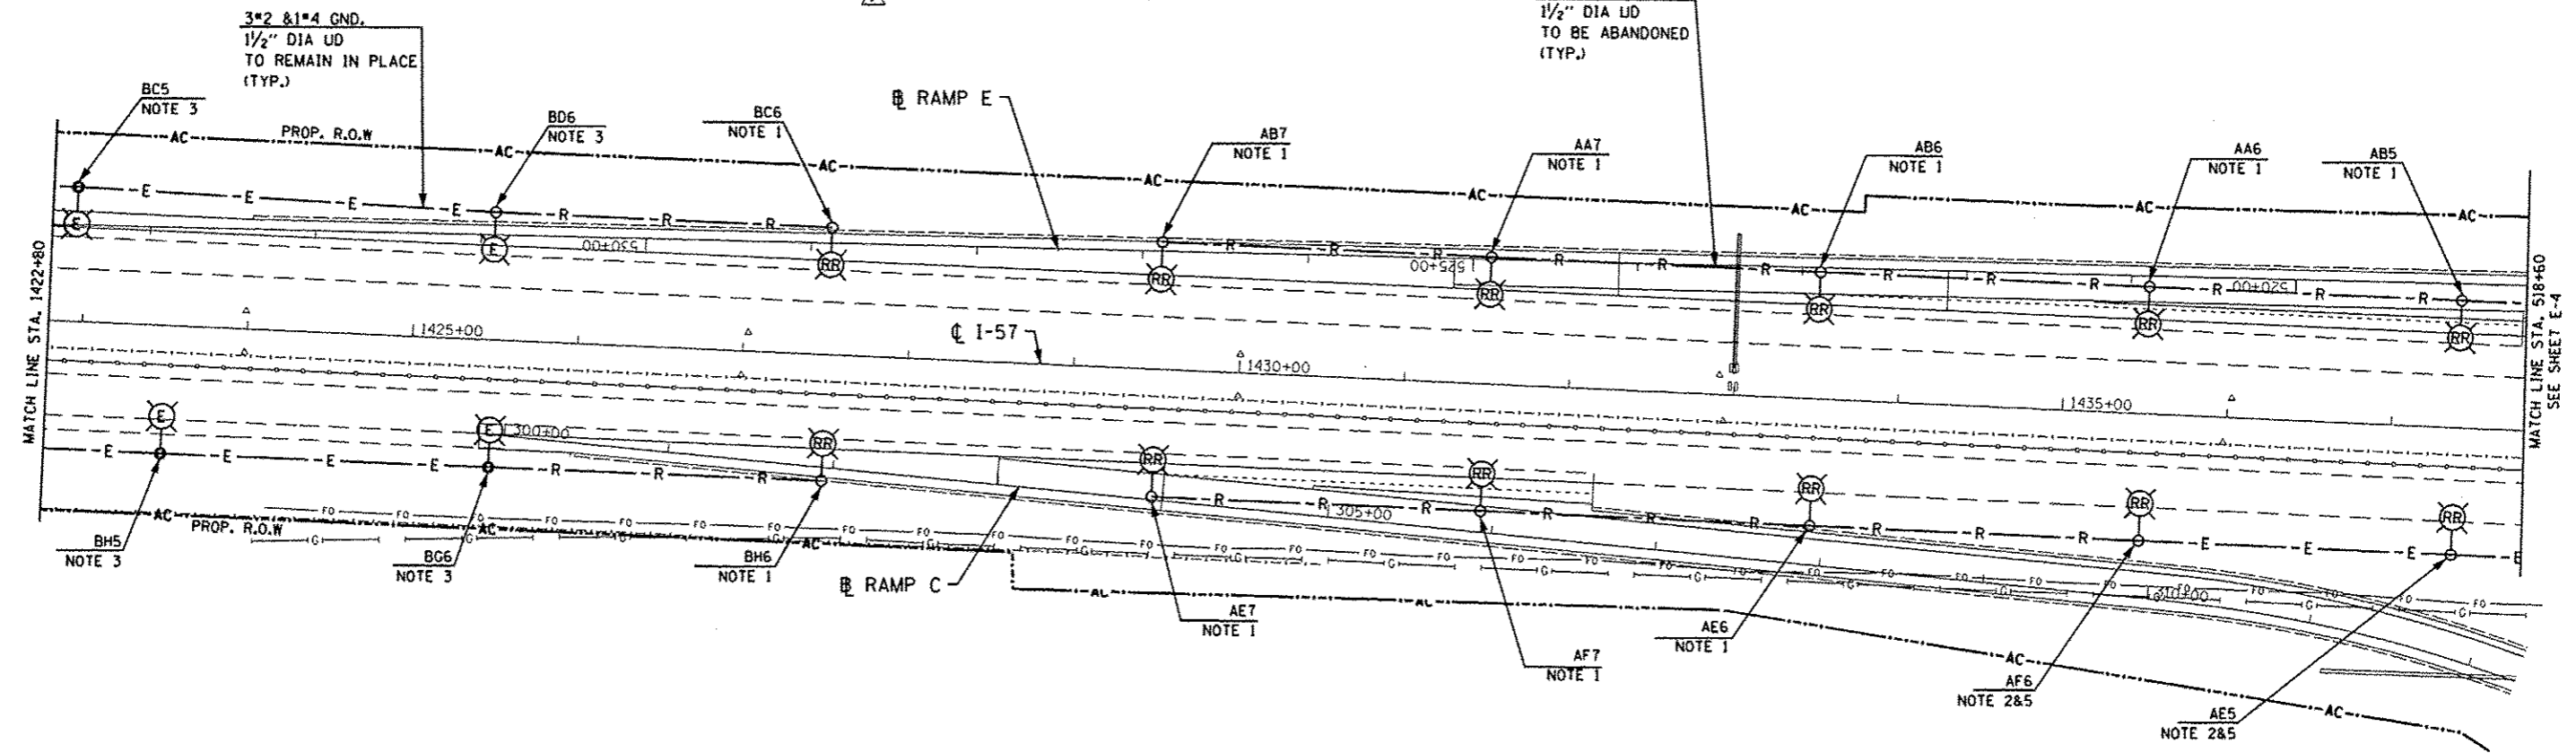


**NOTES:**

1. THE EXISTING LIGHT POLE, METAL FOUNDATION AND BREAKAWAY TRANSFORMER BASE SHALL BE REMOVED. THE METAL FOUNDATION SHALL BE REMOVED AND DISPOSED OF OFF THE PROJECT SITE. REMOVED LIGHT POLE AND BREAKAWAY TRANSFORMER BASE SHALL BE REINSTALLED AS SHOWN ON PROPOSED LIGHTING PLANS. THE REMOVAL, STORAGE DURING CONSTRUCTION AND REINSTALLATION OF REMOVED LIGHT POLE AND BREAKAWAY TRANSFORMER BASE SHALL BE PART OF THE PAY ITEM "RELOCATE EXISTING LIGHTING UNIT"
2. THE EXISTING LIGHT POLE SHALL BE REMOVED, METAL FOUNDATION AND BREAKAWAY TRANSFORMER BASE SHALL REMAIN IN PLACE. THE REMOVAL, STORAGE DURING CONSTRUCTION AND REINSTALLATION OF REMOVED LIGHT POLE SHALL BE PART OF THE PAY ITEM "RELOCATE EXISTING LIGHTING UNIT"
3. THE EXISTING 310W HPS LUMINAIRE SHALL BE REMOVED AND TEMPORARY 400W HPS TYPE III LUMINAIRE SHALL BE INSTALLED ON EXISTING LIGHTING UNIT. THE CONTRACTOR SHALL STORE THE EXISTING 310W HPS LUMINAIRE AND REINSTALL WITH NEW LAMP AFTER COMPLETION OF STAGE 2 CONSTRUCTION.
4. THE EXISTING LIGHTING SYSTEM SHALL BE REMOVED AFTER TEMPORARY LIGHTING SYSTEM IS INSTALLED AND MADE OPERATIONAL.
5. THE EXPOSED EXISTING UNIT DUCTS SHALL BE PROTECTED DURING CONSTRUCTION, THE SUGGESTED ALTERNATIVE IS TO INSTALL ANOTHER TRANSFORMER BASE ON TOP OF EXISTING TRANSFORMER BASE AND COVER IT WITH METAL PLATE. ANY DAMAGED AND MISSING EXISTING UNIT DUCTS AND TRANSFORMER BASE DURING CONSTRUCTION AFTER REMOVAL OF EXISTING LIGHT POLE SHALL BE REPLACED IN KIND BY THE CONTRACTOR AT NO ADDITIONAL COST. THE MATERIALS AND LABOR NEEDED FOR PROTECTION OF EXPOSED UNIT DUCTS SHALL BE INCLUDED AS PART OF THE PAY ITEM "MAINTENANCE OF LIGHTING SYSTEM"

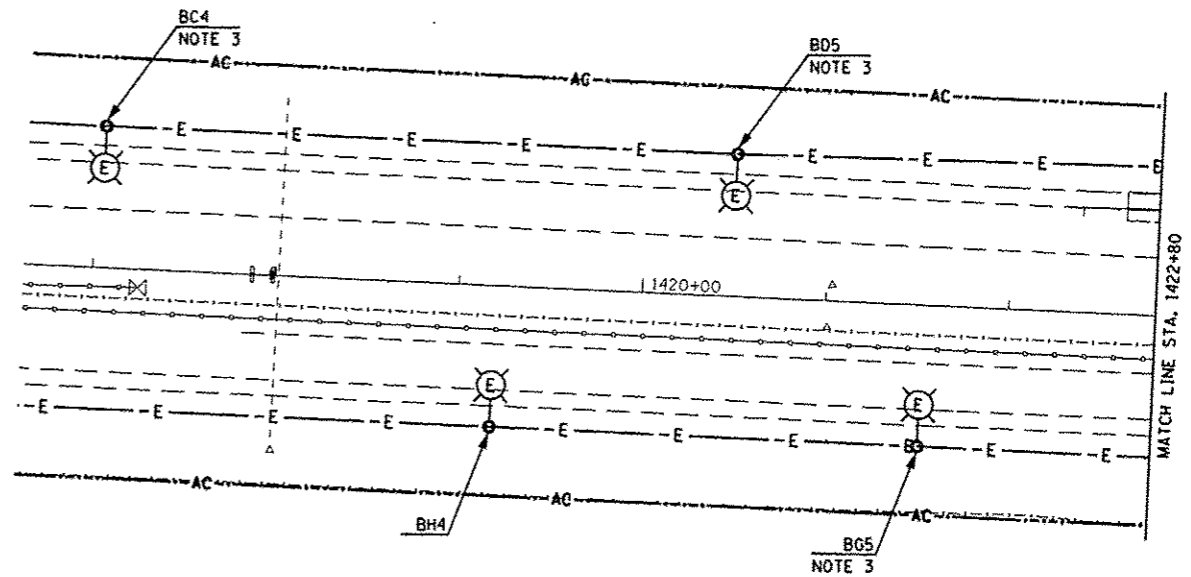

3\*2 & 1\*4 GND.  
1/2" DIA UD  
TO BE ABANDONED  
(TYP.)

3\*2 & 1\*4 GND.  
1/2" DIA UD  
TO REMAIN IN PLACE  
(TYP.)

I:\271\CONV\CADD\_Sheet\6\606\69-stf-light-03.dgn  
 26-DEC-2013 15:08 TIME\$



USER NAME * hprajapati	DESIGNED - RDP	REVISED 6/18/2013
PLLOT SCALE * 100.000000/1.000000	DRAWN - MG/WC	REVISED 8/22/2013
DATE * 26-DEC-2013 15:00	CHECKED - KGP	REVISED 10/16/2013
	DATE - 8/22/2013	REVISED 12/04/2013

STATE OF ILLINOIS  
DEPARTMENT OF TRANSPORTATION

STUENKEL ROAD OVER I-57  
EXISTING LIGHTING REMOVAL PLANS  
SCALE: AS NOTED SHEET NO. 3 OF 24 SHEETS STA. ---- TO STA. ----

F.A.I. RTE.	SECTION	COUNTY	TOTAL SHEETS	SHEET NO.
57	99-1HB-R	WILL	679	326
CONTRACT NO. 60L69			ILLINOIS FED. AID PROJECT	